


EXHIBIT B

(Not to scale)

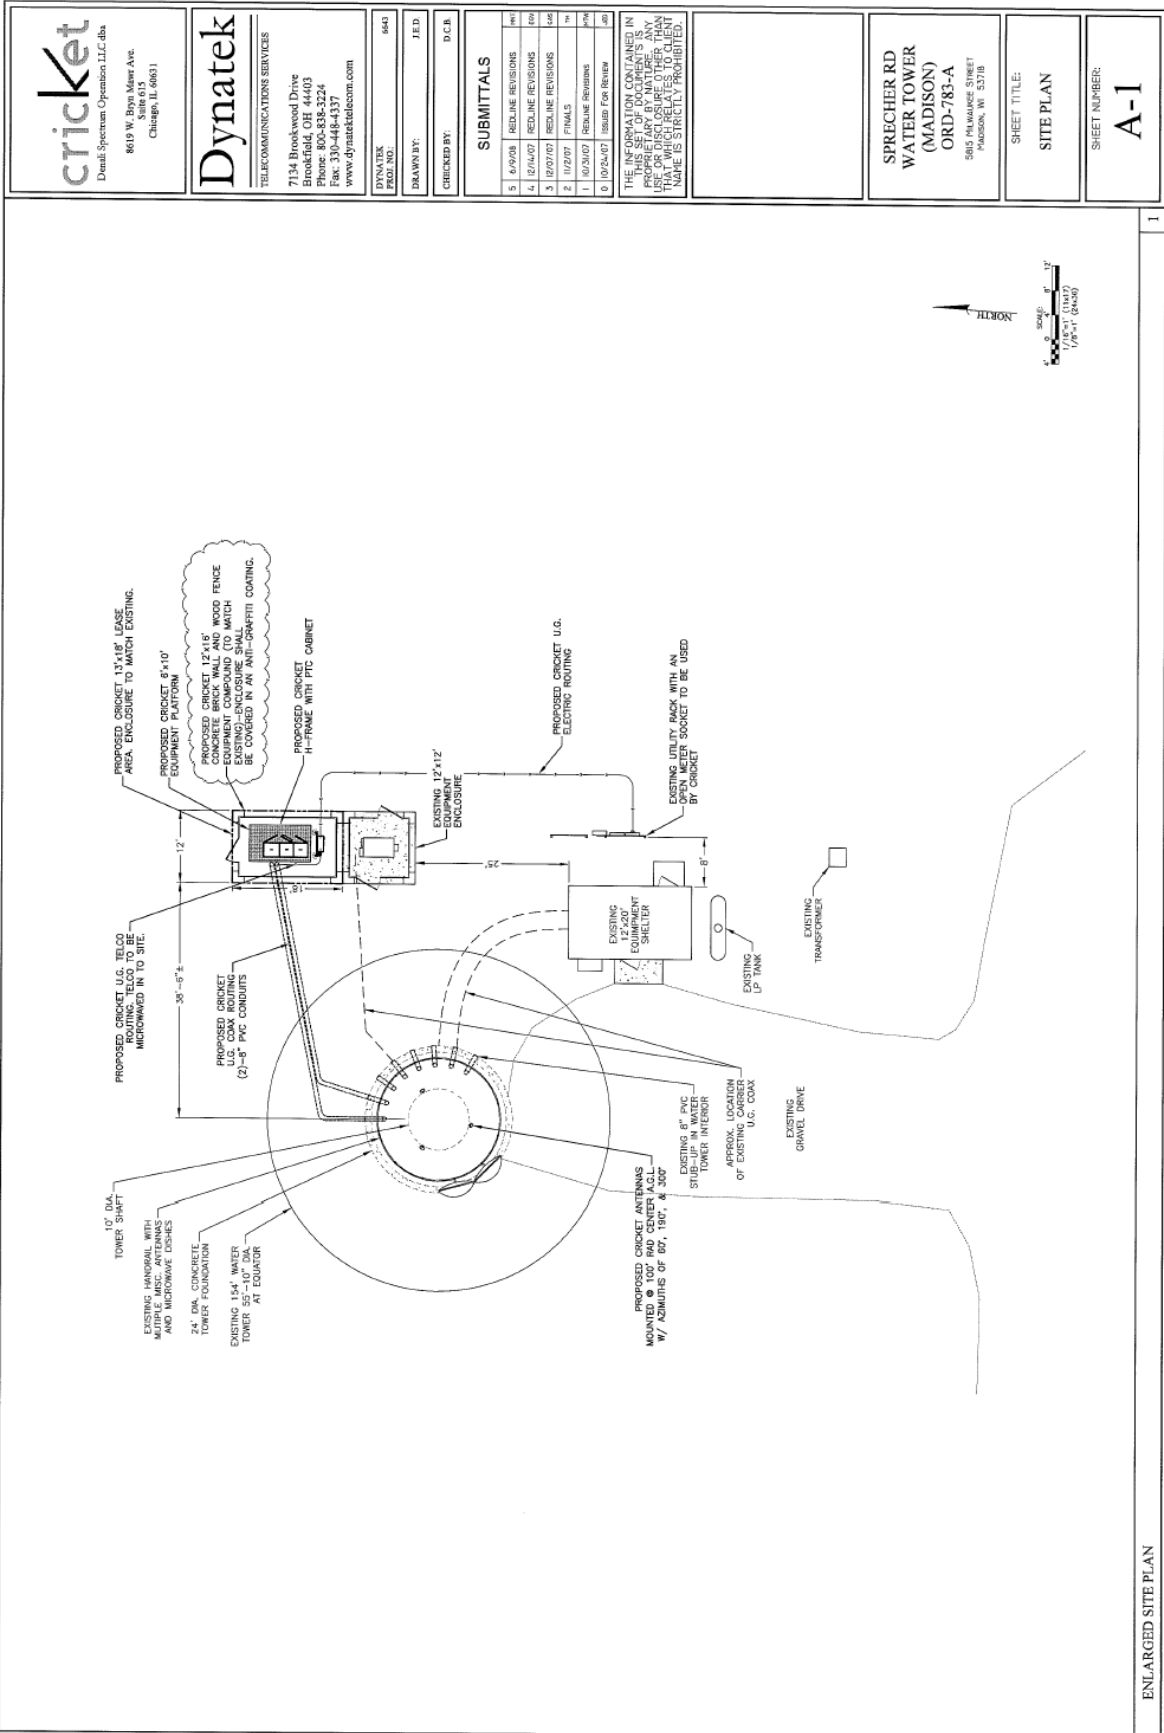

cricket
 Detail Spectrum Operation LLC dba
 8619 W. Bryn Mawr Ave.
 Suite 100
 Chicago, IL 60631

Dynatek
 TELECOMMUNICATIONS SERVICES
 7134 Brookwood Drive
 Brookfield, OH 44003
 Phone: 800-838-3224
 Fax: 330-448-4337
 www.dynatektelecom.com

DYNATEK
 PROJ. NO. 9443
 DRAWN BY: J.E.D.
 CHECKED BY: D.C.B.

SUBMITTALS

| | | | |
|---|----------|-------------------|-----|
| 5 | 6/29/08 | REDLINE REVISIONS | REV |
| 4 | 12/16/07 | REDLINE REVISIONS | REV |
| 3 | 12/09/07 | REDLINE REVISIONS | REV |
| 2 | 11/29/07 | REDLINE REVISIONS | REV |
| 1 | 10/20/07 | REDLINE REVISIONS | REV |
| 0 | 10/20/07 | Issued For Review | REV |

THE INFORMATION CONTAINED IN THIS DRAWING IS THE PROPERTY OF DYNATEK. IT IS TO BE USED ONLY FOR THE PROJECT AND SITE SPECIFICALLY IDENTIFIED HEREIN. ANY REUSE OR DISCLOSURE OF THIS INFORMATION TO ANY OTHER PARTY WITHOUT THE WRITTEN PERMISSION OF DYNATEK IS STRICTLY PROHIBITED.

**SPRECHER RD
 WATER TOWER
 (MADISON)
 ORD-783-A**
 5865 MILWAUKEE STREET
 MADISON, WI 53718

SHEET TITLE:
SITE PLAN

SHEET NUMBER:
A-1

ENLARGED SITE PLAN