


REVISED

10:00 am, Jun 12, 2013

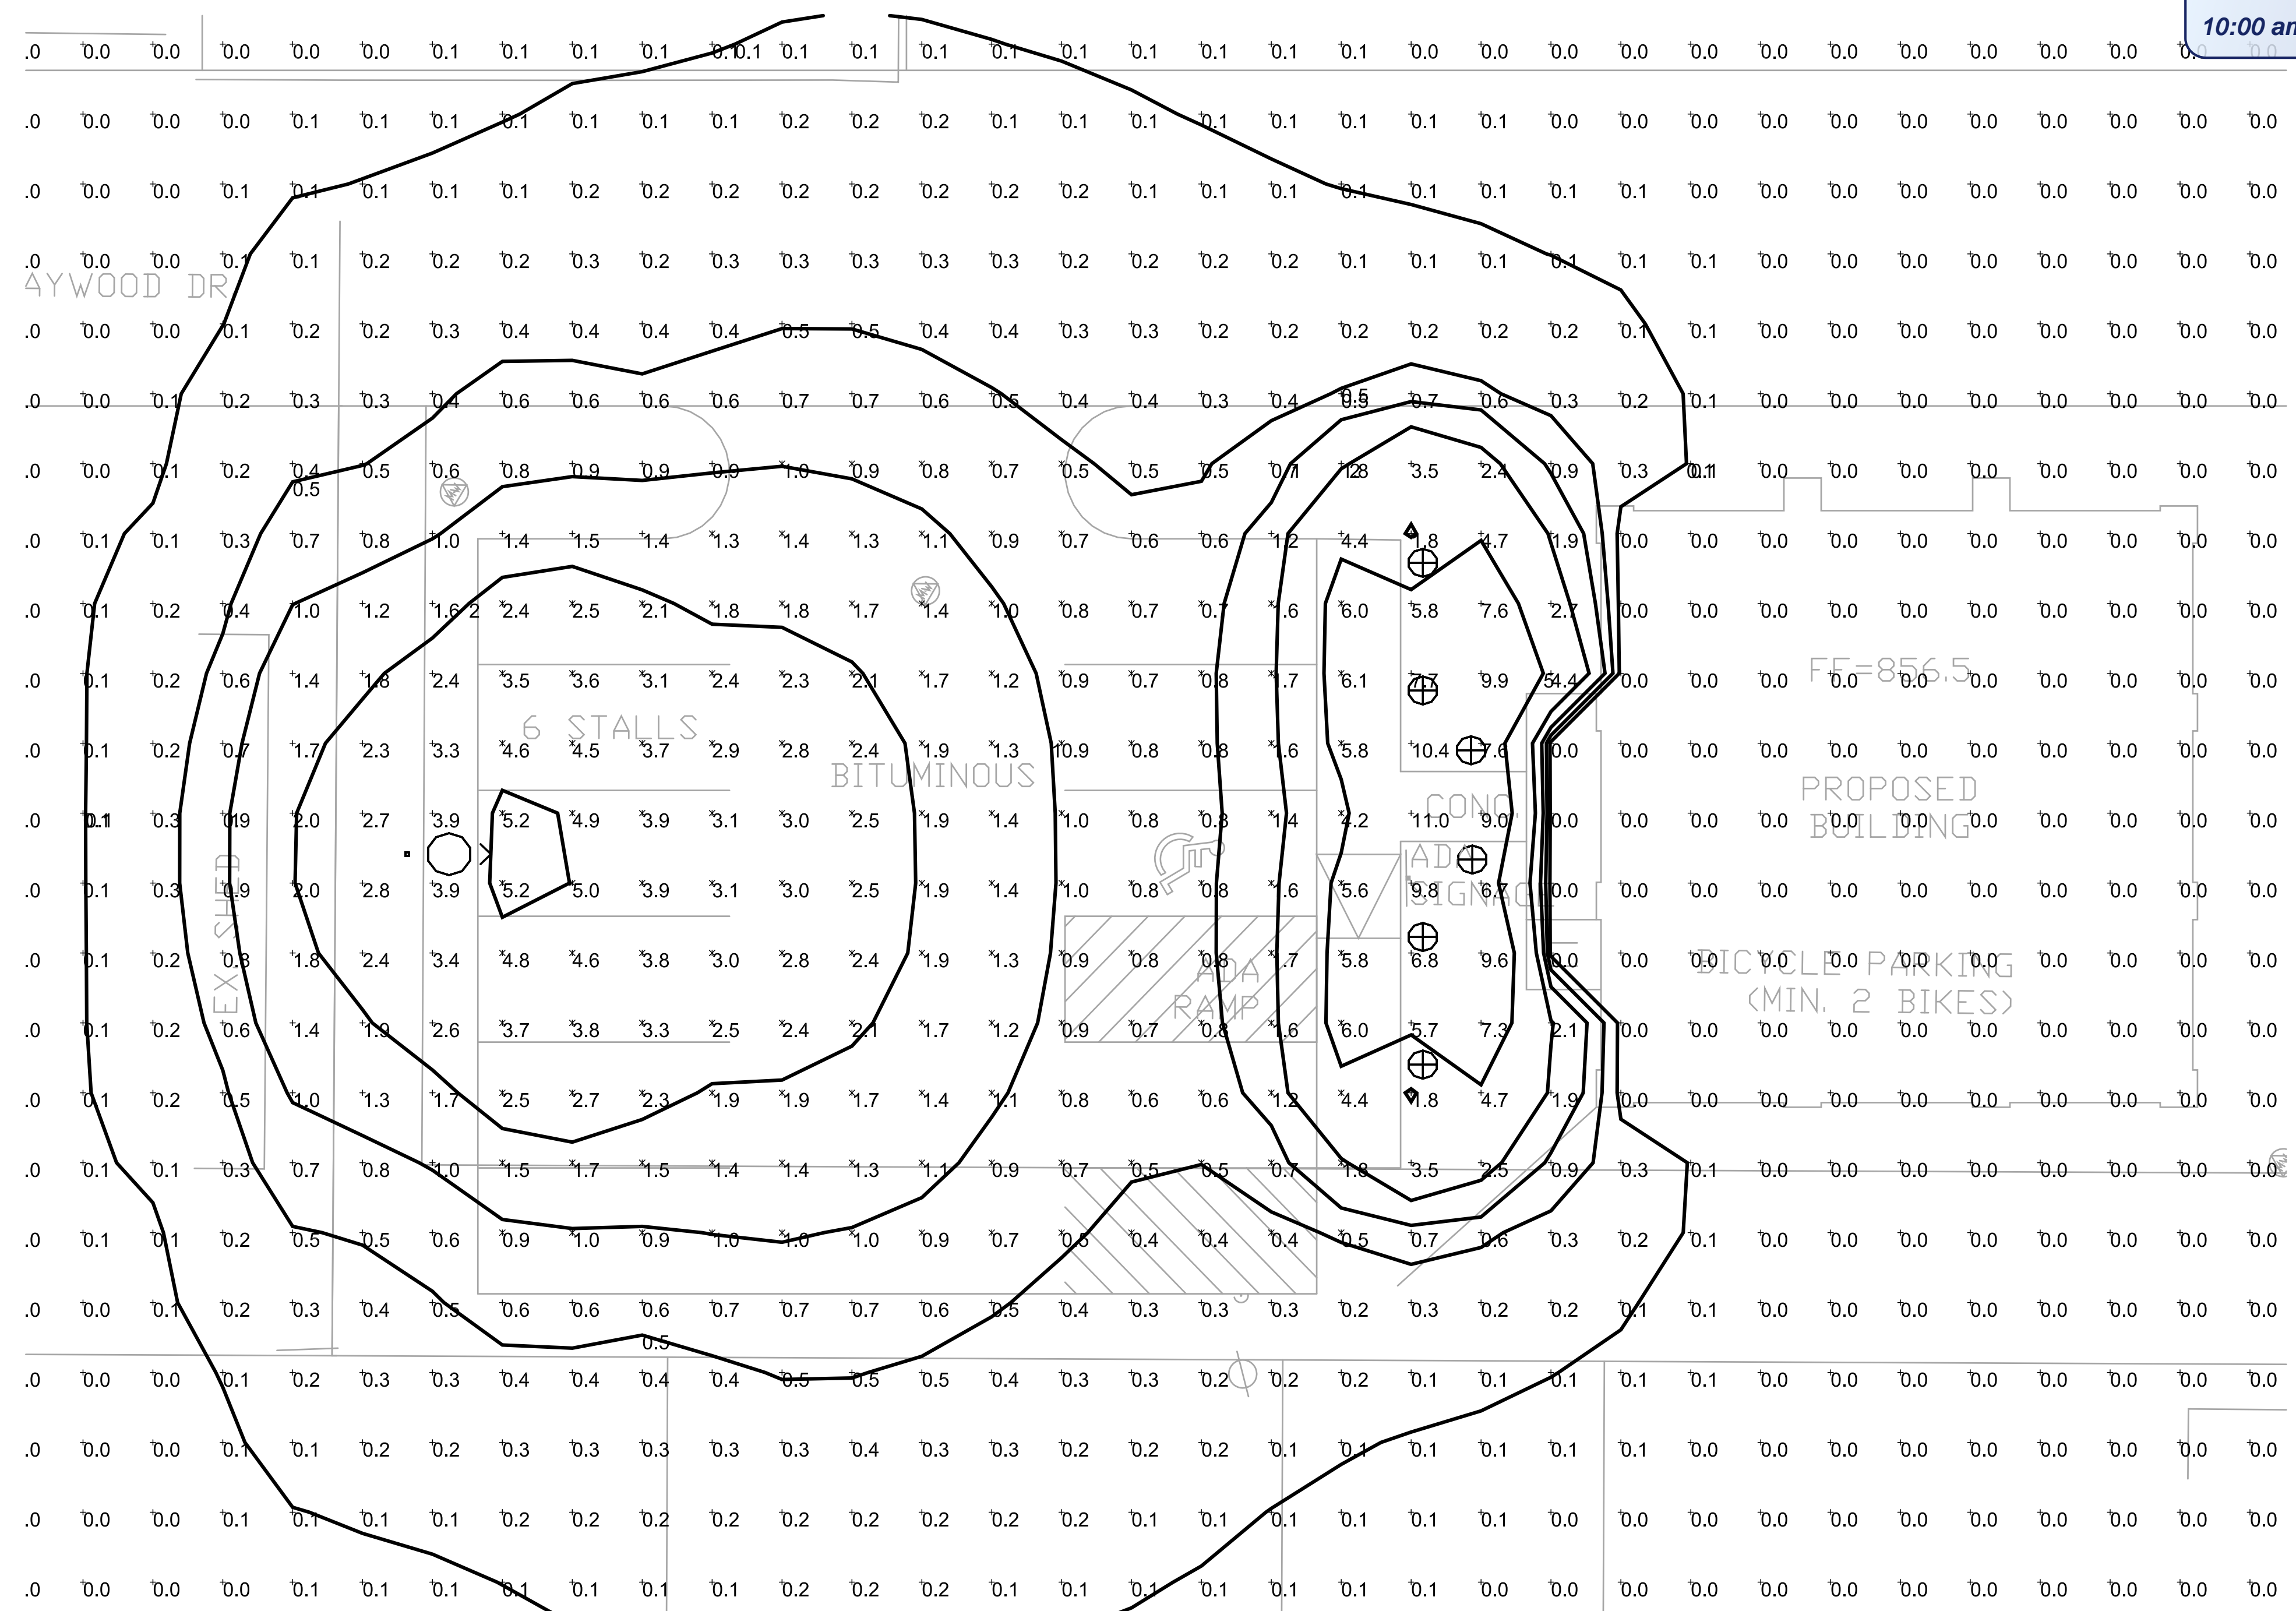

Flanders Electric Inc.
P.O. Box 160
Cottage Grove, WI

State/City
Lighting
Review

Ryan Brothers Ambulance
Office Annex
922 Park Street - Madison, WI

LUMINAIRE SCHEDULE									
Symbol	Label	Qty	Catalog Number	Description	Lamp	File	Lumens	LLF	Watts
	A	6	HC405	CLEAR ROUND BOLLARD	50 WATT MH	HC407.ies	4000	0.74	85
	D	1	MAC615	12" AREA CUTOFF / FORWARD THROW	150 WATT PSMH	MAC615.ies	15000	0.74	185

1 SITE PLAN - LIGHTING
ES.1 SCALE: 1/8"=1'-0"

STATISTICS						
Description	Symbol	Avg	Max	Min	Max/Min	Avg/Min
OVERALL SITE(Copy)	+	0.5 fc	11.0 fc	0.0 fc	N / A	N / A
PARKING & SIDEWALK	✕	2.0 fc	6.1 fc	0.4 fc	15.3:1	5.0:1

BEAR VALLEY ENGINEERING, INC.
COMMERCIAL BUILDING SPECIALISTS

Date
05-20-2013

Date	Revision

Drawing Name
SITE LIGHTING PLAN

Sheet No.
ES.1

PROJECT NUMBER
213040