



LUMINAIRE SCHEDULE									
Symbol	Label	Qty	Catalog Number	Lamp	File	Lumens	LLF	Watts	
●	E1	25	3020-LRTD4-9020-B1-35-30-NC	8 WHITE LEDS WITH CLEAR PLASTIC OPTICS BELOW EACH.	3020-LRTD4-9020-C1-30-30-NC.IES	Absolute	0.95	19.9	
—	E2	0	LOG-120V-48IN-40K-30X60	FORTY-EIGHT WHITE LIGHT EMITTING DIODES (LED'S), VERTICAL BASE -DOWN POSITION, VOLTAGE (120VAC, 60Hz) TO THE LED DRIVERS. LED DRIVER INFORMATION PROVIDED BY CLIENT.	LOG HO-120V-48IN-40K-30X60.IES	2176	0.95	62.8	
●	E3	5	6519LED		6519LED.IES	Absolute	0.95	43.87	
●	E5	14	7722MH	(1) 39W T4 G8.5 MH	7722MH.IES	3300	0.95	45	

STATISTICS						
Description	Symbol	Avg	Max	Min	Max/Min	Avg/Min
Calc Zone Building (Right)	◇	0.8 fc	50.6 fc	0.0 fc	N / A	N / A
Calc Zone Vertical (Right)	×	0.6 fc	33.3 fc	0.0 fc	N / A	N / A

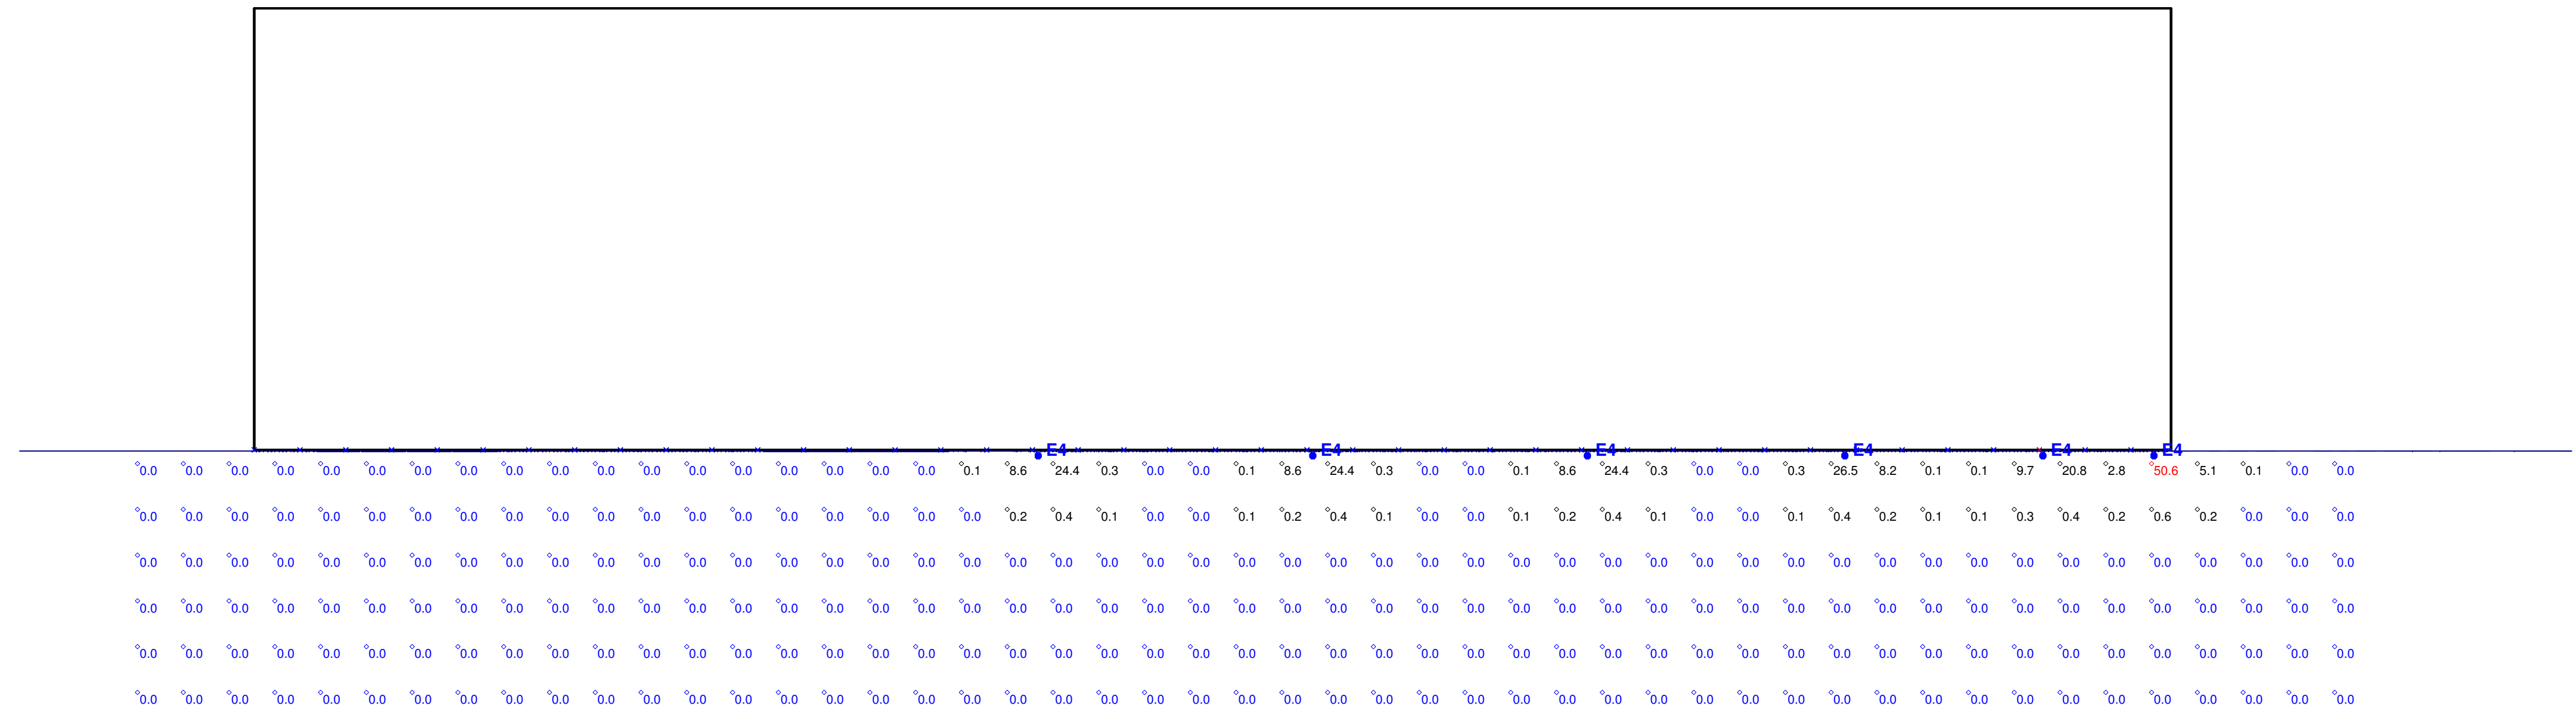

**Plan View**  
Scale 1" = 10'

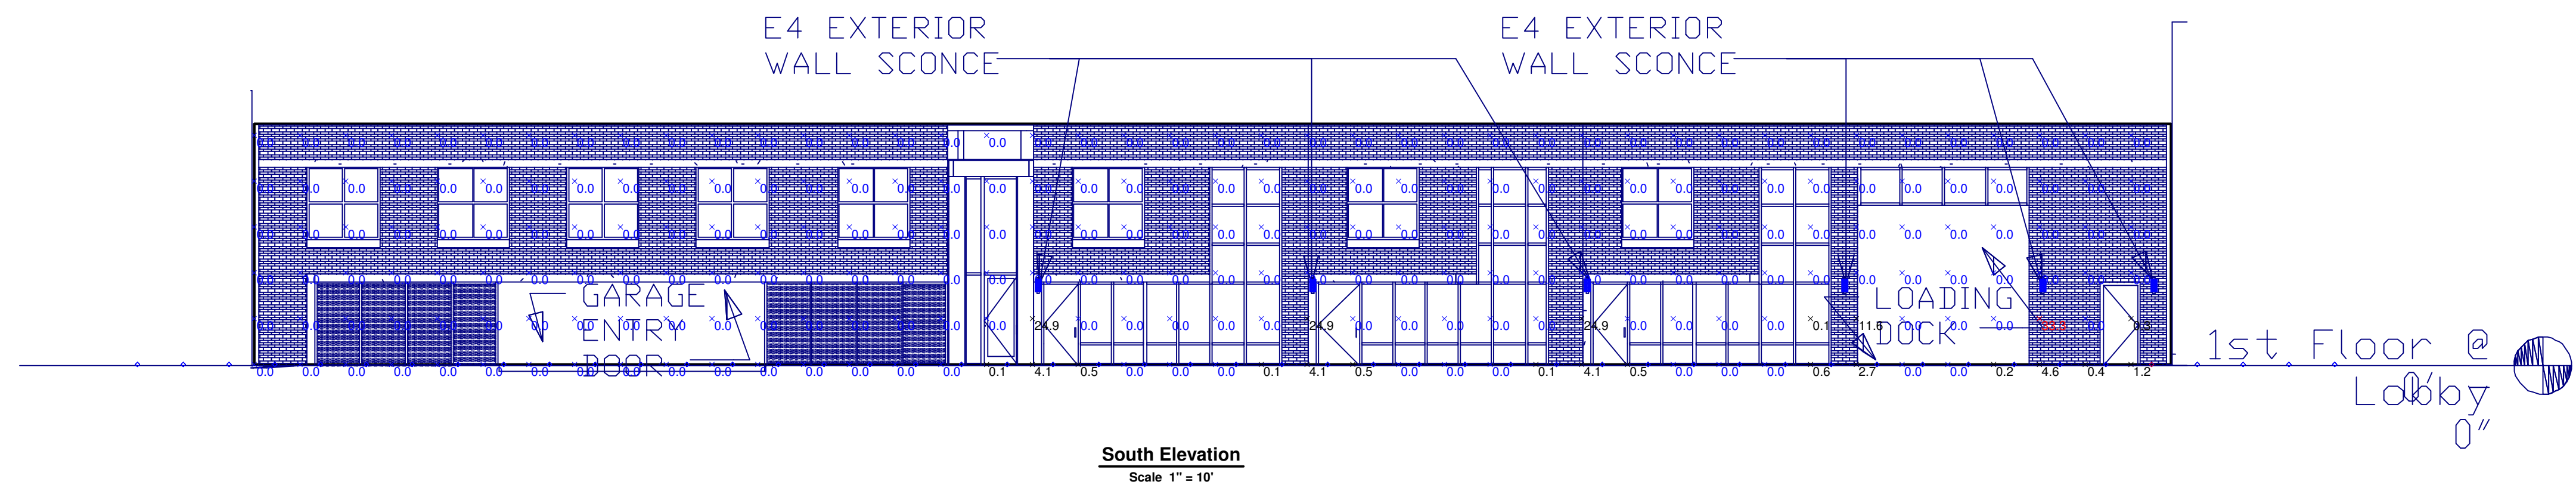

**South Elevation**  
Scale 1" = 10'