























 



 
 

 








LEGEND

-  EX. ELECTRICAL HAND HOLE
-  EX. ELECTRICAL PEDESTAL
-  EX. TELEPHONE PEDESTAL
-  EX. TREE
-  EX. WATER HYDRANT
-  EX. WATER VALVE
-  EX. PROPERTY LINE
-  EX. EASEMENT
-  EX. FENCE LINE
-  EX. TREE LINE
-  EX. CONTOUR (INDEX)
-  EX. CONTOUR (INTER)
-  EX. ABANDONED UTILITY
-  EX. ELECTRIC
-  EX. FIBER OPTIC
-  EX. NATURAL GAS
-  EX. OVERHEAD LINE
-  EX. SANITARY SEWER
-  EX. STORM SEWER
-  EX. CABLE TV
-  EX. UNDERGROUND TELEPHONE
-  EX. WATER LINE
-  EX. GRAVEL
-  EX. CONCRETE
-  REMOVE EX. TOPSOIL
-  PRO. SPOT ELEVATION
-  PRO. CONTOUR (INDEX)
-  PRO. CONTOUR (INTER)
-  PRO. FENCE
-  PRO. GRADING LIMITS
-  PRO. SILT SOCK
-  PRO. CONSTRUCTION FENCE
-  PRO. ASPHALT
-  PRO. CONSTRUCTION ENTRANCE
-  PRO. EXPANSION JOINT
-  PRO. INSTALL TENNIS NET
-  PRO. NET POST

 2024 RENNEBOHM PARK EAST TENNIS COURTS MUNIS NUMBER: 14015-51-130



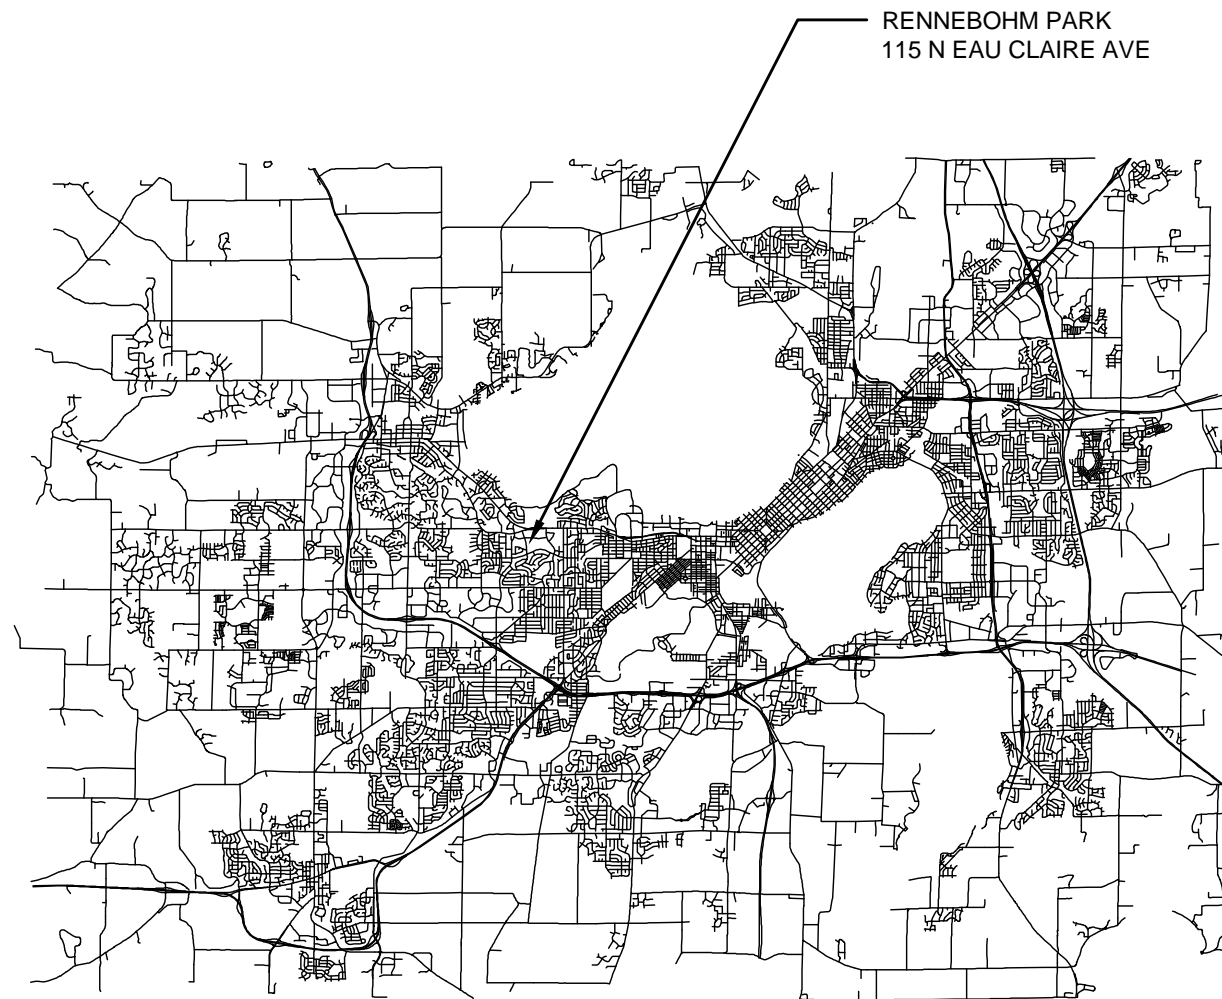DESIGNED BY:

City of Madison
Department of Public Works
PARKS DIVISION
330 E Lakeside St
Madison, WI 53715



SHEET SCHEDULE

RENNEBOHM PARK	
1.1	PROJECT LOCATION AND SITE ACCESS
1.2	EXISTING CONDITIONS PLAN
1.3	DEMOLITION AND PROTECTION PLAN
1.4	SITE PLAN
1.5	SITE LIGHTING PLAN - TBD
1.6	GRADING AND EROSION CONTROL PLAN
1.7	DESIGN COMPUTATIONS
1.8	ASPHALT COURT PAVEMENT DETAIL
1.9	FENCING AND GATE DETAILS
1.10	COURT STRIPING DETAILS
1.11	NET POST AND CENTER NET TIE-DOWN DETAILS

PROJECT:

*2024 RENNEBOHM PARK
EAST TENNIS COURTS*

Although every effort has been made in preparing these plans and checking them for accuracy, the contractor and subcontractors must check all details and dimensions of their trade and be responsible for the same.

ITEM	DATE
BPW: KK	2024-01-24

PUBLIC WORKS PROJECT #:
9500

SHEET TITLE:
COVER SHEET

SHEET NUMBER:

NOTES

1.) THE CONTRACTOR IS RESPONSIBLE FOR REPAIRING ANY EXISTING UTILITIES, STRUCTURES, SIDEWALK, CURB, LAWN, PAVEMENT, ETC. DAMAGED THROUGH CONSTRUCTION ACTIVITIES AT THEIR OWN EXPENSE. REPAIRS MUST BE MADE IN ACCORDANCE WITH THE CITY OF MADISON STANDARD SPECIFICATIONS FOR PUBLIC WORKS CONSTRUCTION.

PROPOSED CONSTRUCTION FENCE:
NO CONSTRUCTION OUTSIDE OF FENCE LIMITS

DEMOLITION OF EAST SET OF (3) TENNIS COURTS
BY PARKS CONSTRUCTION STAFF PRIOR TO
START OF 9500 CONTRACT

EXISTING TENNIS COURTS (TO REMAIN)

CONSTRUCTION ACCESS FROM
N EAU CLAIRE AVE. NOTE: GATED
ACCESS DRIVE TO BE USED FOR
CONSTRUCTION ACTIVITIES -
ACCESS TO BE PROVIDED TO
CONTRACTOR DURING
CONSTRUCTION

 
PROPOSED STAGING
AREA WITHIN
CONSTRUCTION
FENCE LIMITS

RENNEBOHM PARK

N EAU CLAIRE AVE

City of Madison
Department of Public Works
PARKS DIVISION
City-County Building, Suite 104
210 Martin Luther King, Jr. Blvd.
Madison, WI 53703

play
**MADISON
PARKS**



PROJECT:
**2024 RENNEBOHM PARK
EAST TENNIS COURTS**


PROJECT ADDRESS:
**RENNEBOHM PARK
115 N EAU CLAIRE AVE
MADISON, WI 53705**

Although every effort has been made in preparing these plans and checking them for accuracy, the contractor and subcontractors must check all details and dimensions of their trade and be responsible for the same.

ITEM	DATE
REVISED BY: K KANE	
DRAWN BY: K KANE	2024-01-05
STORMWATER MANAGEMENT DESIGNED BY: C. STELLIES	


**PROJECT LOCATION
AND SITE ACCESS**

SHEET NUMBER:
1.1

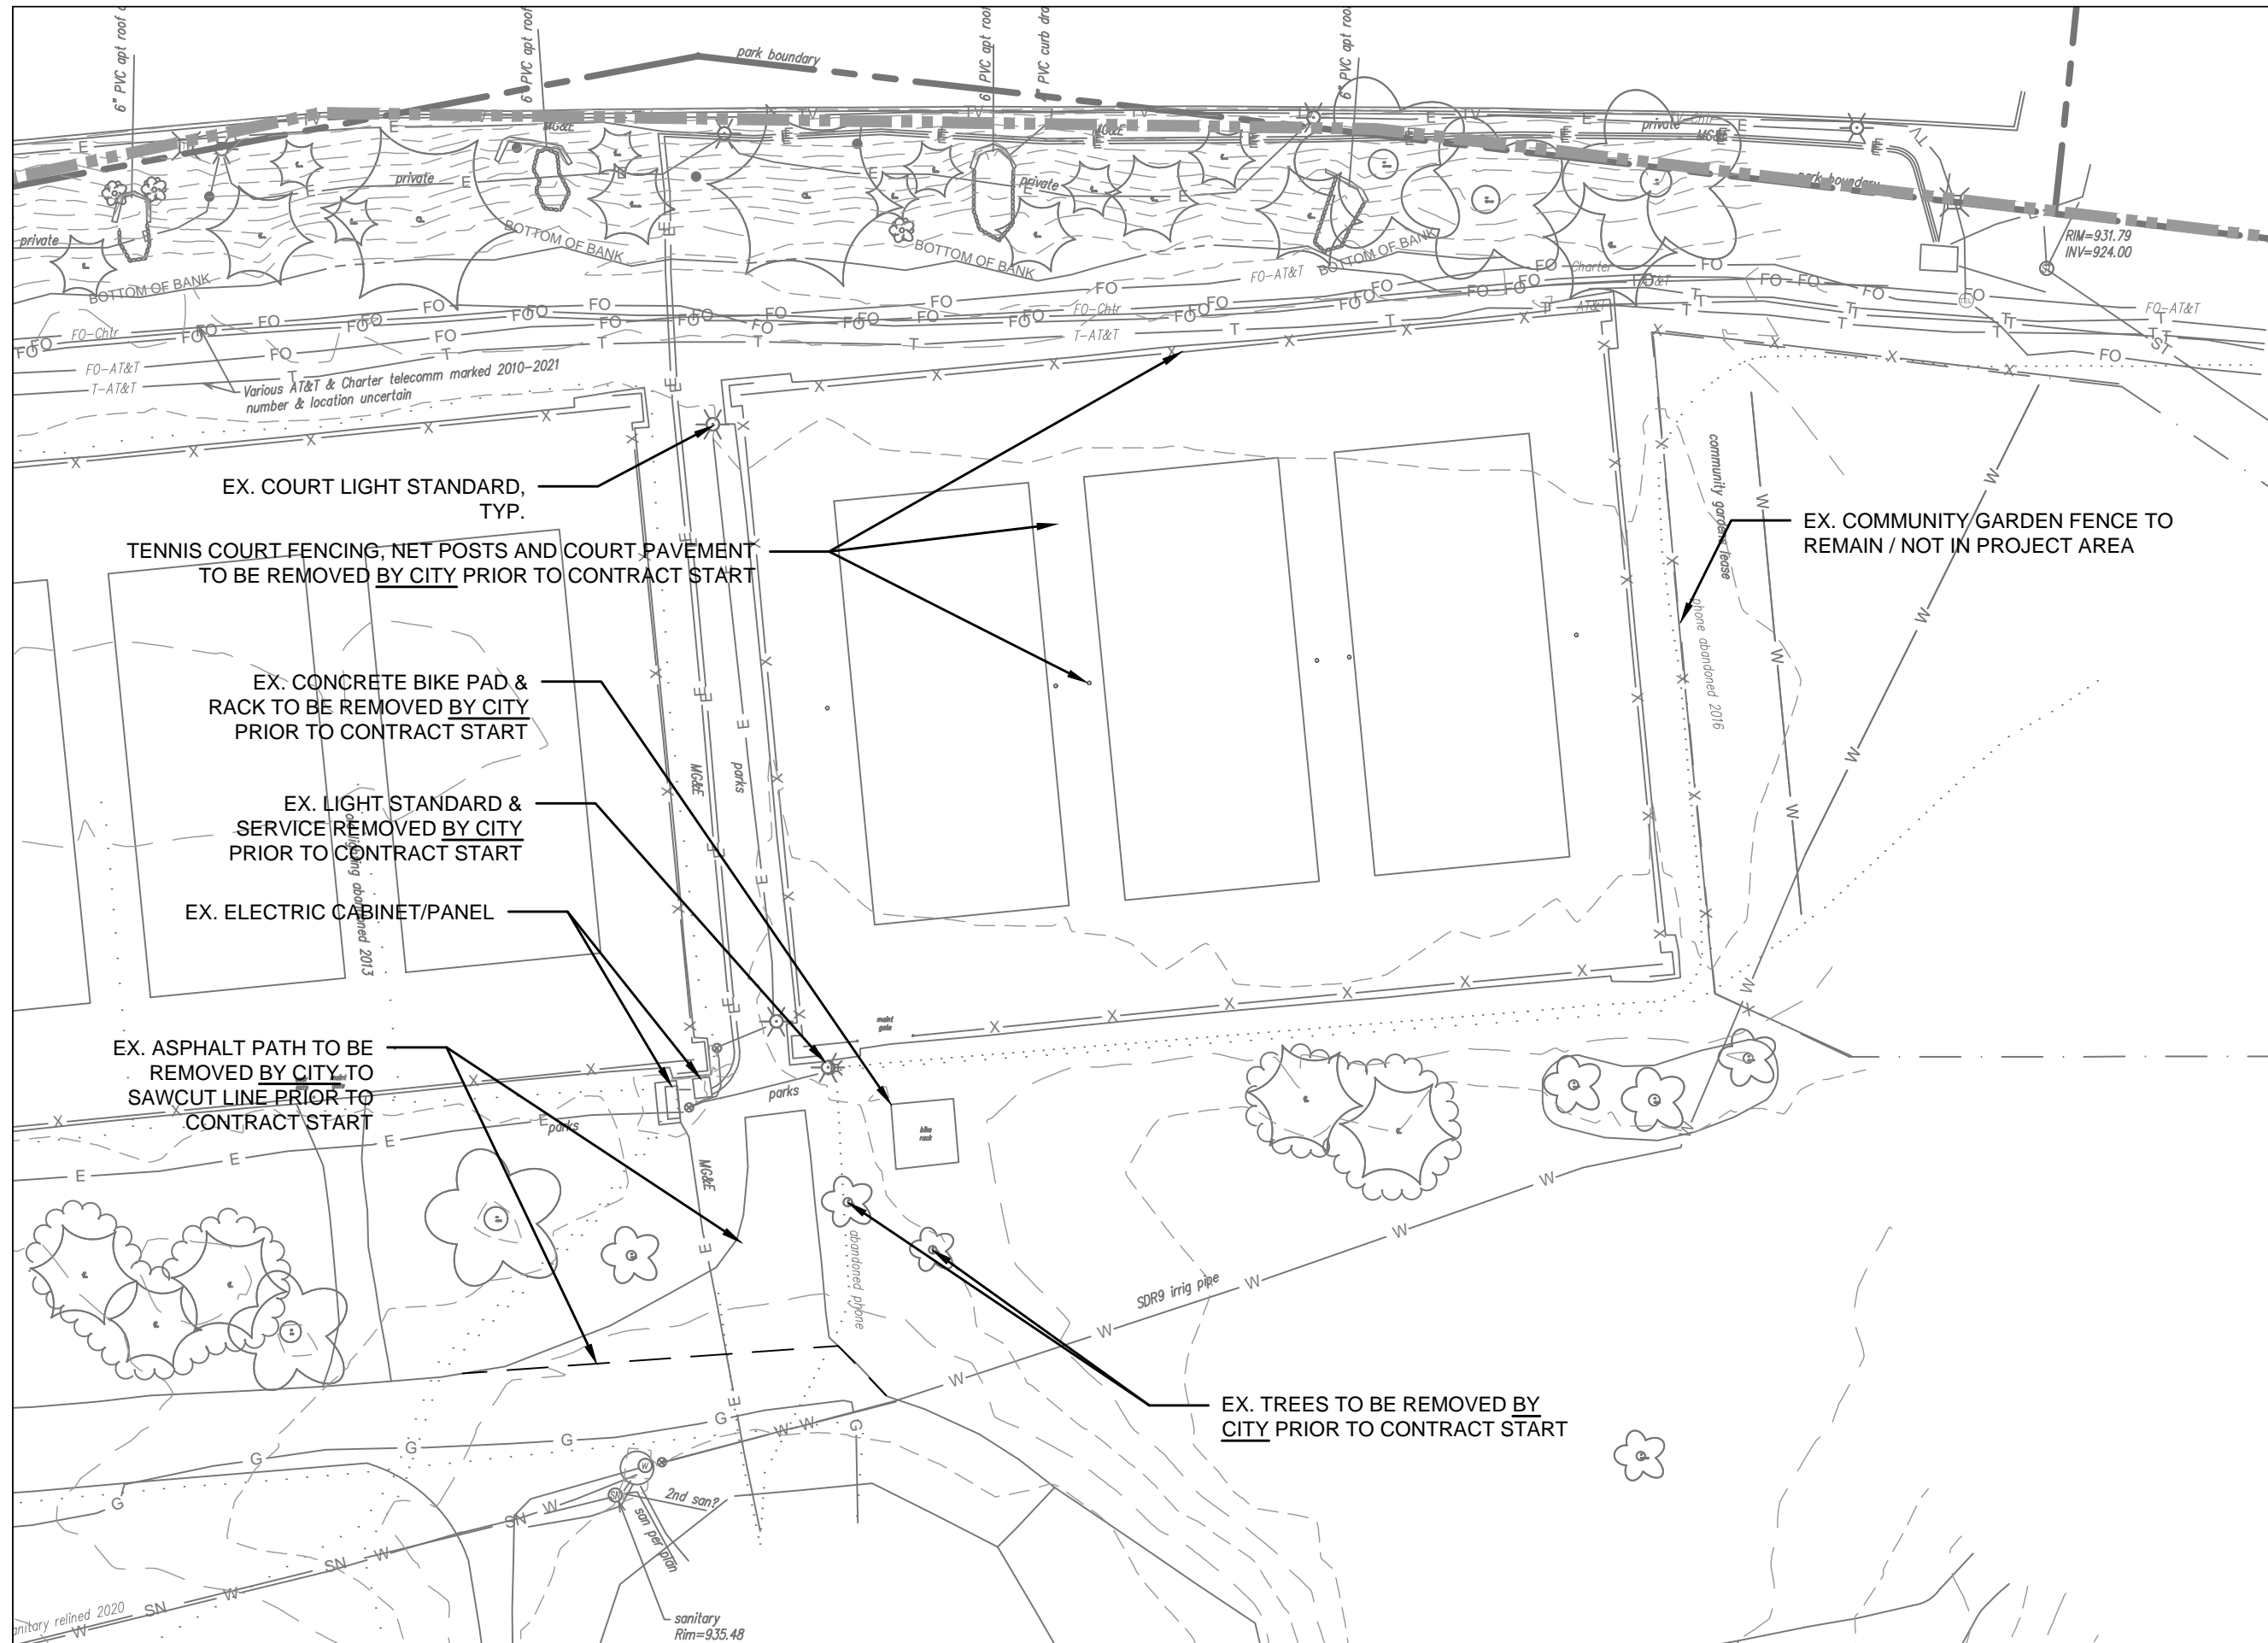

City of Madison
 Department of Public Works
PARKS DIVISION
 City-County Building, Suite 104
 210 Martin Luther King, Jr. Blvd.
 Madison, WI 53703

 play
MADISON
PARKS



PROJECT:
**2024 RENNEBOHM PARK
 EAST TENNIS COURTS**


PROJECT ADDRESS:
**RENNEBOHM PARK
 115 N EAU CLAIRE AVE
 MADISON, WI 53705**

Although every effort has been made in preparing these plans and checking them for accuracy, the contractor and subcontractors must check all details and dimensions of their trade and be responsible for the same.


ITEM	DATE
REVISED BY: K KANE	
DRAWN BY: K KANE	2024-01-05
STORMWATER MANAGEMENT DESIGNED BY: C. STELLIES	

**EXISTING
 CONDITIONS**

SHEET NUMBER:
1.2

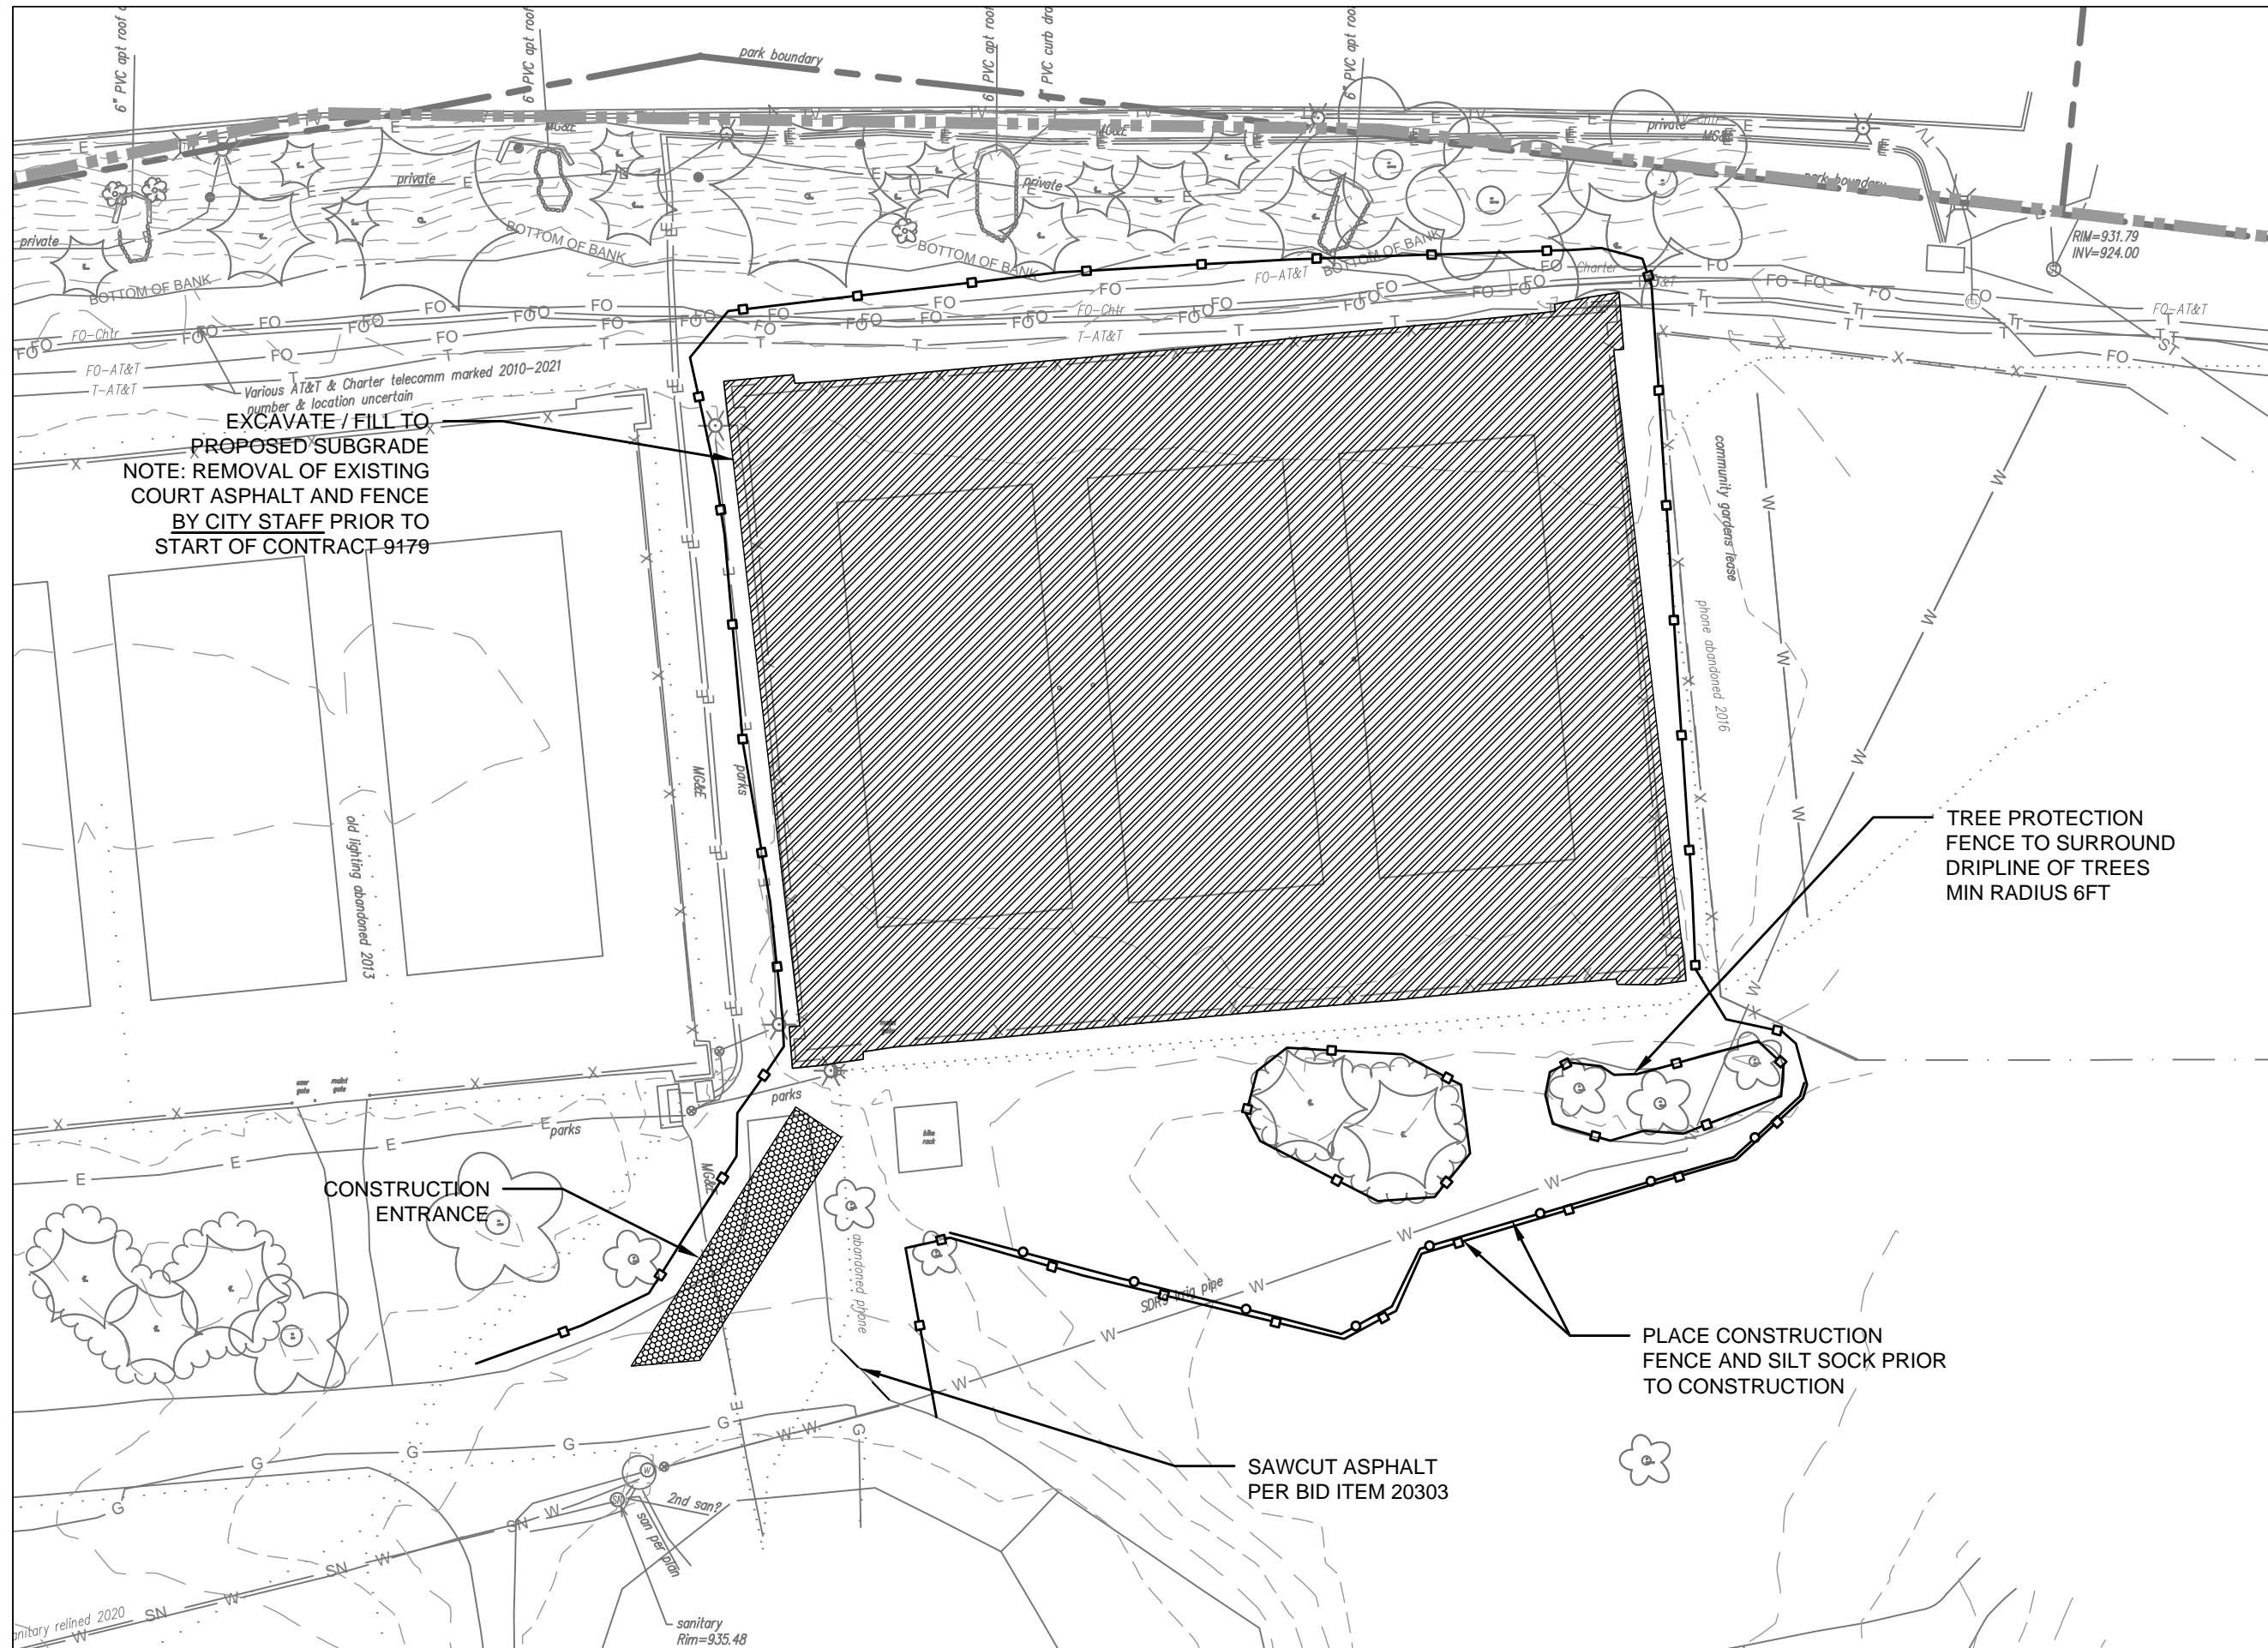

 City of Madison
 Department of Public Works
PARKS DIVISION
 City-County Building, Suite 104
 210 Martin Luther King, Jr. Blvd.
 Madison, WI 53703



PROJECT:
**2024 RENNEBOHM PARK
 EAST TENNIS COURTS**


PROJECT ADDRESS:
**RENNEBOHM PARK
 115 N EAU CLAIRE AVE
 MADISON, WI 53705**

Although every effort has been made in preparing these plans and checking them for accuracy, the contractor and subcontractors must check all details and dimensions of their trade and be responsible for the same.

ITEM	DATE
REVISED BY: K KANE	
DRAWN BY: K KANE	2024-01-05
STORMWATER MANAGEMENT DESIGNED BY: C. STELLIES	

**DEMOLITION AND
 PROTECTION PLAN**

SHEET NUMBER:
1.3

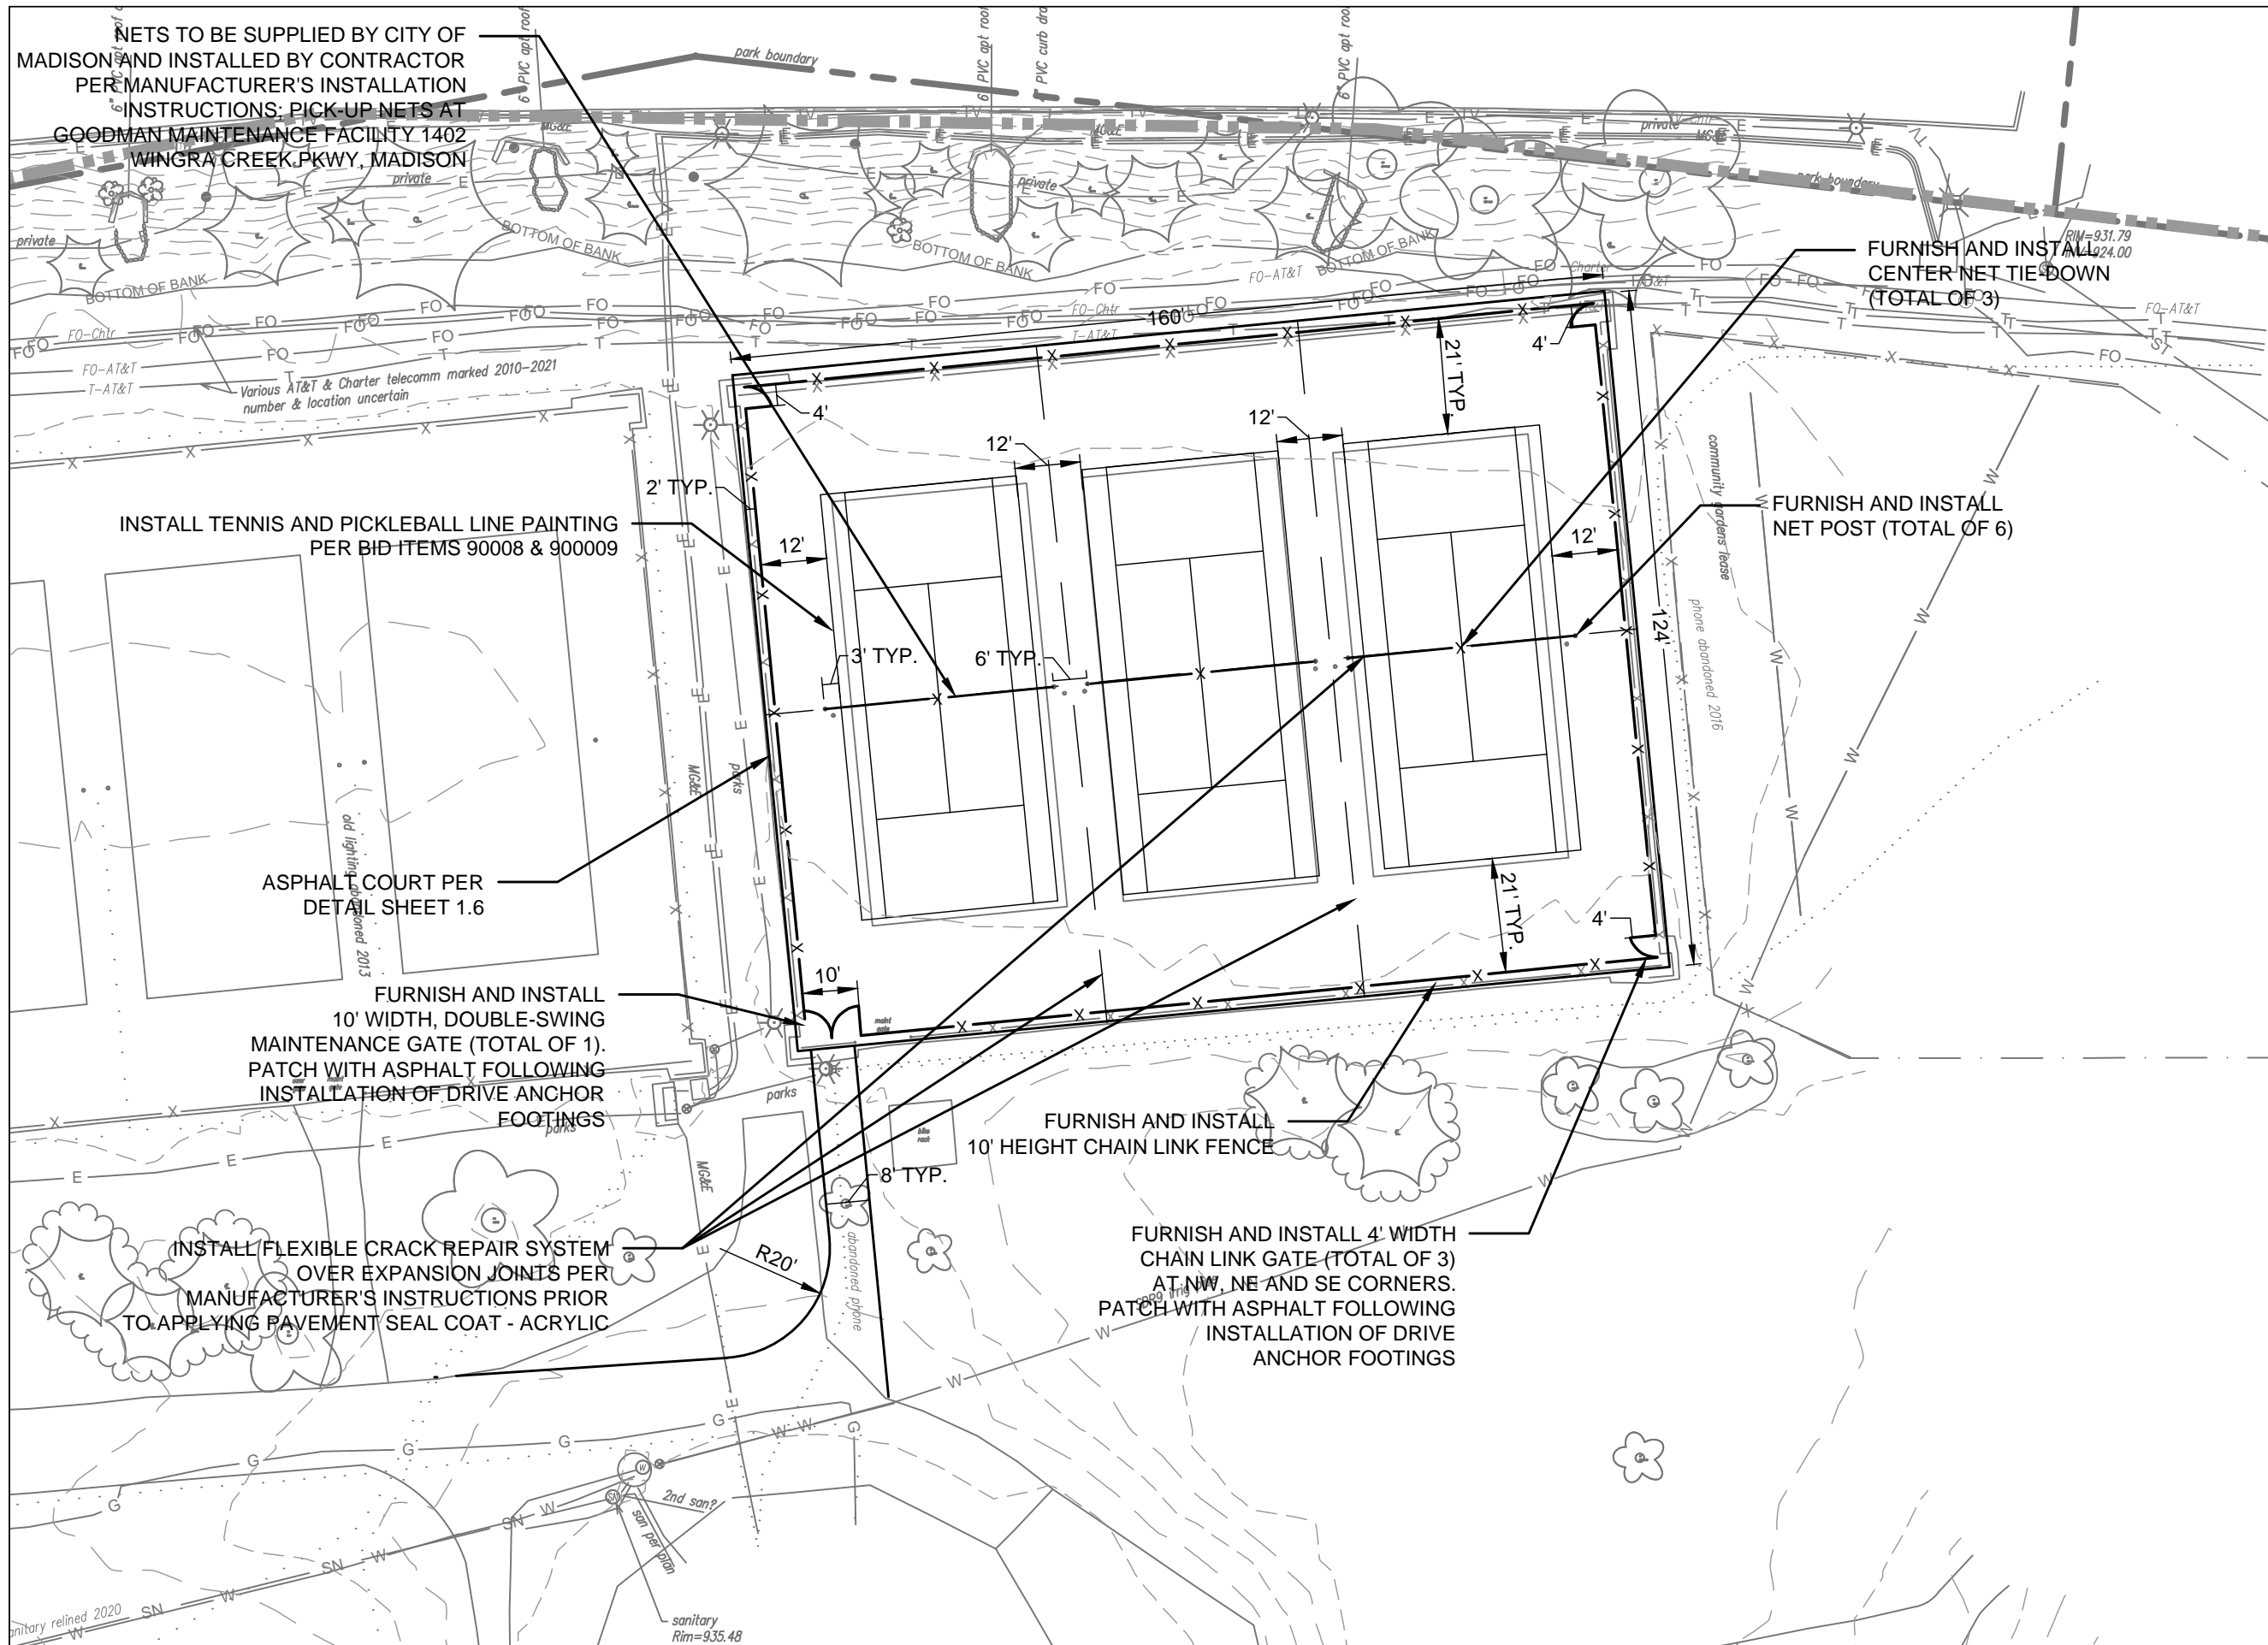

NETS TO BE SUPPLIED BY CITY OF MADISON AND INSTALLED BY CONTRACTOR PER MANUFACTURER'S INSTALLATION INSTRUCTIONS. PICK-UP NETS AT GOODMAN MAINTENANCE FACILITY 1402 WINGRA CREEK PKWY, MADISON

FURNISH AND INSTALL CENTER NET TIE-DOWN (TOTAL OF 3)

INSTALL TENNIS AND PICKLEBALL LINE PAINTING PER BID ITEMS 90008 & 90009

FURNISH AND INSTALL NET POST (TOTAL OF 6)

ASPHALT COURT PER DETAIL SHEET 1.6

FURNISH AND INSTALL 10' WIDTH, DOUBLE-SWING MAINTENANCE GATE (TOTAL OF 1). PATCH WITH ASPHALT FOLLOWING INSTALLATION OF DRIVE ANCHOR FOOTINGS

FURNISH AND INSTALL 10' HEIGHT CHAIN LINK FENCE

INSTALL FLEXIBLE CRACK REPAIR SYSTEM OVER EXPANSION JOINTS PER MANUFACTURER'S INSTRUCTIONS PRIOR TO APPLYING PAVEMENT SEAL COAT - ACRYLIC

FURNISH AND INSTALL 4' WIDTH CHAIN LINK GATE (TOTAL OF 3) AT NW, NE AND SE CORNERS. PATCH WITH ASPHALT FOLLOWING INSTALLATION OF DRIVE ANCHOR FOOTINGS

City of Madison
 Department of Public Works
PARKS DIVISION
 City-County Building, Suite 104
 210 Martin Luther King, Jr. Blvd.
 Madison, WI 53703

play
MADISON
PARKS

Graphical Scale

0 30



PROJECT:

**2024 RENNEBOHM PARK
 EAST TENNIS COURTS**

PROJECT ADDRESS:

**RENNEBOHM PARK
 115 N EAU CLAIRE AVE
 MADISON, WI 53705**

Although every effort has been made in preparing these plans and checking them for accuracy, the contractor and subcontractors must check all details and dimensions of their trade and be responsible for the same.

ITEM DATE

REVISED BY: K KANE	
DRAWN BY: K KANE	2024-01-05
STORMWATER MANAGEMENT DESIGNED BY: C. STELLIES	


SITE PLAN

SHEET NUMBER:


1.4

NOTES

- 1.) CONSTRUCT BIO RETENTION BASIN PER GRADING PLAN AND S.D.D. 2.09 OF THE CITY OF MADISON STANDARD SPECS
- 2.) NO CONCRETE FLUME TO BE INSTALLED WITH BIOBASIN - SITE SHALL BE GRADED TO ALLOW WATER FROM COURTS AND DISTURBED AREA TO DRAIN TO BASIN
- 3.) MULCH AND PLANTING BY PARKS STAFF
- 4.) ALL DISTURBED AREAS SHALL RECEIVE CLASS I, URBAN TYPE A EROSION CONTROL MATTING

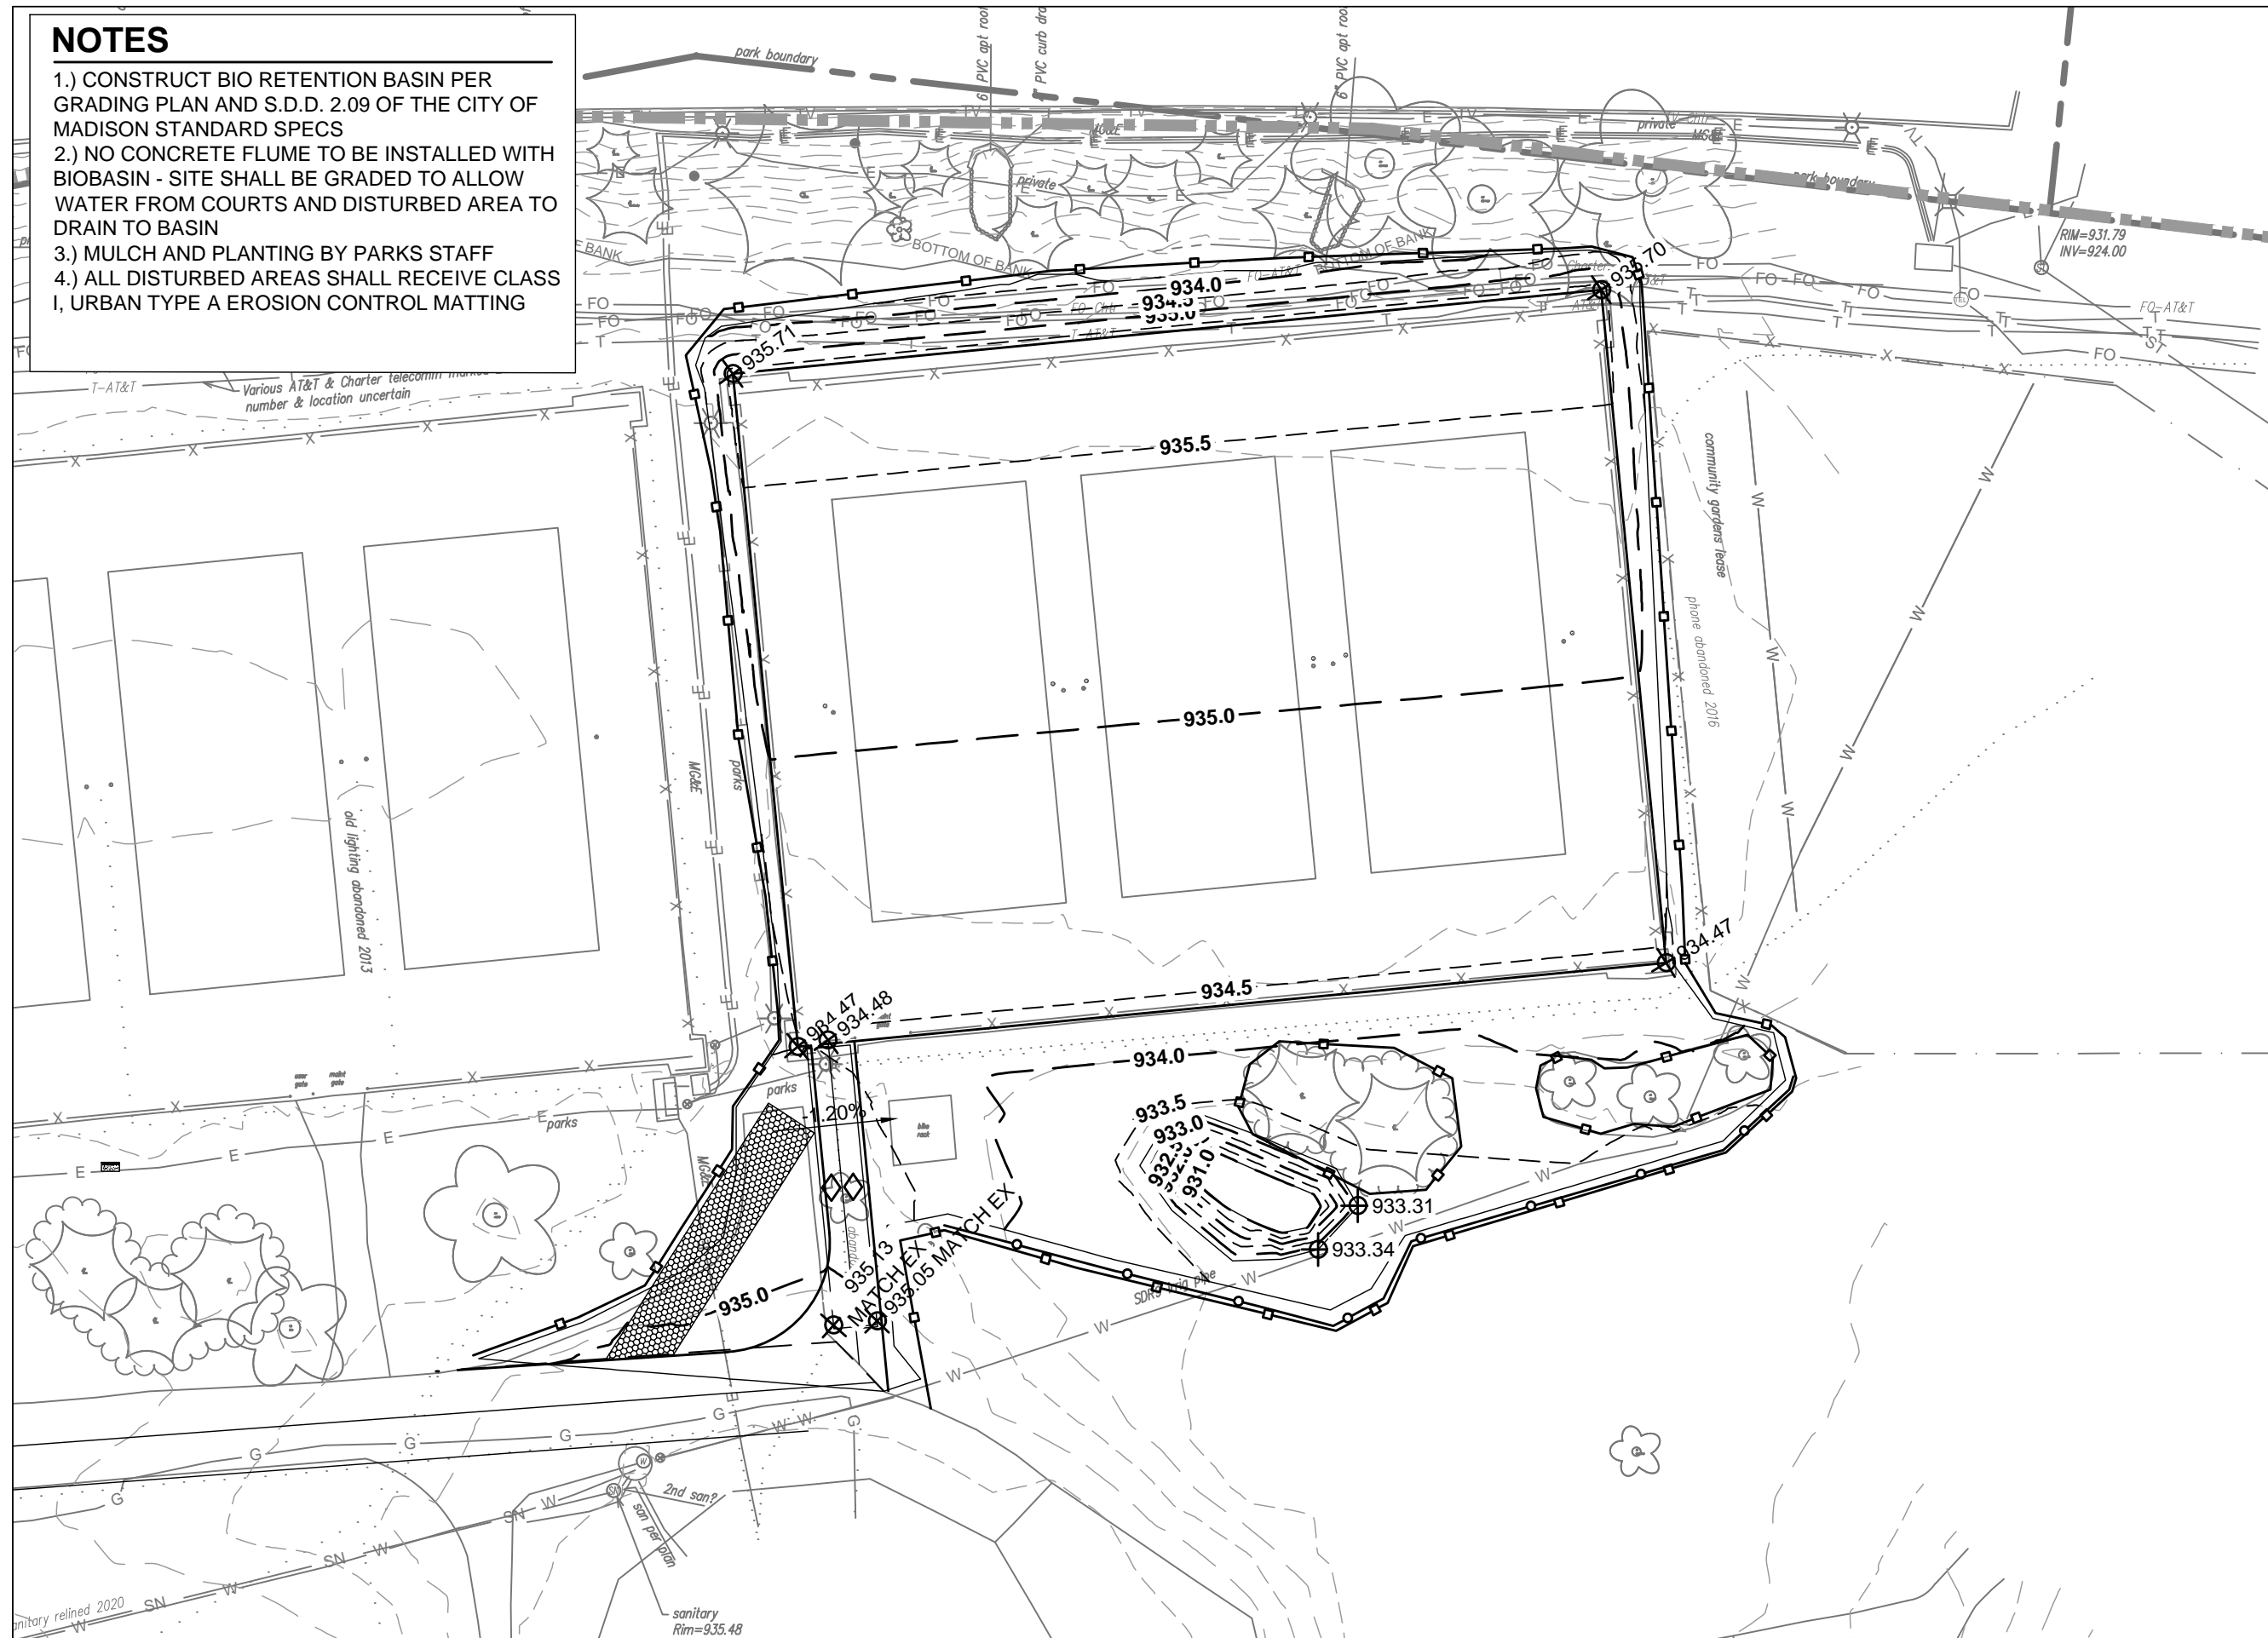

 City of Madison
 Department of Public Works
PARKS DIVISION
 City-County Building, Suite 104
 210 Martin Luther King, Jr. Blvd.
 Madison, WI 53703



PROJECT:
**2024 RENNEBOHM PARK
 EAST TENNIS COURTS**

PROJECT ADDRESS:
**RENNEBOHM PARK
 115 N EAU CLAIRE AVE
 MADISON, WI 53705**


Although every effort has been made in preparing these plans and checking them for accuracy, the contractor and subcontractors must check all details and dimensions of their trade and be responsible for the same.

ITEM	DATE
REVISED BY: K KANE	
DRAWN BY: K KANE	2024-01-05
STORMWATER MANAGEMENT DESIGNED BY: C. STELLIES	

**GRADING AND
 EROSION CONTROL
 PLAN**

SHEET NUMBER:
1.6

 City of Madison
 Department of Public Works
PARKS DIVISION
 City-County Building, Suite 104
 210 Martin Luther King, Jr. Blvd.
 Madison, WI 53703



PROJECT:
**2024 RENNEBOHM PARK
 EAST TENNIS COURTS**


PROJECT ADDRESS:
**RENNEBOHM PARK
 115 N EAU CLAIRE AVE
 MADISON, WI 53705**

Although every effort has been made in preparing these plans and checking them for accuracy, the contractor and subcontractors must check all details and dimensions of their trade and be responsible for the same.

ITEM	DATE
REVISED BY: K KANE	
DRAWN BY: K KANE	2024-01-05
STORMWATER MANAGEMENT DESIGNED BY: C. STELLIES	

**ASPHALT COURT
 PAVEMENT DETAIL**

SHEET NUMBER:
1.7

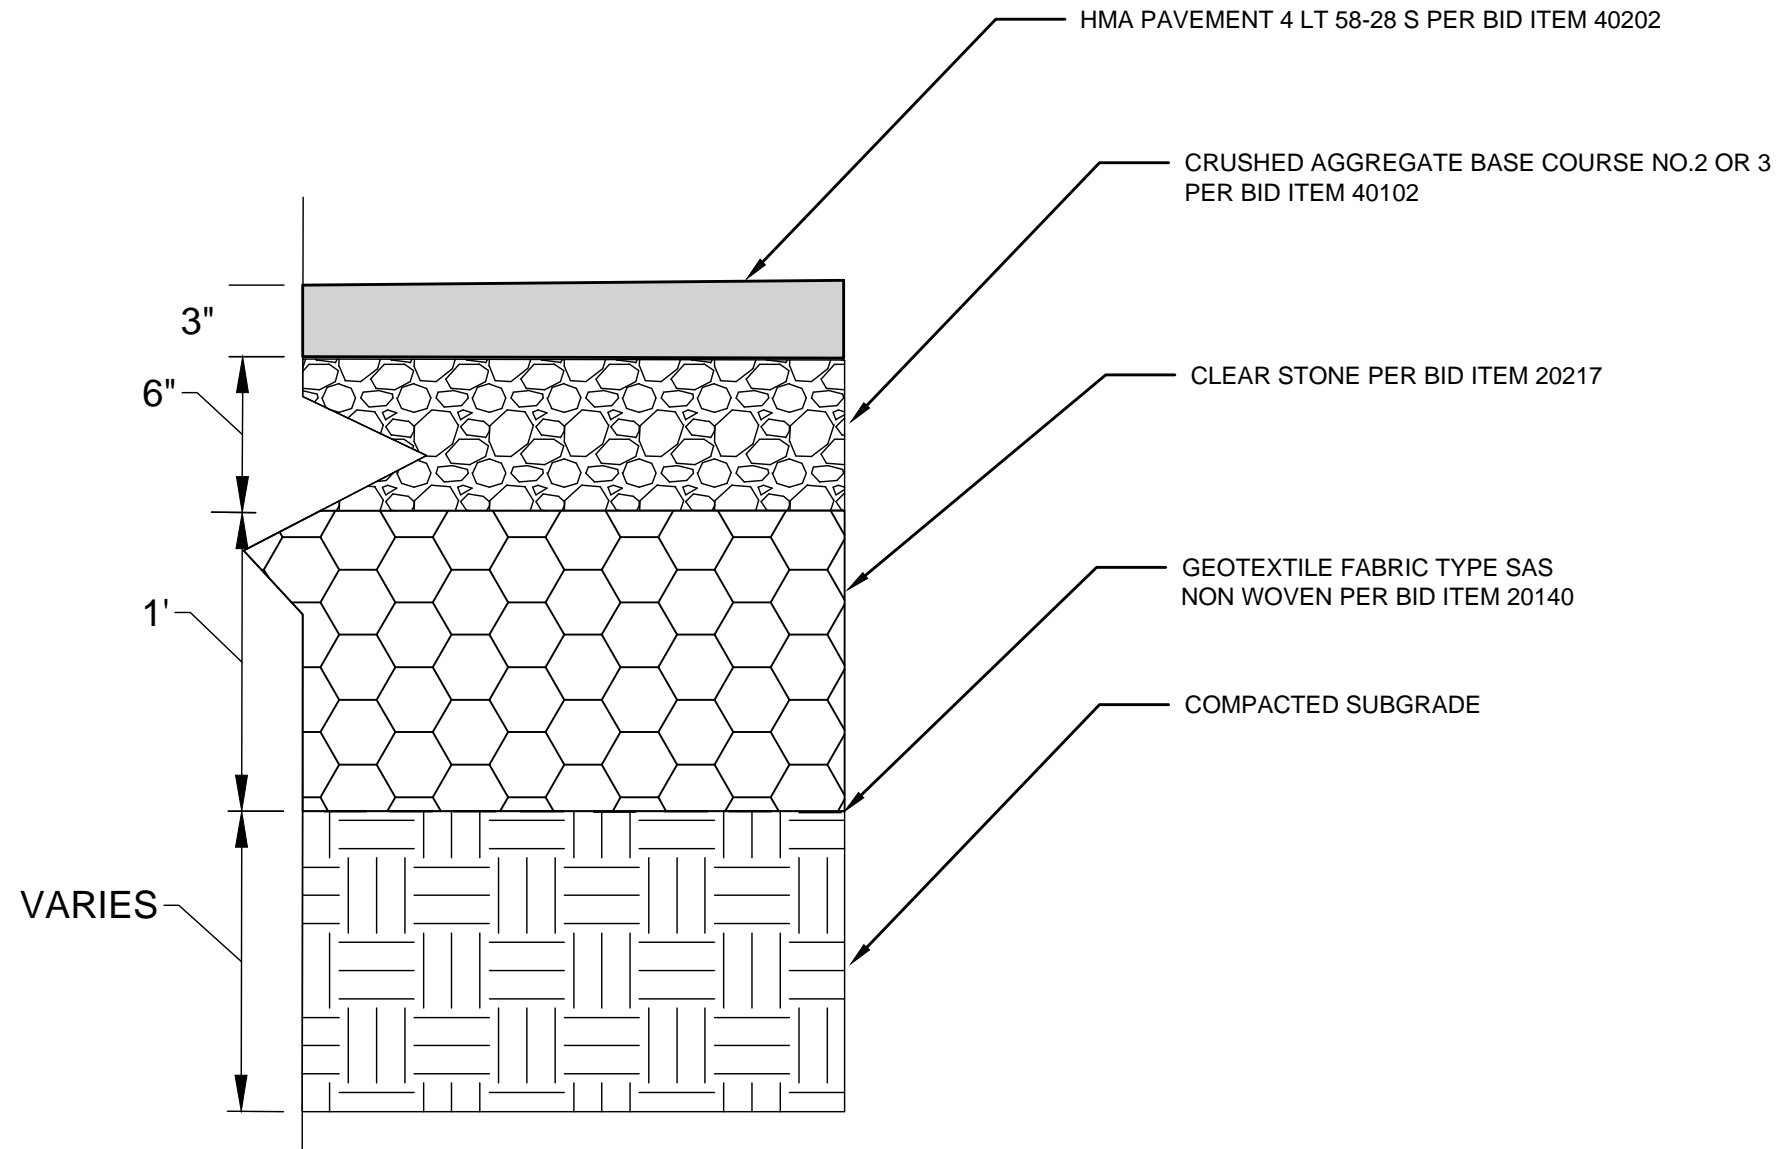


1 ASPHALT TENNIS COURT
 NTS

NOTES


1) FABRIC, FRAME WORK AND FITTINGS FOR CHAIN LINK FENCE PER DETAILS SHOWN ON THIS SHEET AND IN SPECIFICATIONS SECTIONS 90002-90004.

2) END/CORNER POSTS SHALL BE 3" O.D. SCHEDULE 40 WATER PIPE, GALVANIZED; LINE POSTS SHALL BE 3" O.D. SCHEDULE 40 WATER PIPE; RAILS SHALL BE 1 5/8" O.D. SCHEDULE 40 WATER PIPE, GALVANIZED; DRIVE ANCHORS SHALL BE 2" GALVANIZED SCHEDULE 40 WATER PIPE; FABRIC SHALL BE 1 3/4", 11-GAUGE MESH, ALUMINIZED.

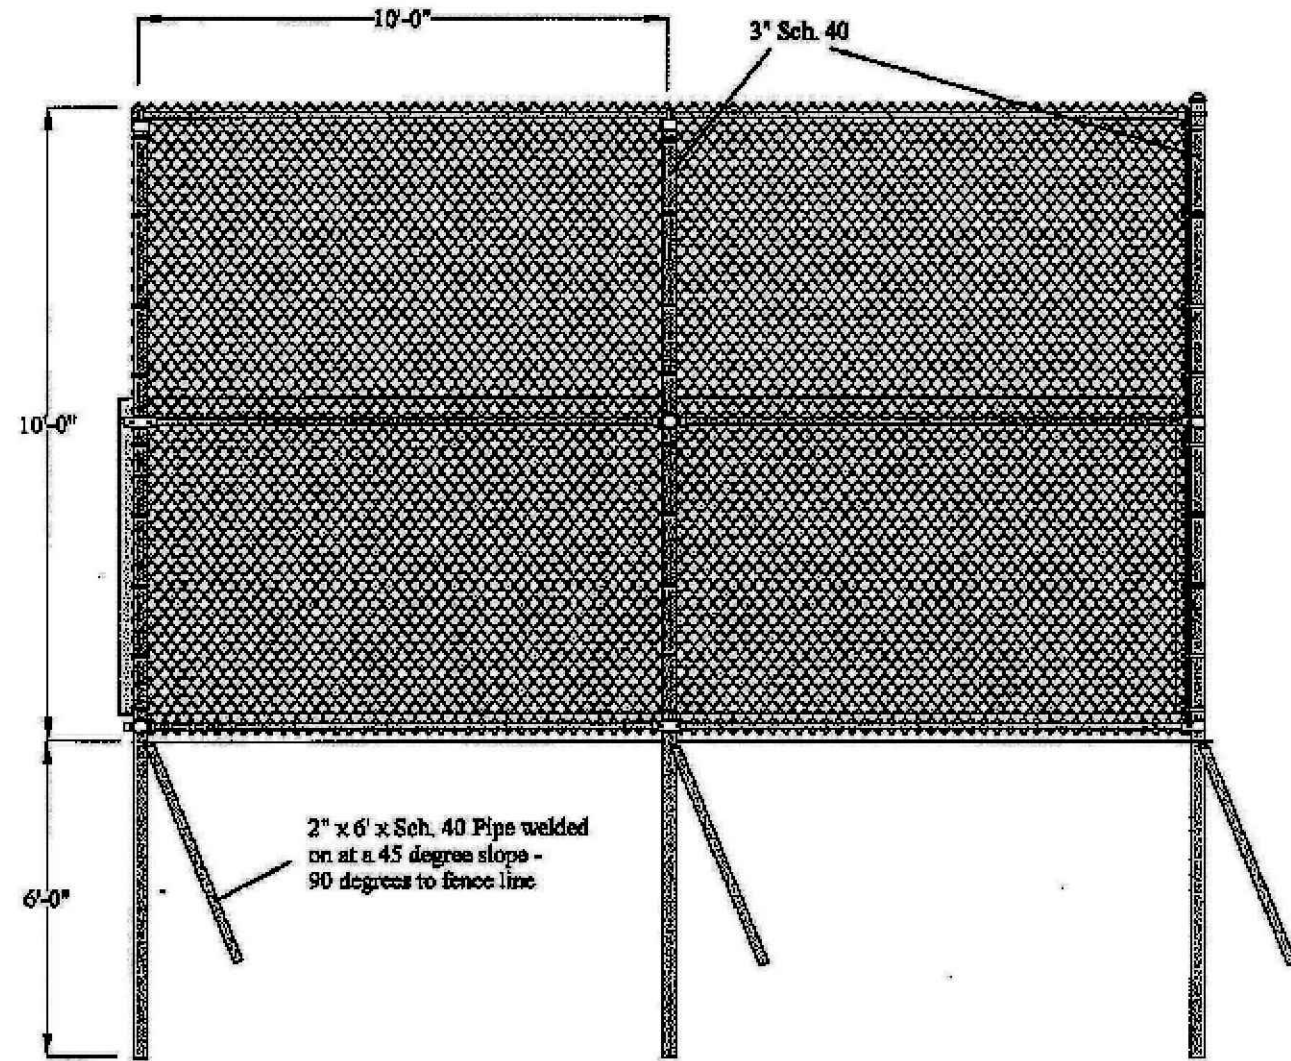


FABRIC	Height		Mesh	Gage	Selvage	Finish	TYPE
	10'	1 3/4"					
FRAMEWORK:	O.D.	WALL	WT PER FT	LENGTH			Schedule 40
END/CORNER POST:	3"	.203	5.79	18'			Schedule 40
LINE POST:		3"	.203	5.79	18'		Schedule 40
RAILS:		1 5/8"	.140	2.27	10' TYP.		Schedule 40

1 10' CHAIN LINK FENCE
NTS

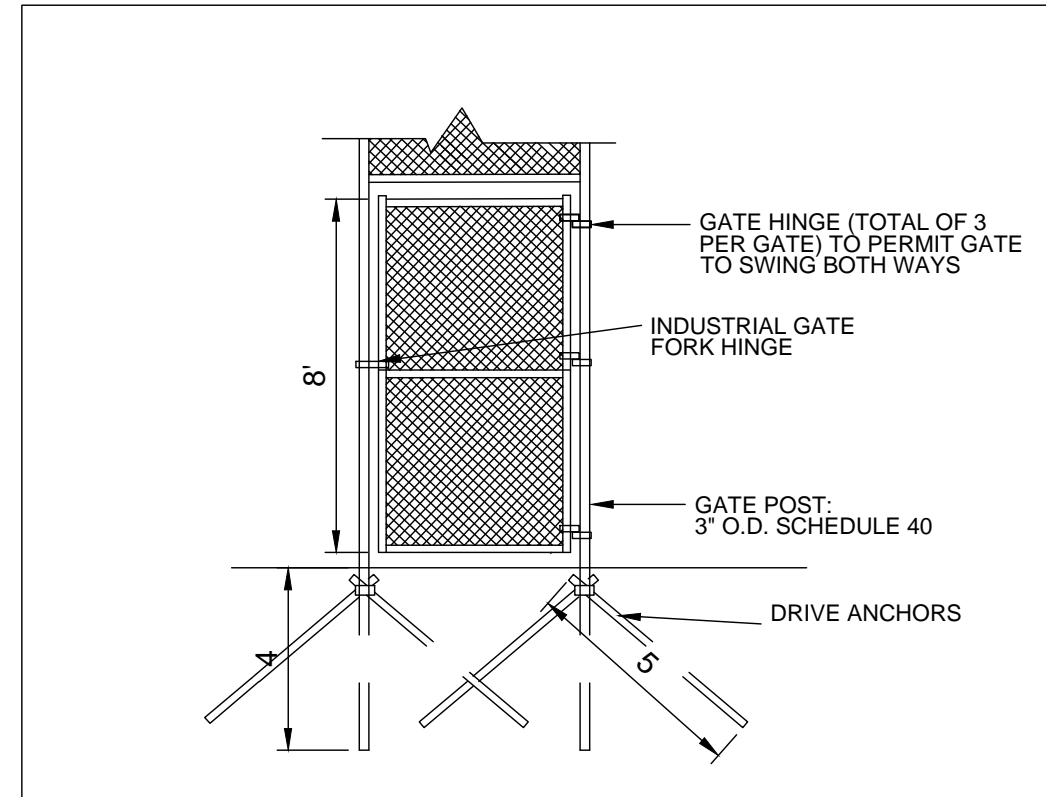


2 4' WIDTH FENCE GATE
NTS

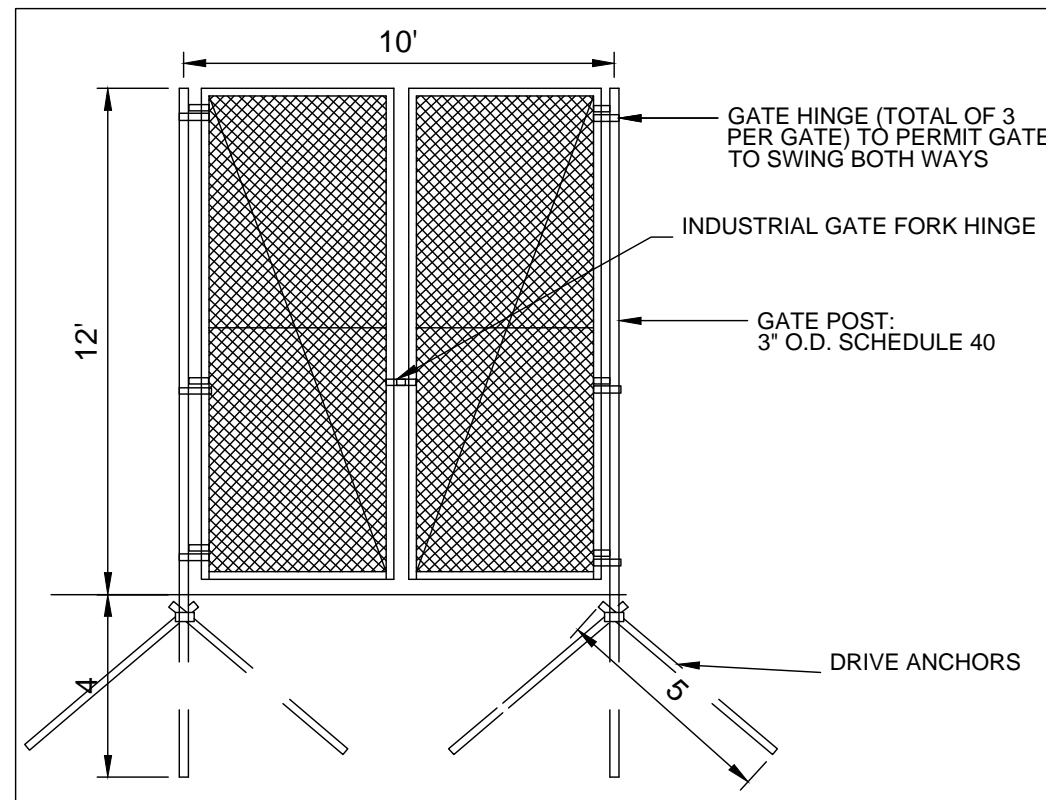

3 10' WIDTH MAINTENANCE GATE
NTS

City of Madison
Department of Public Works
PARKS DIVISION
City-County Building, Suite 104
210 Martin Luther King, Jr. Blvd.
Madison, WI 53703

 play
MADISON
PARKS



PROJECT:

**2024 RENNEBOHM PARK
EAST TENNIS COURTS**

PROJECT ADDRESS:

**RENNEBOHM PARK
115 N EAU CLAIRE AVE
MADISON, WI 53705**

Although every effort has been made in preparing these plans and checking them for accuracy, the contractor and subcontractors must check all details and dimensions of their trade and be responsible for the same.

ITEM	DATE
REVISED BY: K KANE	
DRAWN BY: K KANE	2024-01-05
STORMWATER MANAGEMENT DESIGNED BY: C.STELLIES	

**FENCING AND
GATE DETAILS**

 
SHEET NUMBER:

1.8

NOTES

- 1) STRIPING DIMENSIONS PER U.S. TENNIS COURT AND TRACK BUILDERS ASSOCIATION & USTA AND USAPA - SEE BID ITEMS 90009 & 90010 FOR MORE INFORMATION
- 2) COURT DIMENSIONS SHOWN ARE INCLUSIVE OF LINES
- 3) WIDTH FOR ALL LINES IS TWO INCHES (2"), EXCEPT THE BASE LINE WHICH MAY BE BETWEEN 2" AND 4" IN WIDTH
- 4) CENTER MARK FOR TENNIS SHALL EXTEND 2" BEYOND INSIDE EDGE OF BASE LINE

City of Madison
 Department of Public Works
PARKS DIVISION
 City-County Building, Suite 104
 210 Martin Luther King, Jr. Blvd.
 Madison, WI 53703



PROJECT:
**2024 RENNEBOHM PARK
 EAST TENNIS COURTS**



PROJECT ADDRESS:
**RENNEBOHM PARK
 115 N EAU CLAIRE AVE
 MADISON, WI 53705**

Although every effort has been made in preparing these plans and checking them for accuracy, the contractor and subcontractors must check all details and dimensions of their trade and be responsible for the same.

ITEM	DATE
REVISED BY: K KANE	
DRAWN BY: K KANE	2024-01-05
STORMWATER MANAGEMENT DESIGNED BY: C. STELLIES	

**COURT STRIPING
 DETAILS**

SHEET NUMBER:
1.9

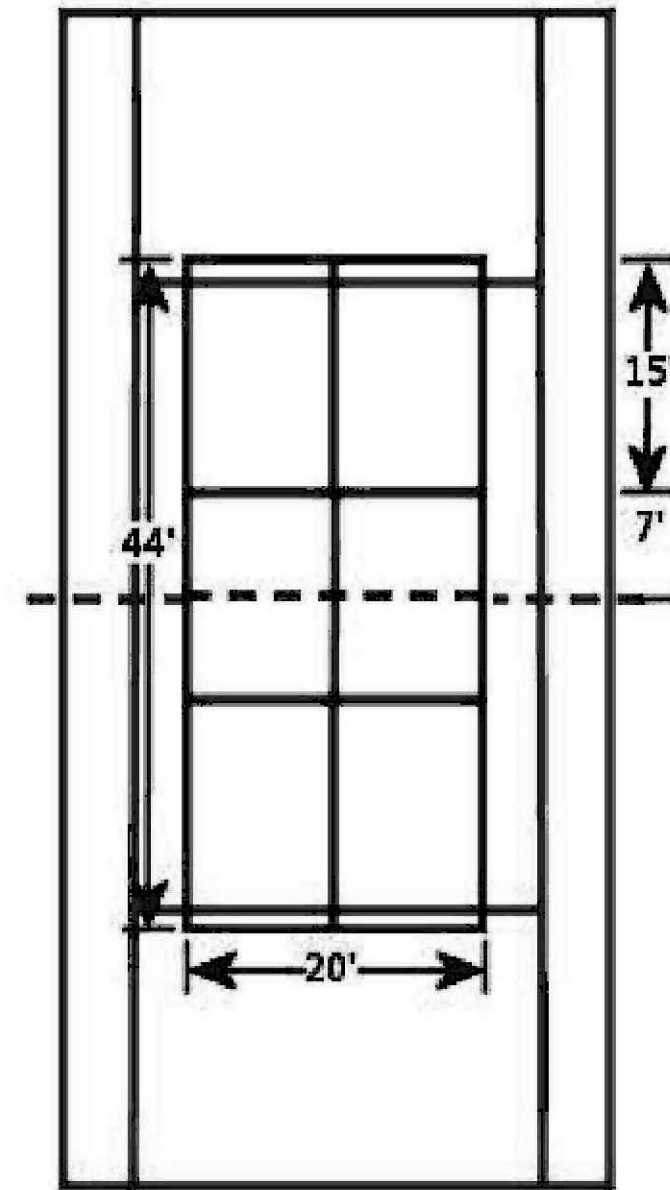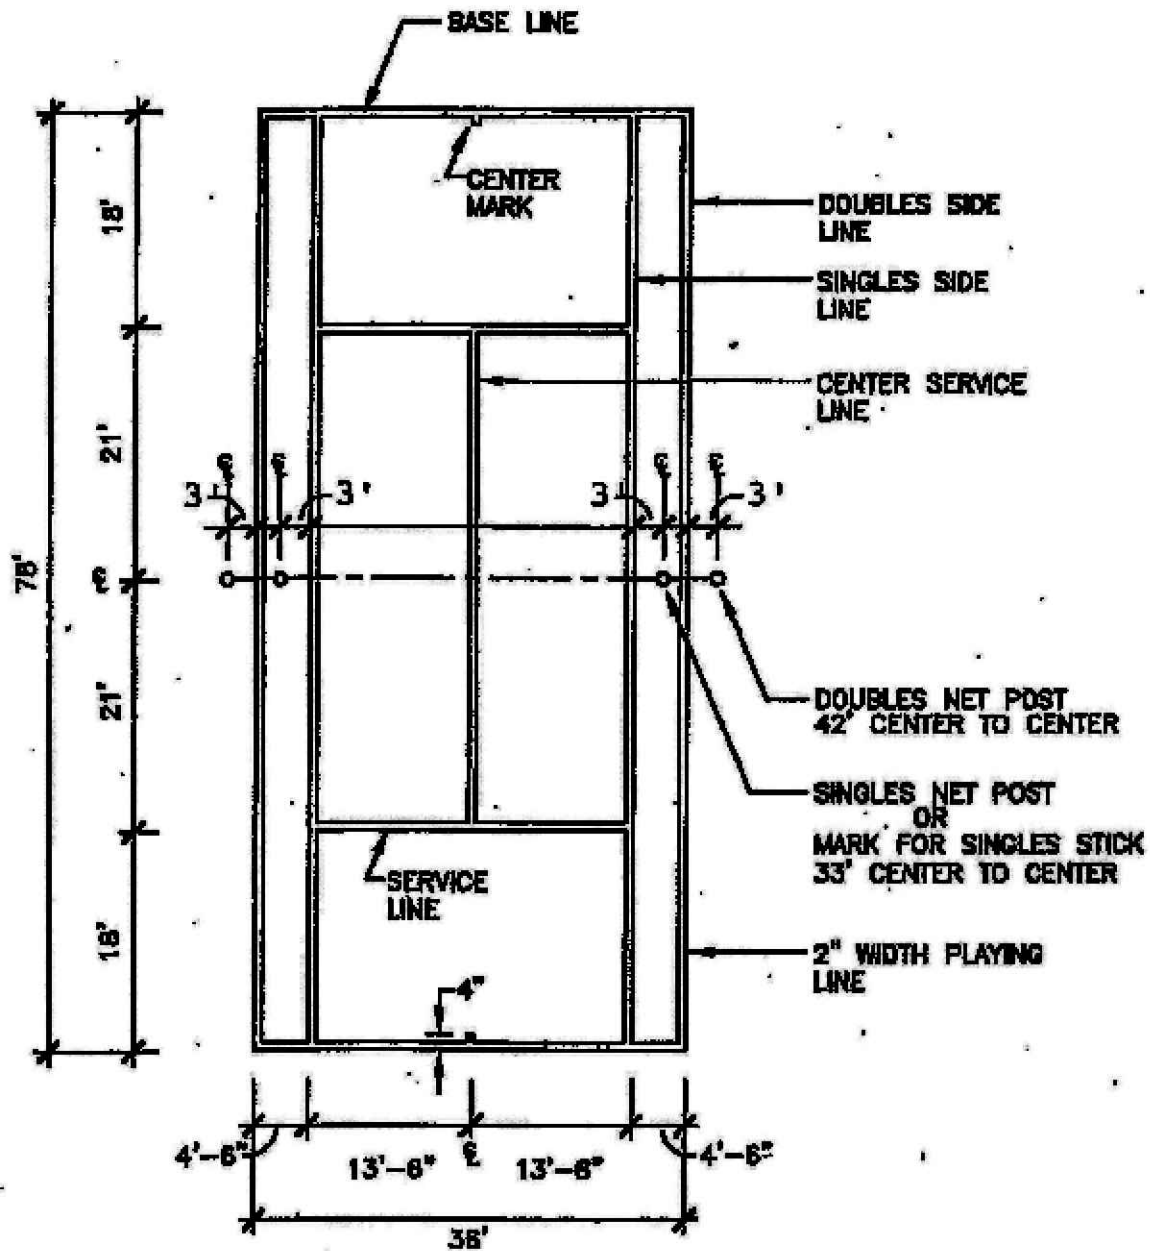

1 TENNIS COURT STRIPING LAYOUT
 NTS

2 DUAL TENNIS-PICKLEBALL COURT STRIPING LAYOUT
 NTS

City of Madison
 Department of Public Works
PARKS DIVISION
 City-County Building, Suite 104
 210 Martin Luther King, Jr. Blvd.
 Madison, WI 53703

play
**MADISON
 PARKS**

Graphical Scale
 0 30



PROJECT:

*2024 RENNEBOHM PARK
 EAST TENNIS COURTS*

PROJECT ADDRESS:

*RENNEBOHM PARK
 115 N EAU CLAIRE AVE
 MADISON, WI 53705*


Although every effort has been made in preparing these plans and checking them for accuracy, the contractor and subcontractors must check all details and dimensions of their trade and be responsible for the same.

ITEM	DATE
REVISED BY: K KANE	
DRAWN BY: K KANE	2024-01-05
STORMWATER MANAGEMENT DESIGNED BY: C. STELLIES	


*NET POST AND
 TIE-DOWN
 DETAILS*

SHEET NUMBER:

1.10

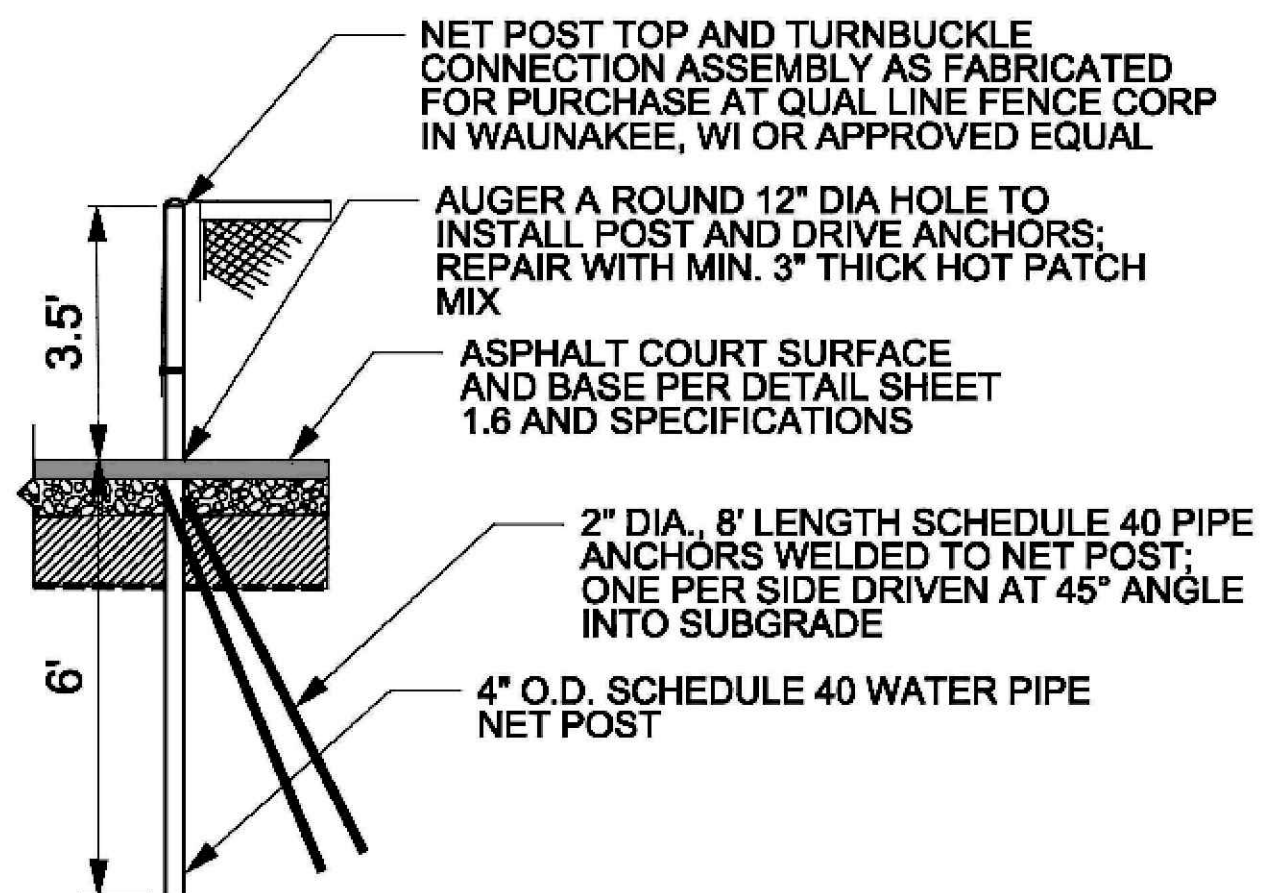

① NET POST
 NTS

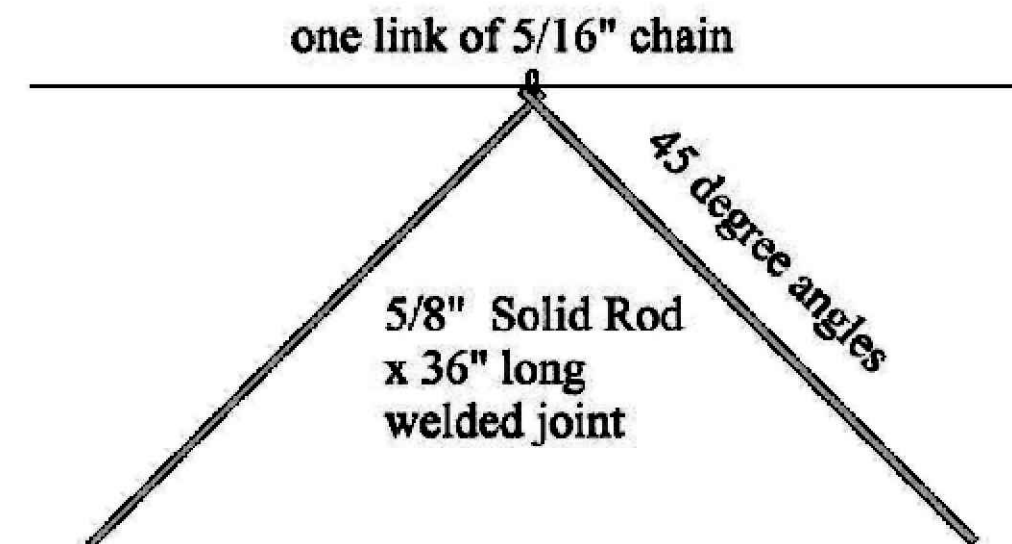

② CENTER NET TIE-DOWN
 NTS