


Revised 4-15-11  
SITE PLAN


- COLLEEN BAL Valley, CA
1. Two Courts 58' X 32'
  2. SAND BAG Edging AROUND COURT
  3. LIGHTS IN MIDDLE OF COURT
  4. LOOSE 16 PARKING STALLS
  5. LIGHTS - 7-30' POLES WITH 400 WATT METAL HALIDE HEADS

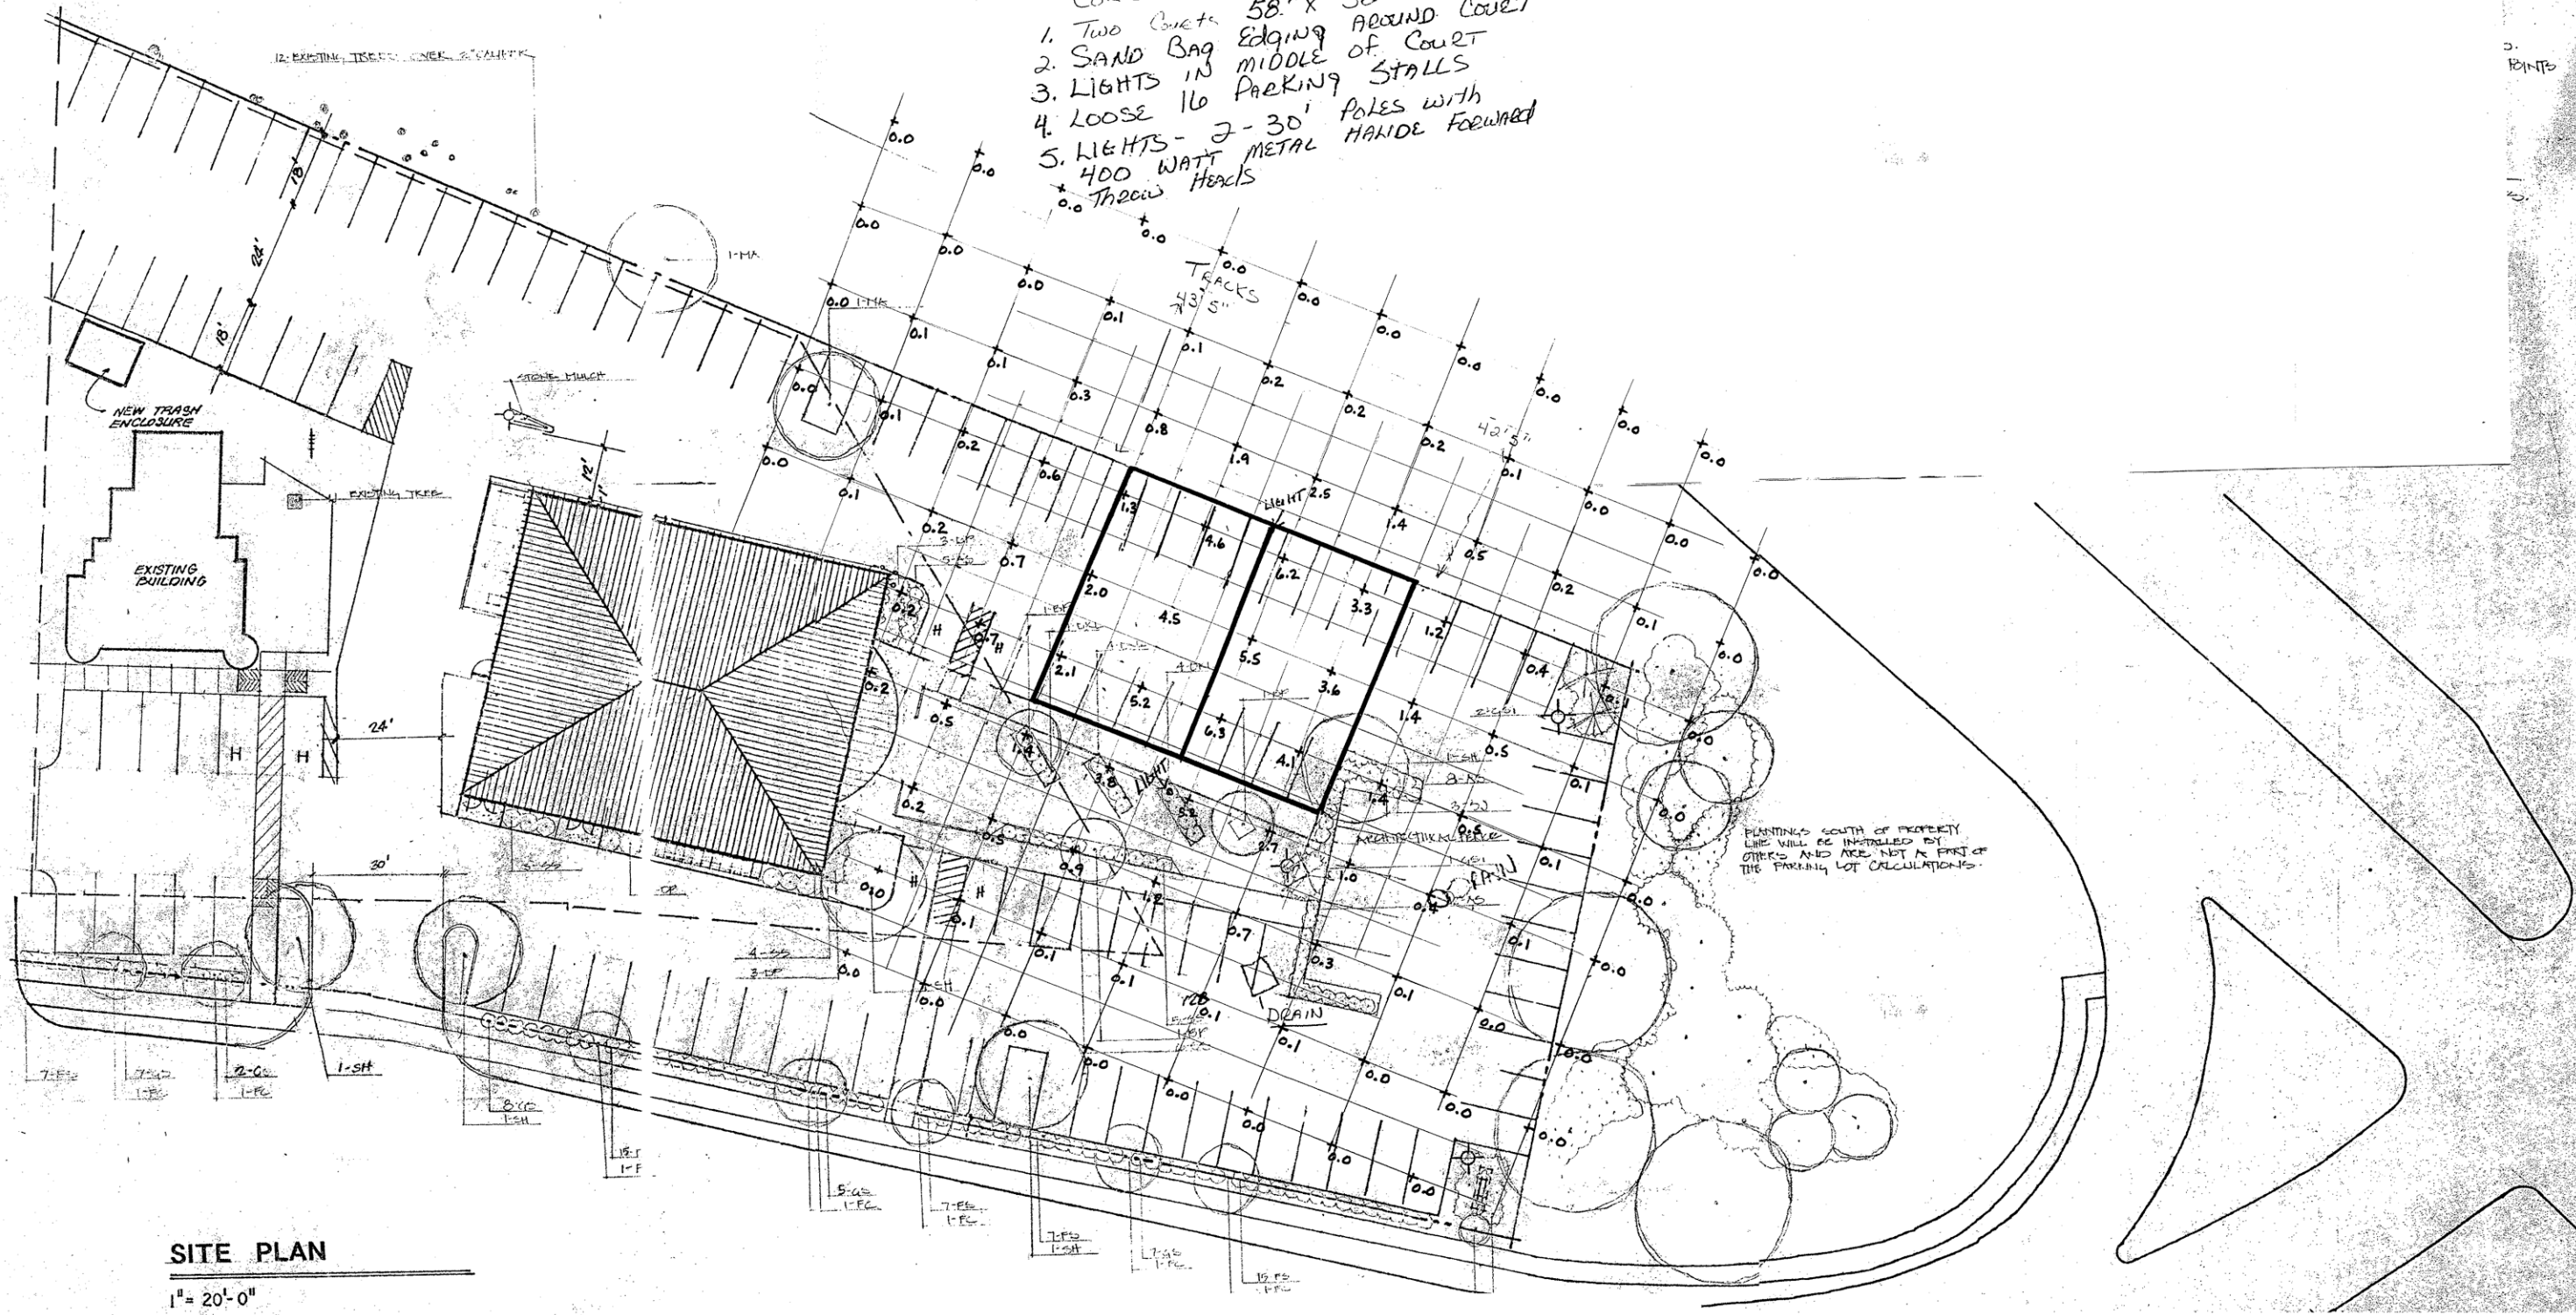


SITE PLAN

1" = 20'-0"

3. PRINTS

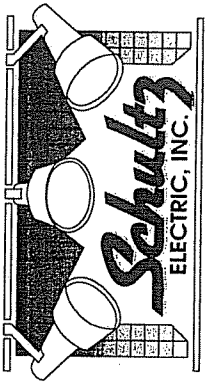

**COLISEUM BAR**  
Volleyball Court Lighting

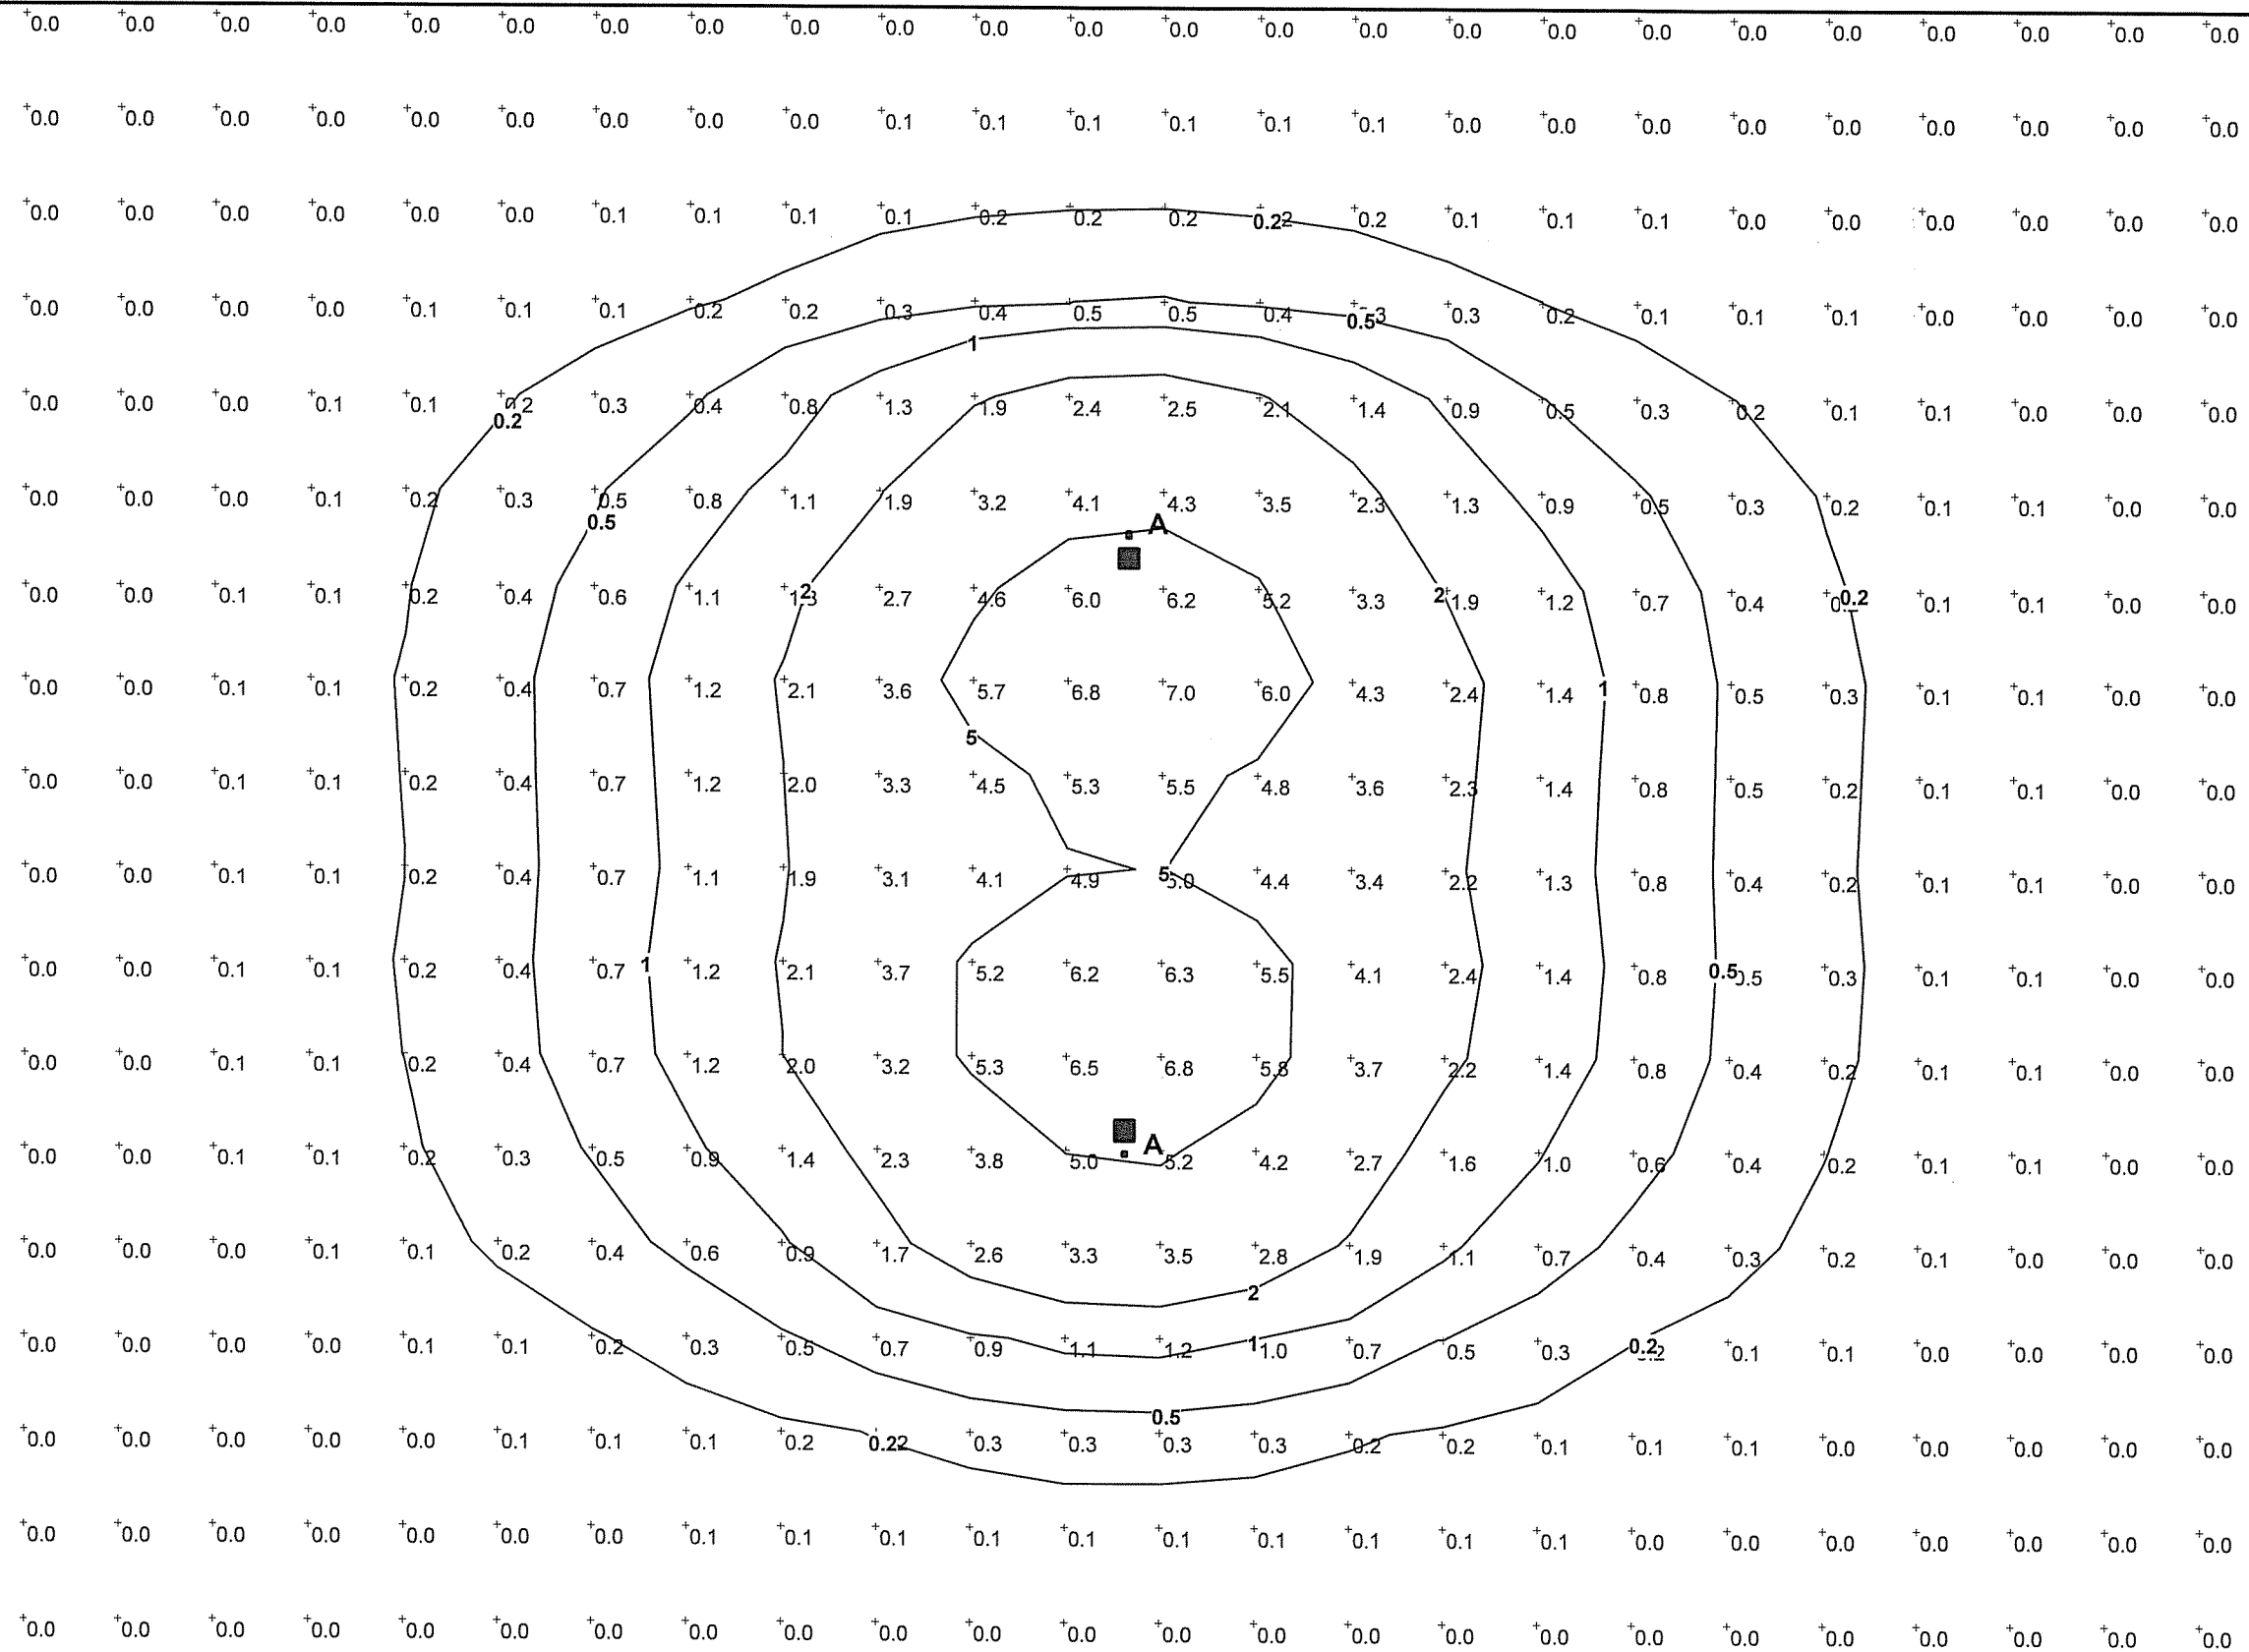

**LUMINAIRE SCHEDULE**

Symbol	Label	Qty	Catalog Number	Description	Lamp	File	Lumens	LLF	Watts
■	A	2	AC2640	16" AREA CUTOFF / FORWARD THROW	400 WATT PSMH	ACS2640.ies	36000	0.80	460

**Plan View**  
Scale 1" = 20'

**Designer**  
TM

**Date**  
Apr 20 2011

**Scale**  
As Noted

**Drawing No.**  
E-1