


LAKEVIEW SPEC HOME

105 E LAKEVIEW AVE

MADISON, WI

DEMOLITION PLAN

JOB DESCRIPTION:
DEMOLITION OF EXISTING SINGLE-FAMILY HOME

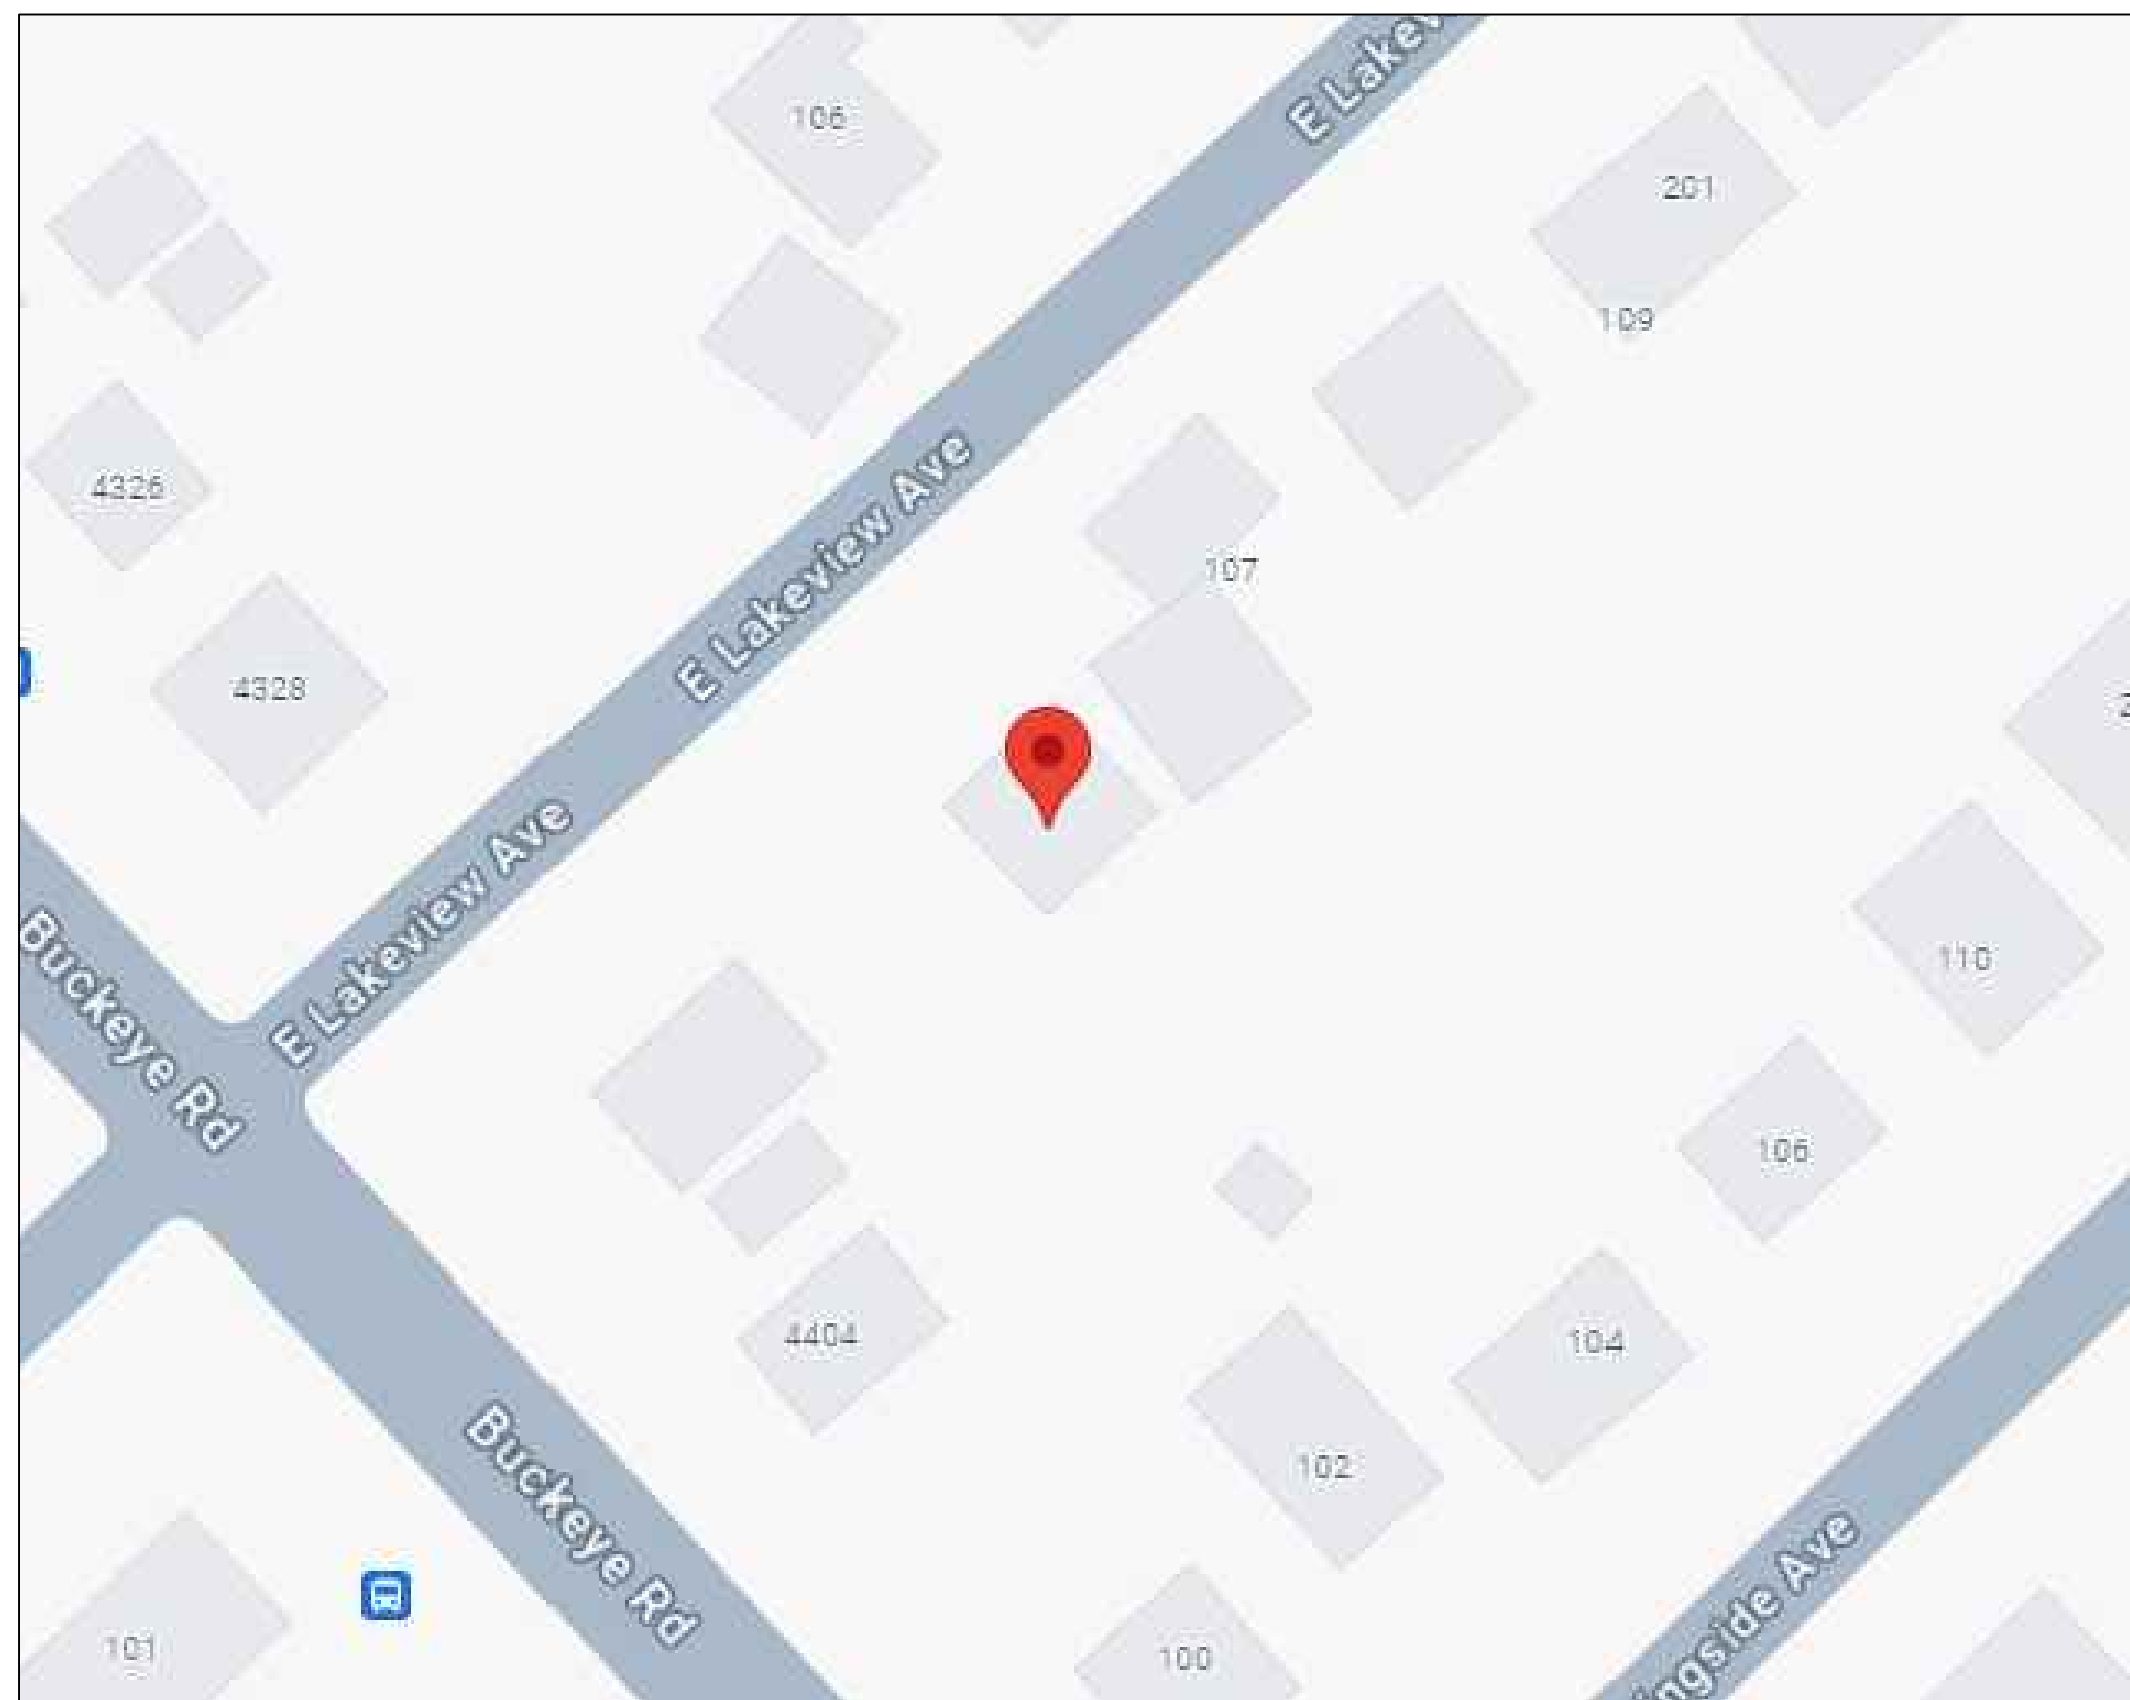

SHEET INDEX:

DM0.0	COVER SHEET
DM1.1	1ST FLR FA LAYOUT

105 E LAKEVIEW AVE

DRAWN BY: _____
LAYOUT BY: _____
APPROVED BY: _____
DATE: 3/11/24
SCALE: N/A
PROJECT NO: _____

FIRE ALARM SYSTEM
DEMOLITION PLAN

SHEET
DM0.0

 


NOTES:


ALL EXISTING BUILDING COMPONENTS THAT ARE HIGHLIGHTED INCLUDING FOUNDATION AND DRIVEWAY WILL BE REMOVED.

THE HOLE LEFT AFTER DEMOLITION IS COMPLETE WILL BE FILLED TO AVOID POTENTIAL INJURY TO PASSERSBY.

NO EXISTING PUBLIC OR PRIVATE TREES WILL BE REMOVED IN THE DEMOLITION PROCESS.



105 E LAKEVIEW AVE

 

DATE: 3/11/24
SCALE: 3/32" = 1'
PROJECT NO:

FIRE ALARM SYSTEM
DEMOLITION PLAN



SHEET
DM1.1