

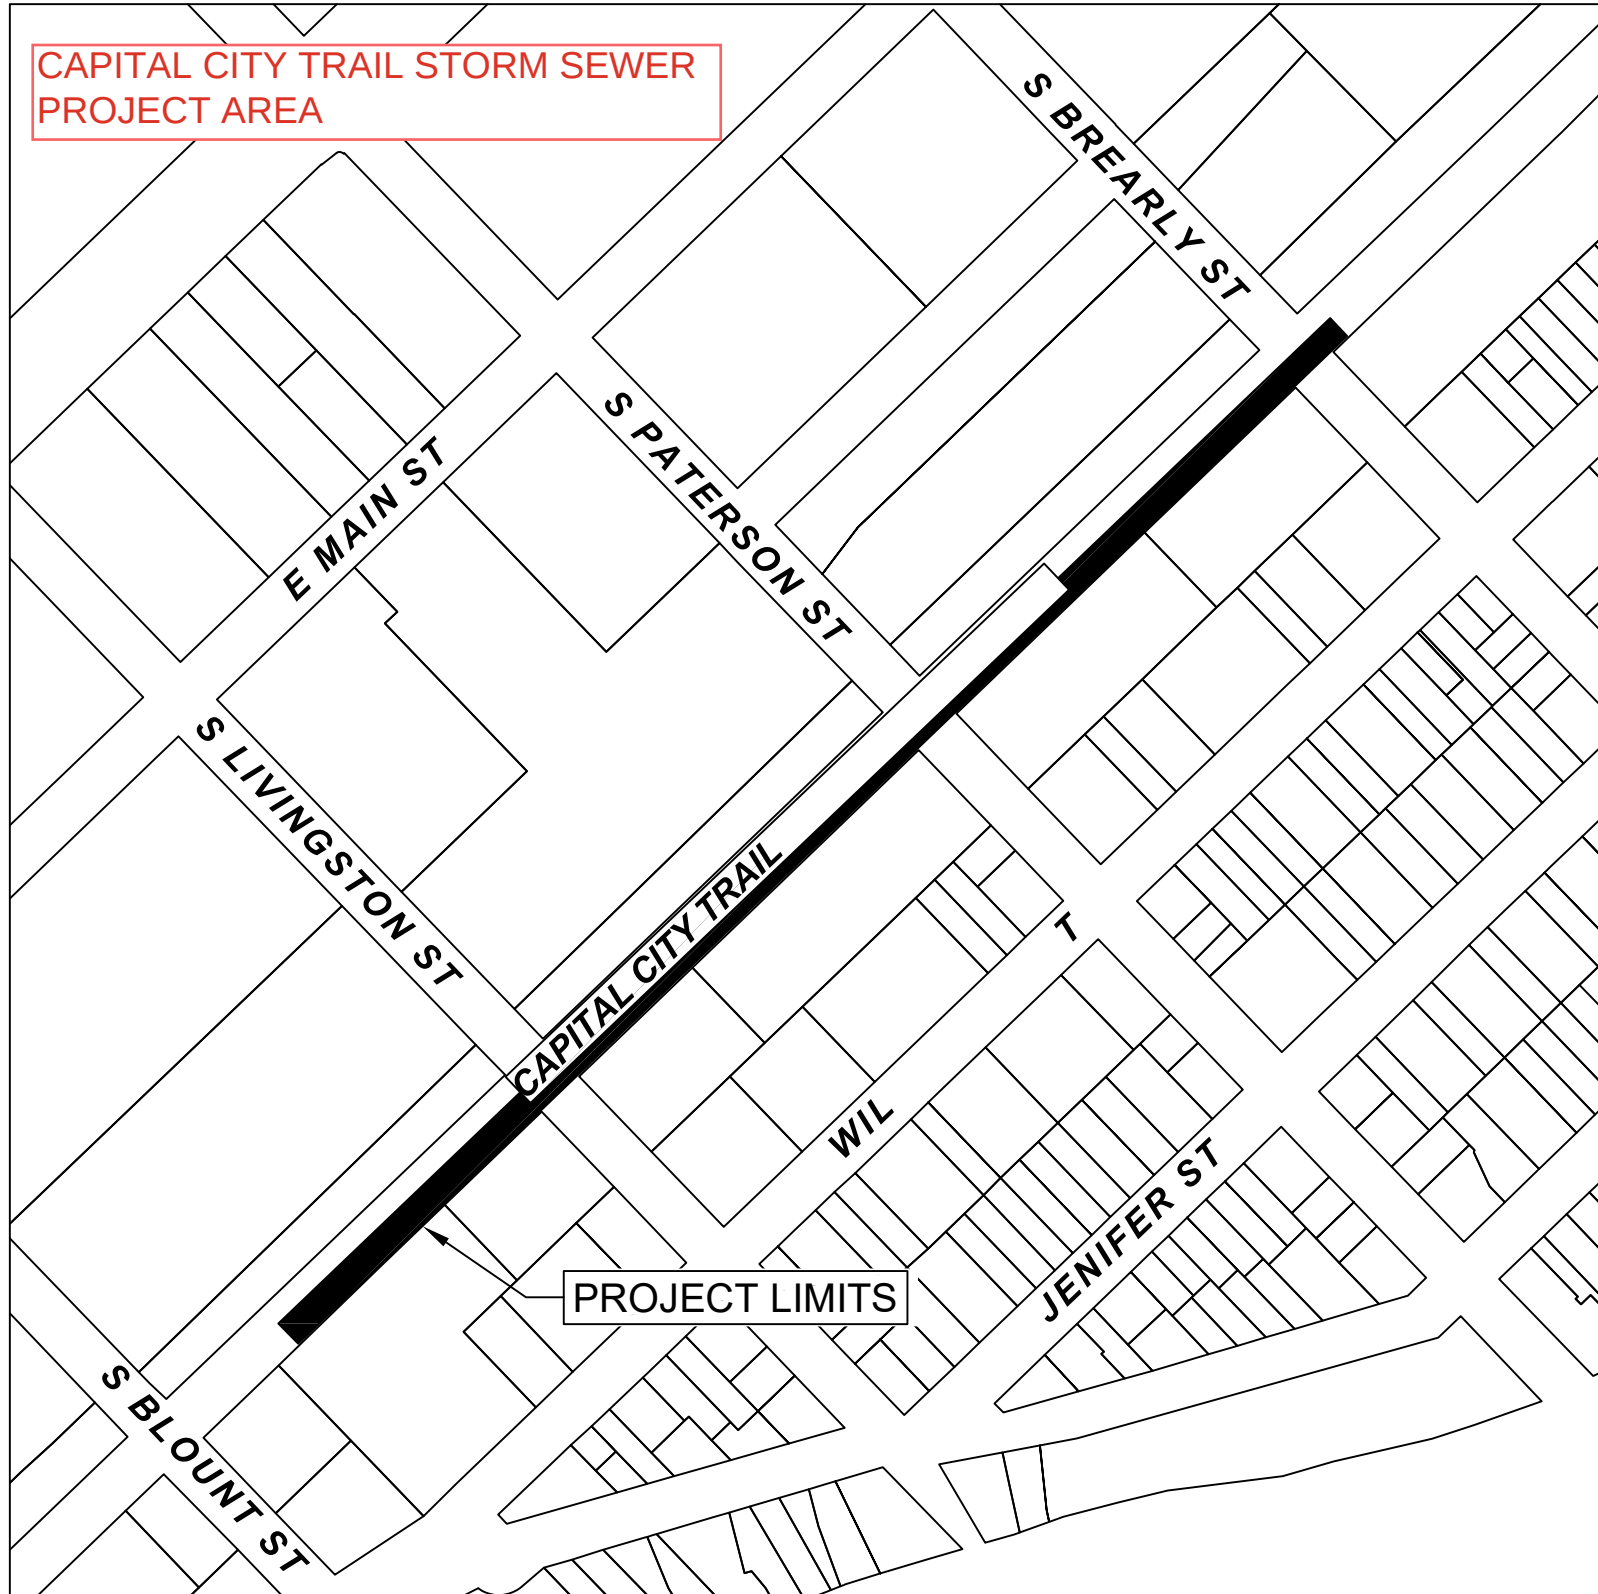


CAPITAL CITY TRAIL STORM SEWER
PROJECT AREA

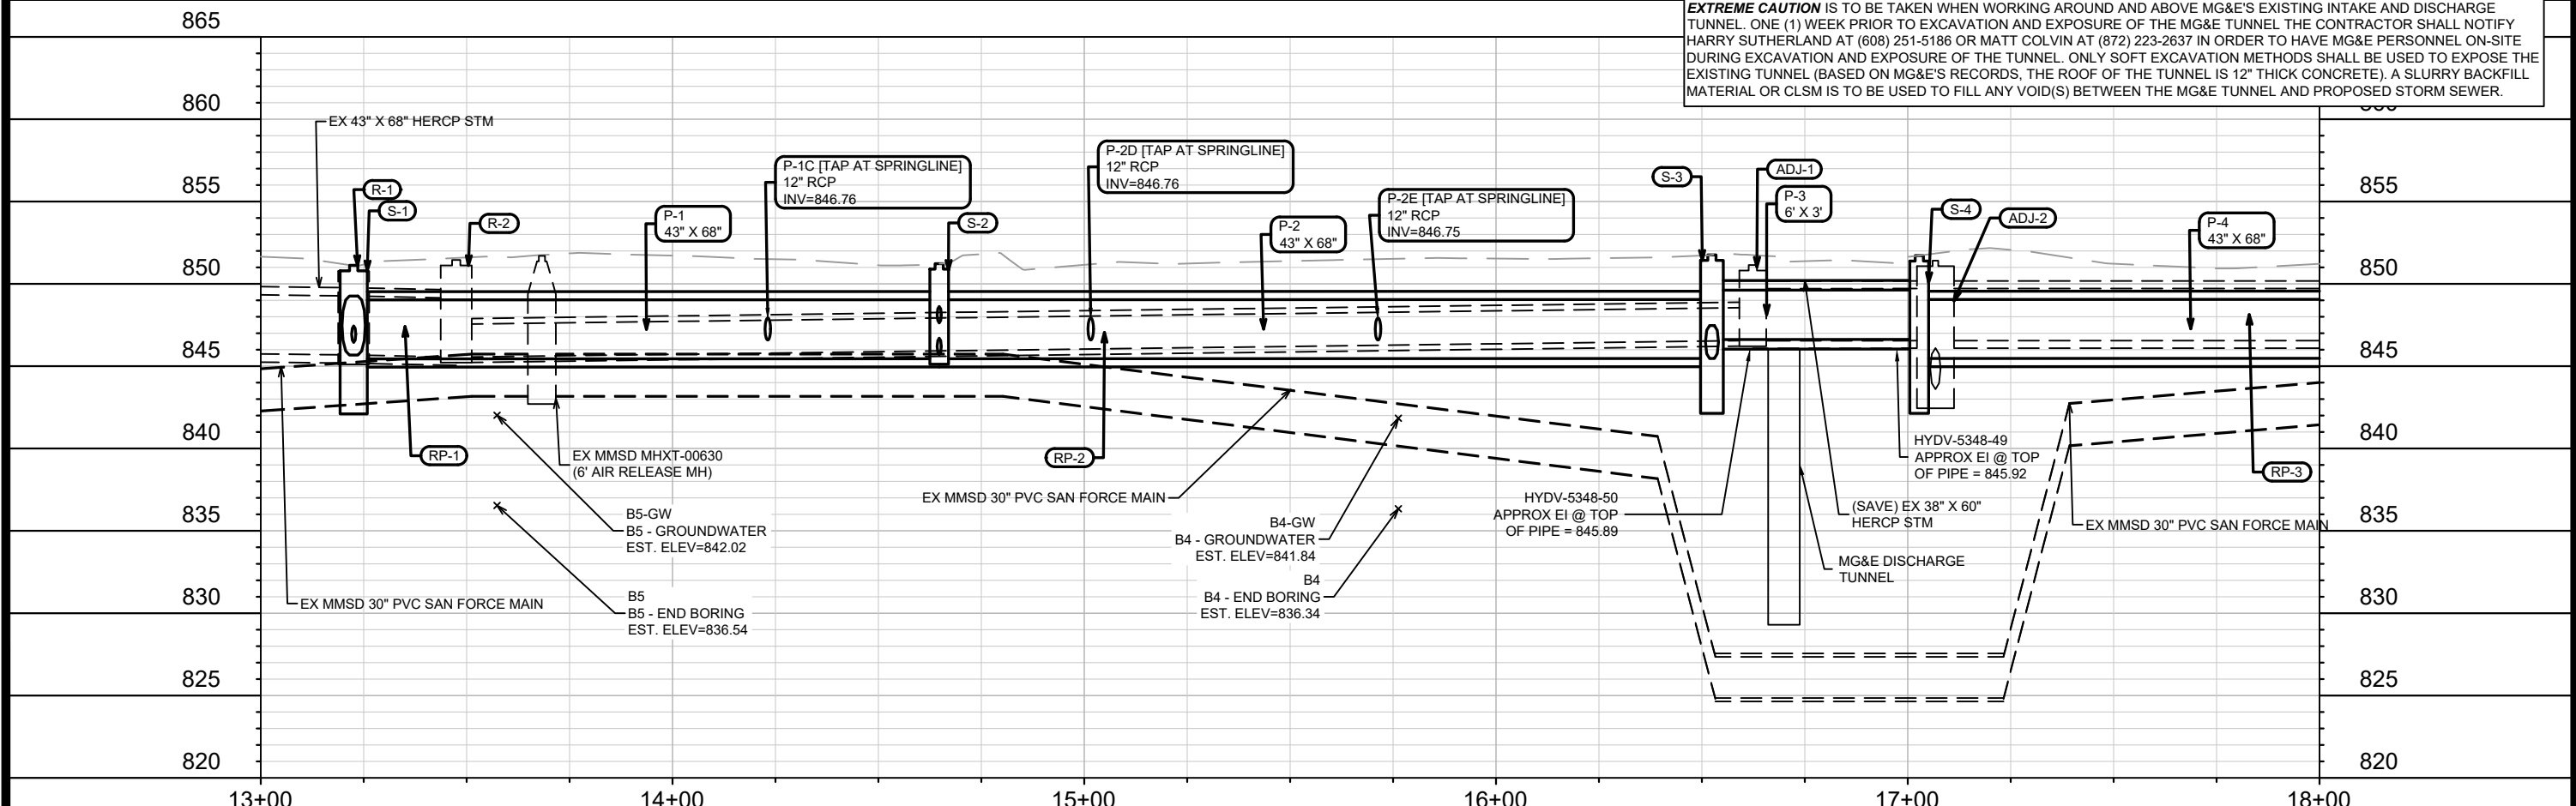

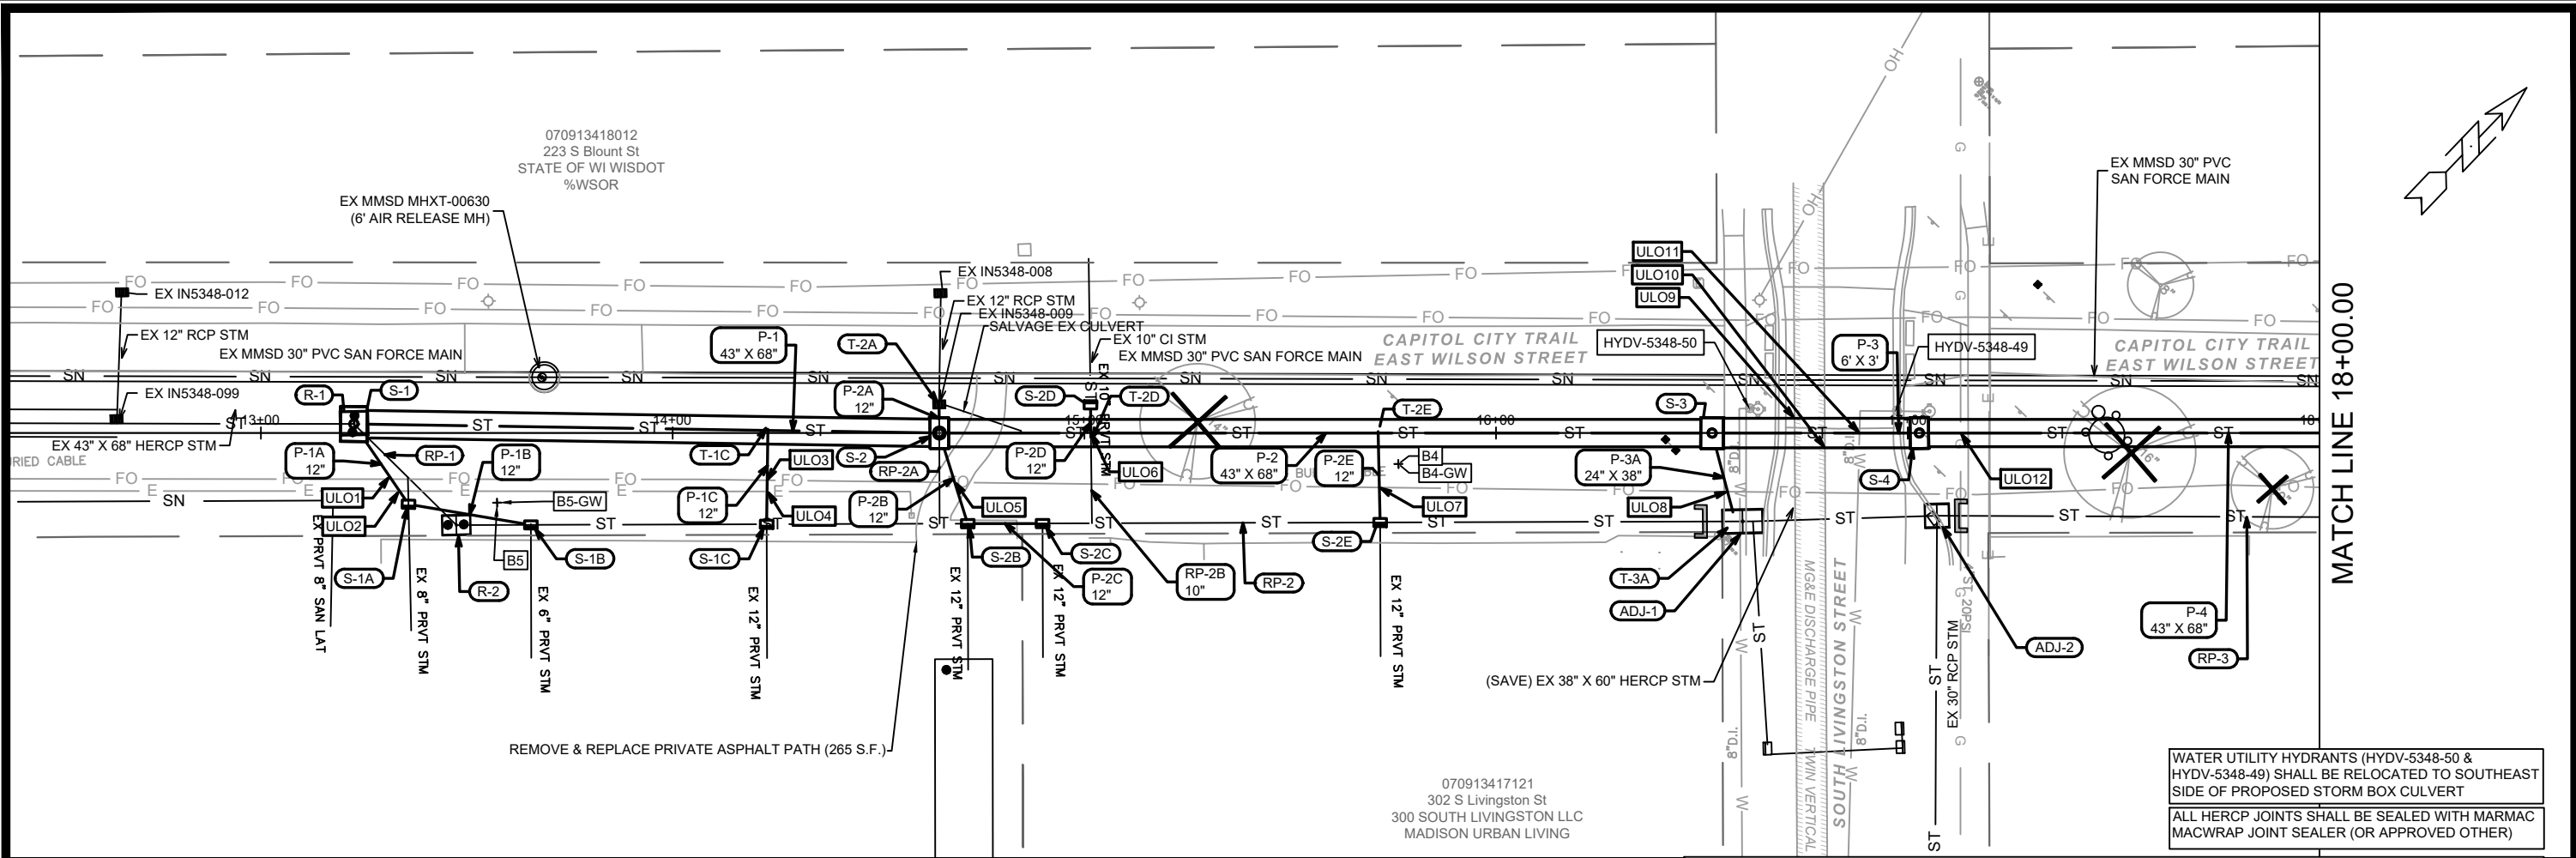


EXTREME CAUTION IS TO BE TAKEN WHEN WORKING AROUND AND ABOVE MG&E'S EXISTING INTAKE AND DISCHARGE TUNNEL. ONE (1) WEEK PRIOR TO EXCAVATION AND EXPOSURE OF THE MG&E TUNNEL THE CONTRACTOR SHALL NOTIFY HARRY SUTHERLAND AT (608) 251-5186 OR MATT COLVIN AT (872) 223-2637 IN ORDER TO HAVE MG&E PERSONNEL ON-SITE DURING EXCAVATION AND EXPOSURE OF THE TUNNEL. ONLY SOFT EXCAVATION METHODS SHALL BE USED TO EXPOSE THE EXISTING TUNNEL (BASED ON MG&E'S RECORDS, THE ROOF OF THE TUNNEL IS 12" THICK CONCRETE). A SLURRY BACKFILL MATERIAL OR CLSM IS TO BE USED TO FILL ANY VOID(S) BETWEEN THE MG&E TUNNEL AND PROPOSED STORM SEWER.

15271		MADISON, WI		CONTRACT NO: 9591	
CAPITAL CITY TRAIL SEWER UTILITY PLAN & PROFILE		CAPITAL CITY TRAIL STORM SEWER		U-1	
M:\DESIGN\Projects\15271\CAD\Sewers\15271SWR-PipeNetwork.dwg		15271		U-1	
DATE		REVISION		BY	
3/26/2025 4:54 PM					
Scale: 1" = 40'					

MATCH LINE 18+00.00

MATCH LINE 22+50.00

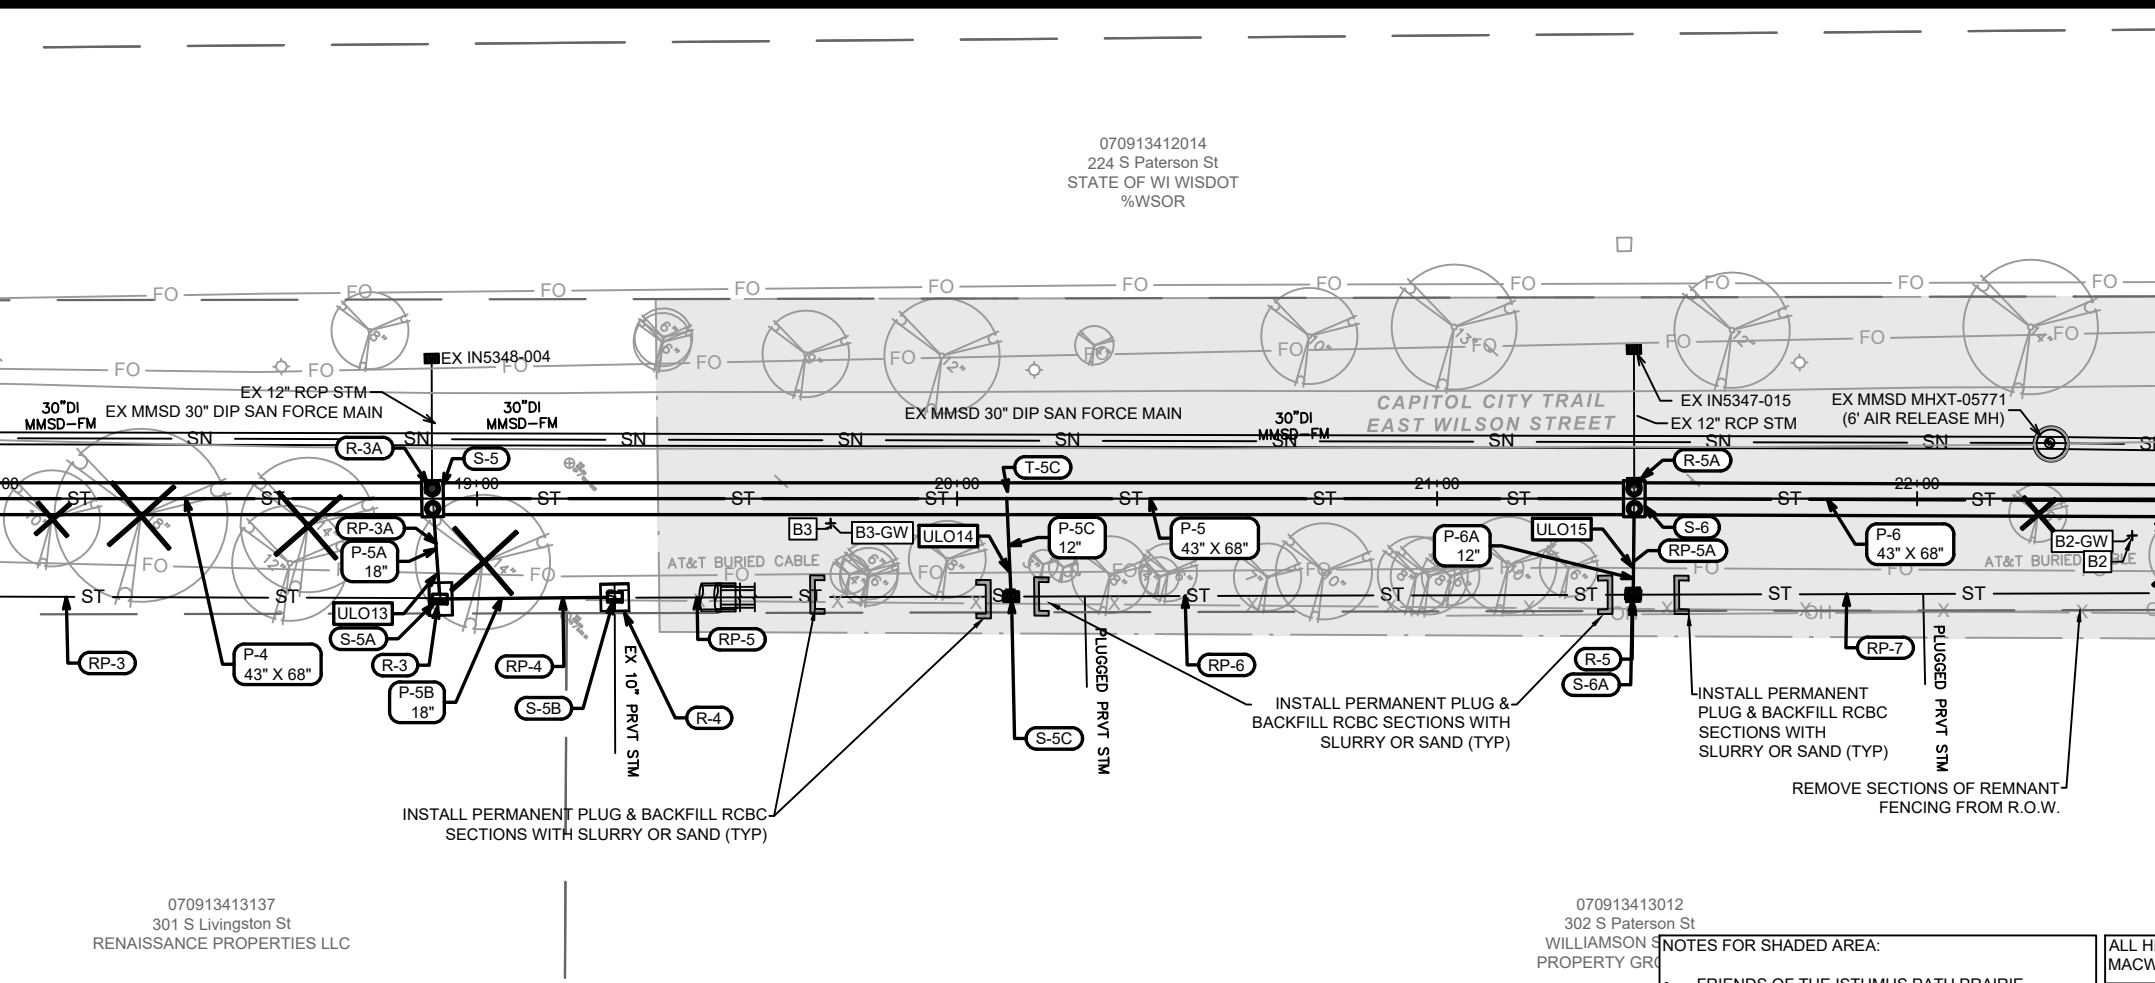

870

865

860

855

850


845

840

835

830

825

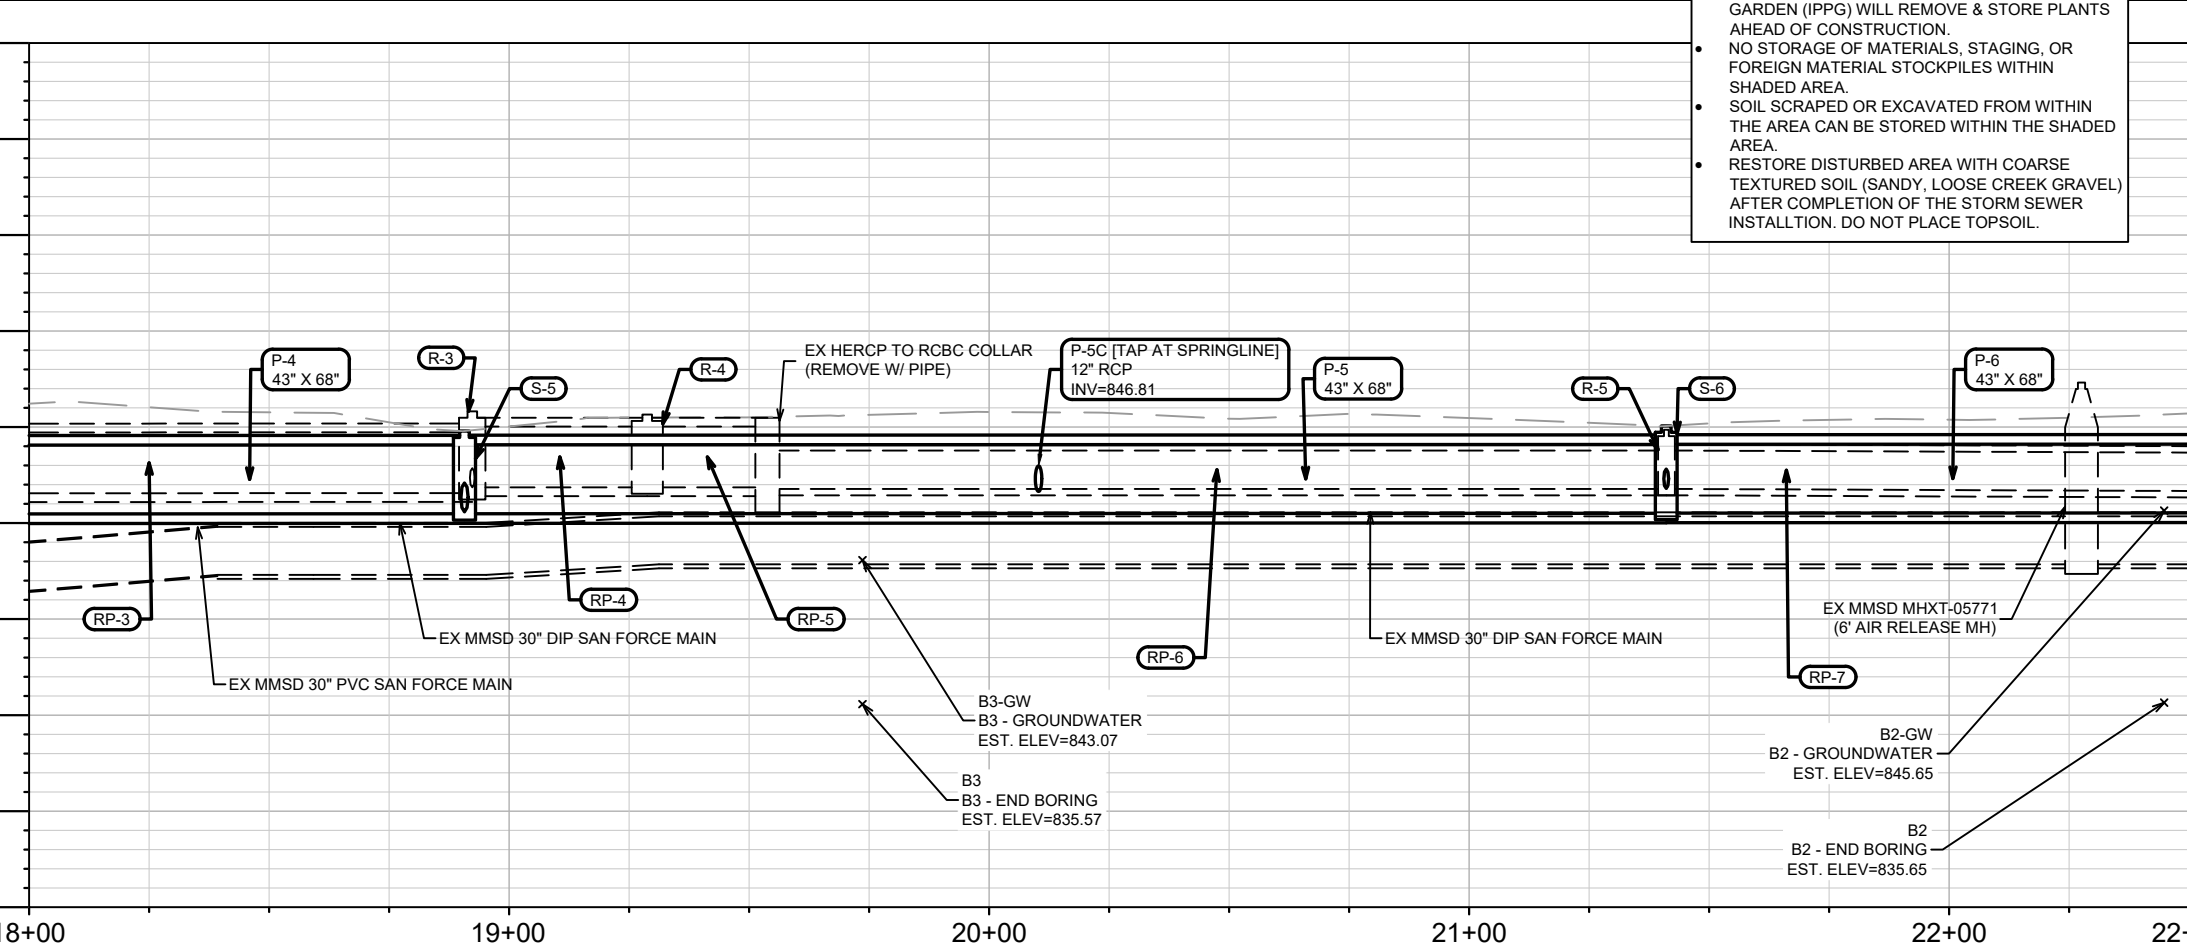

870

865

860

855

850

845

840

835

830

825

18+00

19+00

20+00

21+00

22+00

22+50

- NOTES FOR SHADED AREA:
- FRIENDS OF THE ISTHMUS PATH PRAIRIE GARDEN (IPPG) WILL REMOVE & STORE PLANTS AHEAD OF CONSTRUCTION.
 - NO STORAGE OF MATERIALS, STAGING, OR FOREIGN MATERIAL STOCKPILES WITHIN SHADED AREA.
 - SOIL SCRAPED OR EXCAVATED FROM WITHIN THE AREA CAN BE STORED WITHIN THE SHADED AREA.
 - RESTORE DISTURBED AREA WITH COARSE TEXTURED SOIL (SANDY, LOOSE CREEK GRAVEL) AFTER COMPLETION OF THE STORM SEWER INSTALLTION. DO NOT PLACE TOPSOIL.

ALL HERCP JOINTS SHALL BE SEALED WITH MARMAC MACWRAP JOINT SEALER (OR APPROVED OTHER)

CAPITAL CITY TRAIL SEWER UTILITY PLAN & PROFILE

CAPITAL CITY TRAIL STORM SEWER

15271

U-2

15271

MADISON, WI

CONTRACT NO: 9591

070913412014
224 S Paterson St
STATE OF WI WISDOT
%WSOR

070913413012
302 S Paterson St
WILLIAMSON S
PROPERTY GRO

070913413137
301 S Livingston St
RENAISSANCE PROPERTIES LLC

REVISION

DATE

BY


15271

3/26/2025 4:54 PM

U-2


MATCH LINE 22+50.00

MATCH LINE 27+75.00

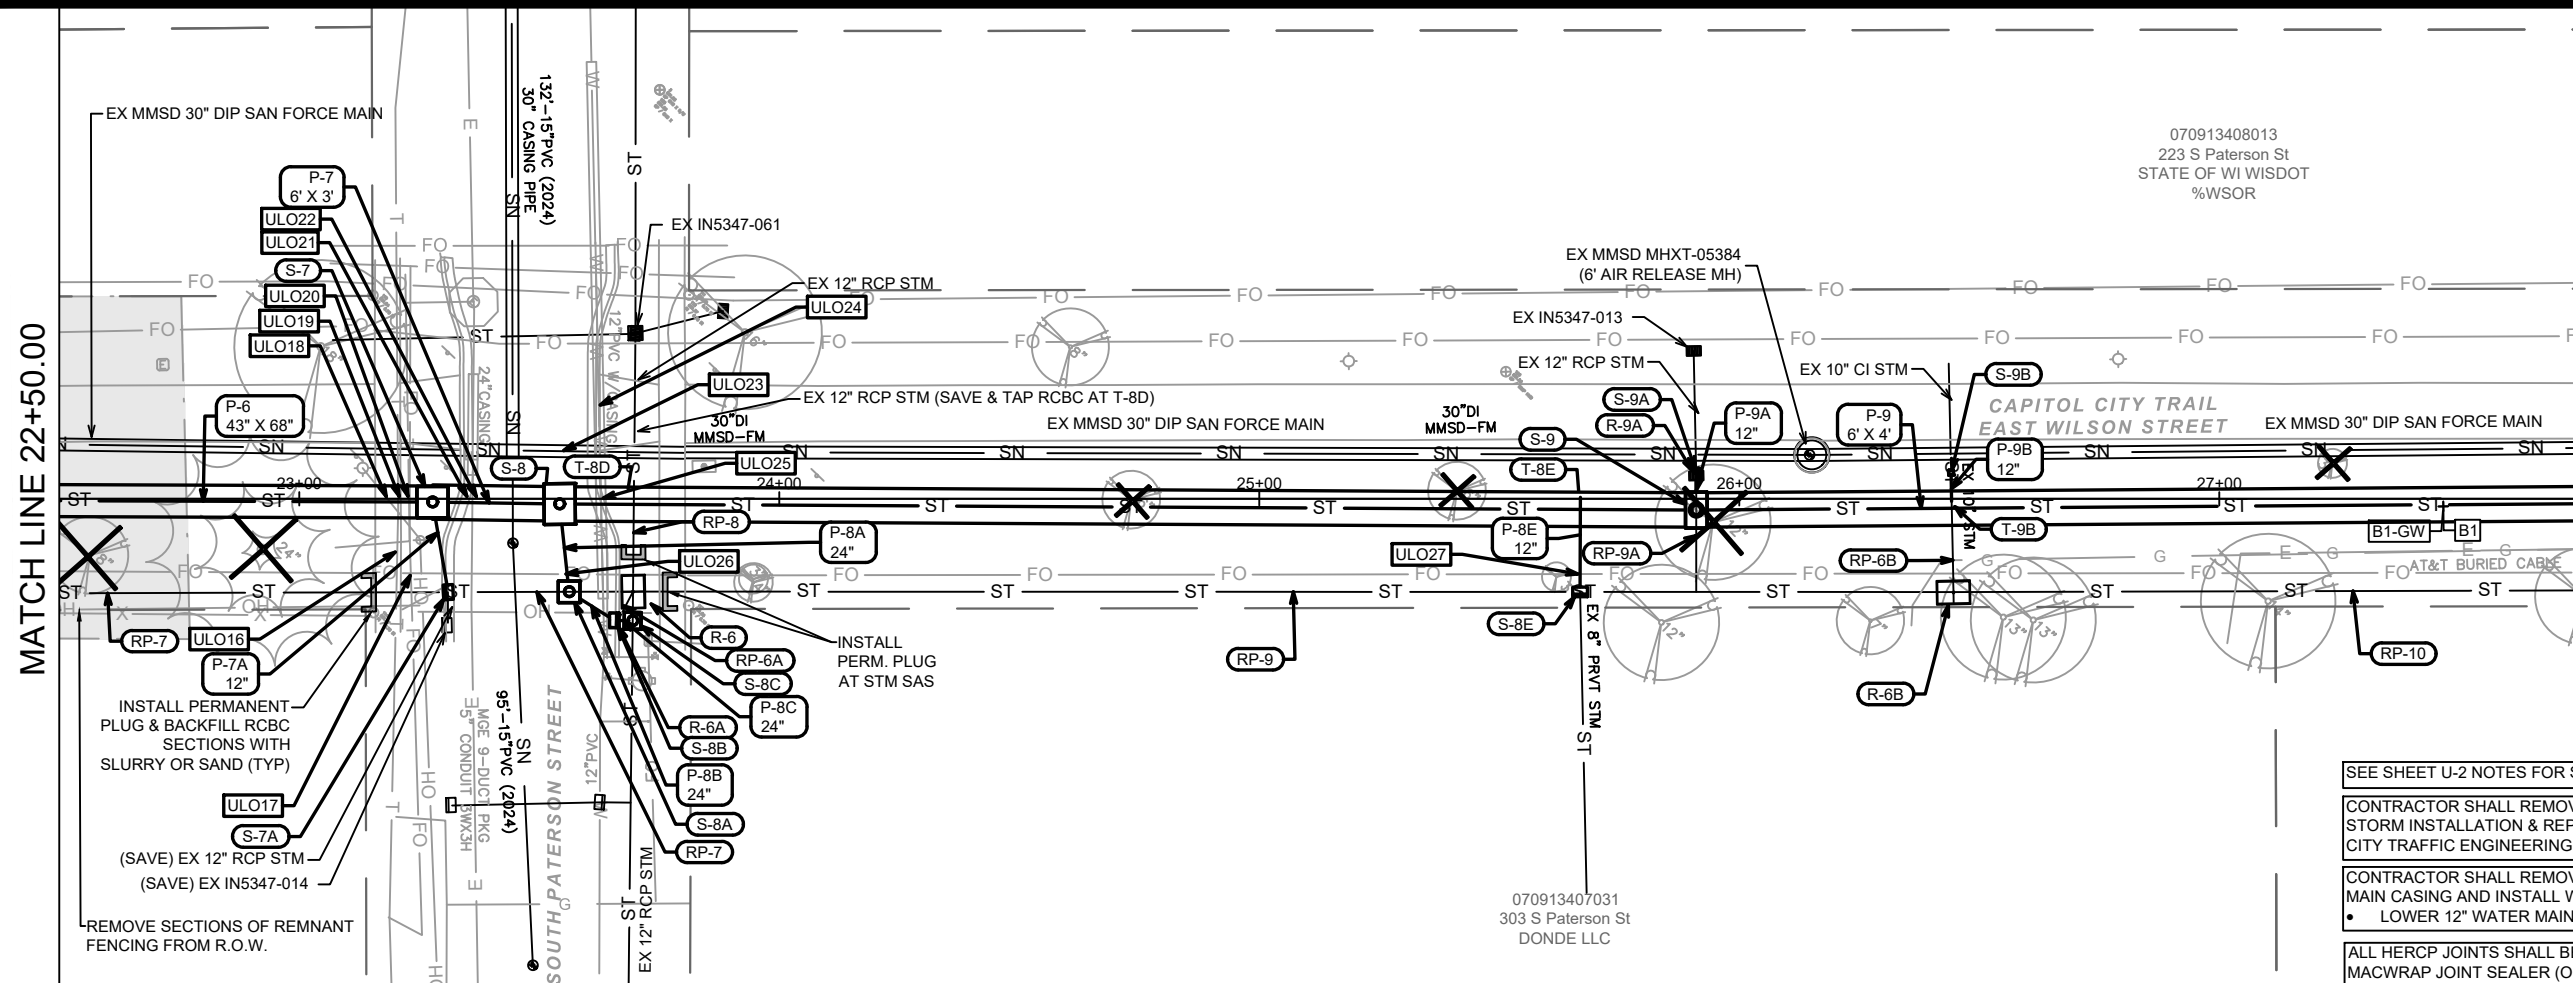

- SEE SHEET U-2 NOTES FOR SHADED AREA
- CONTRACTOR SHALL REMOVE PATH LIGHT POST FOR STORM INSTALLATION & REPLACE AS DIRECTED BY CITY TRAFFIC ENGINEERING
- CONTRACTOR SHALL REMOVE SECTION OF WATER MAIN CASING AND INSTALL WATER MAIN OFFSET
- LOWER 12" WATER MAIN TO INV = 840.34
- ALL HERCP JOINTS SHALL BE SEALED WITH MARMAC MACWRAP JOINT SEALER (OR APPROVED OTHER)

EXTREME CAUTION IS TO BE TAKEN WHEN WORKING AROUND AND ABOVE MG&E'S EXISTING ELECTRIC DUCT. ONE (1) WEEK PRIOR TO EXCAVATION AND EXPOSURE OF THE MG&E DUCT THE CONTRACTOR SHALL NOTIFY HARRY SUTHERLAND AT (608) 251-5186 OR MATT COLVIN AT (872) 223-2637 IN ORDER TO HAVE MG&E PERSONNEL ON-SITE DURING EXCAVATION.

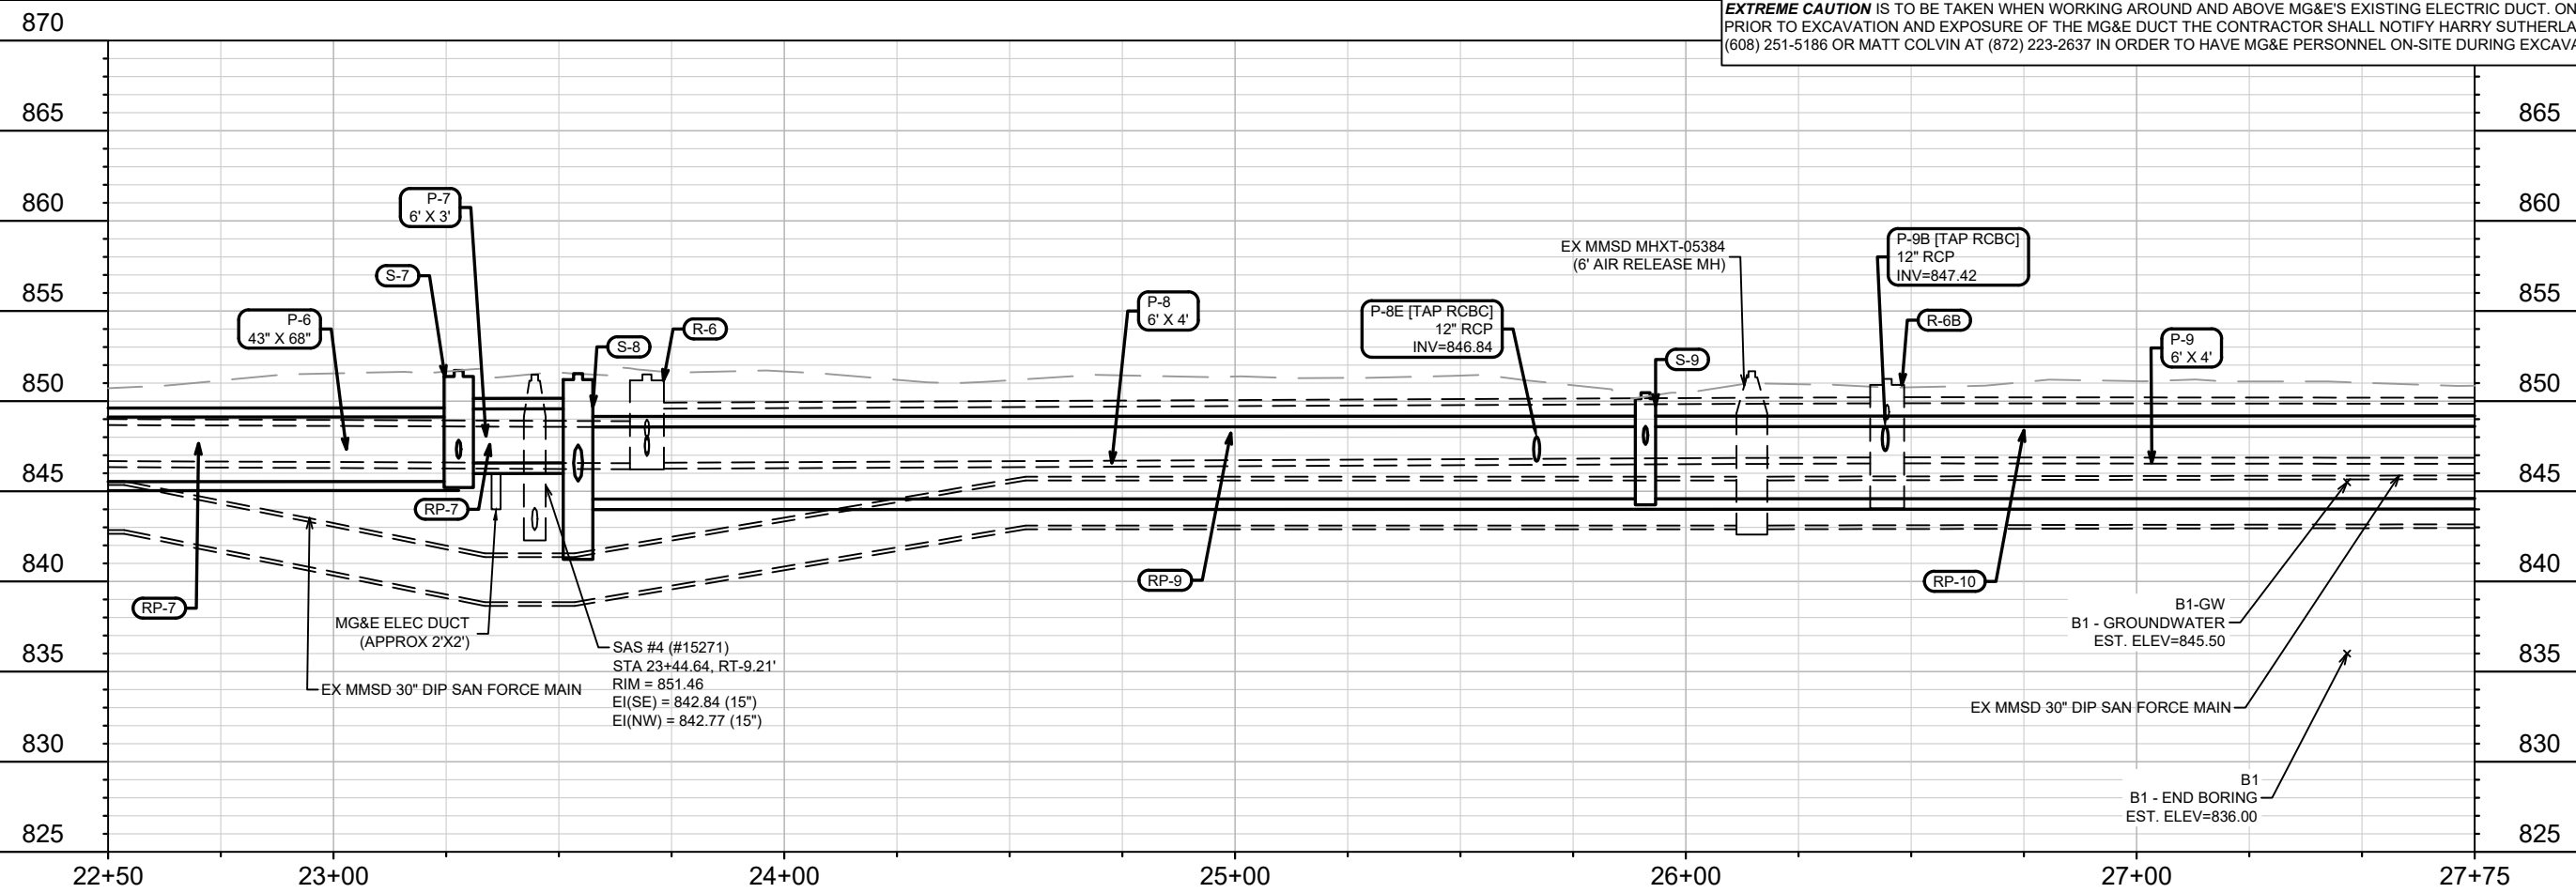

15271		MADISON, WI		CONTRACT NO: 9591	
CAPITAL CITY TRAIL SEWER UTILITY PLAN & PROFILE		CAPITAL CITY TRAIL STORM SEWER		U-3	
M:\DESIGN\Projects\15271\CAD\Sewers\15271SWR-PipeNetwork.dwg		15271		U-3	

15271

U-3

