




**FIRE SPRINKLER PLAN - 2ND FLOOR**  
 1/4" = 1'-0" FLOOR EL. (110'-0")

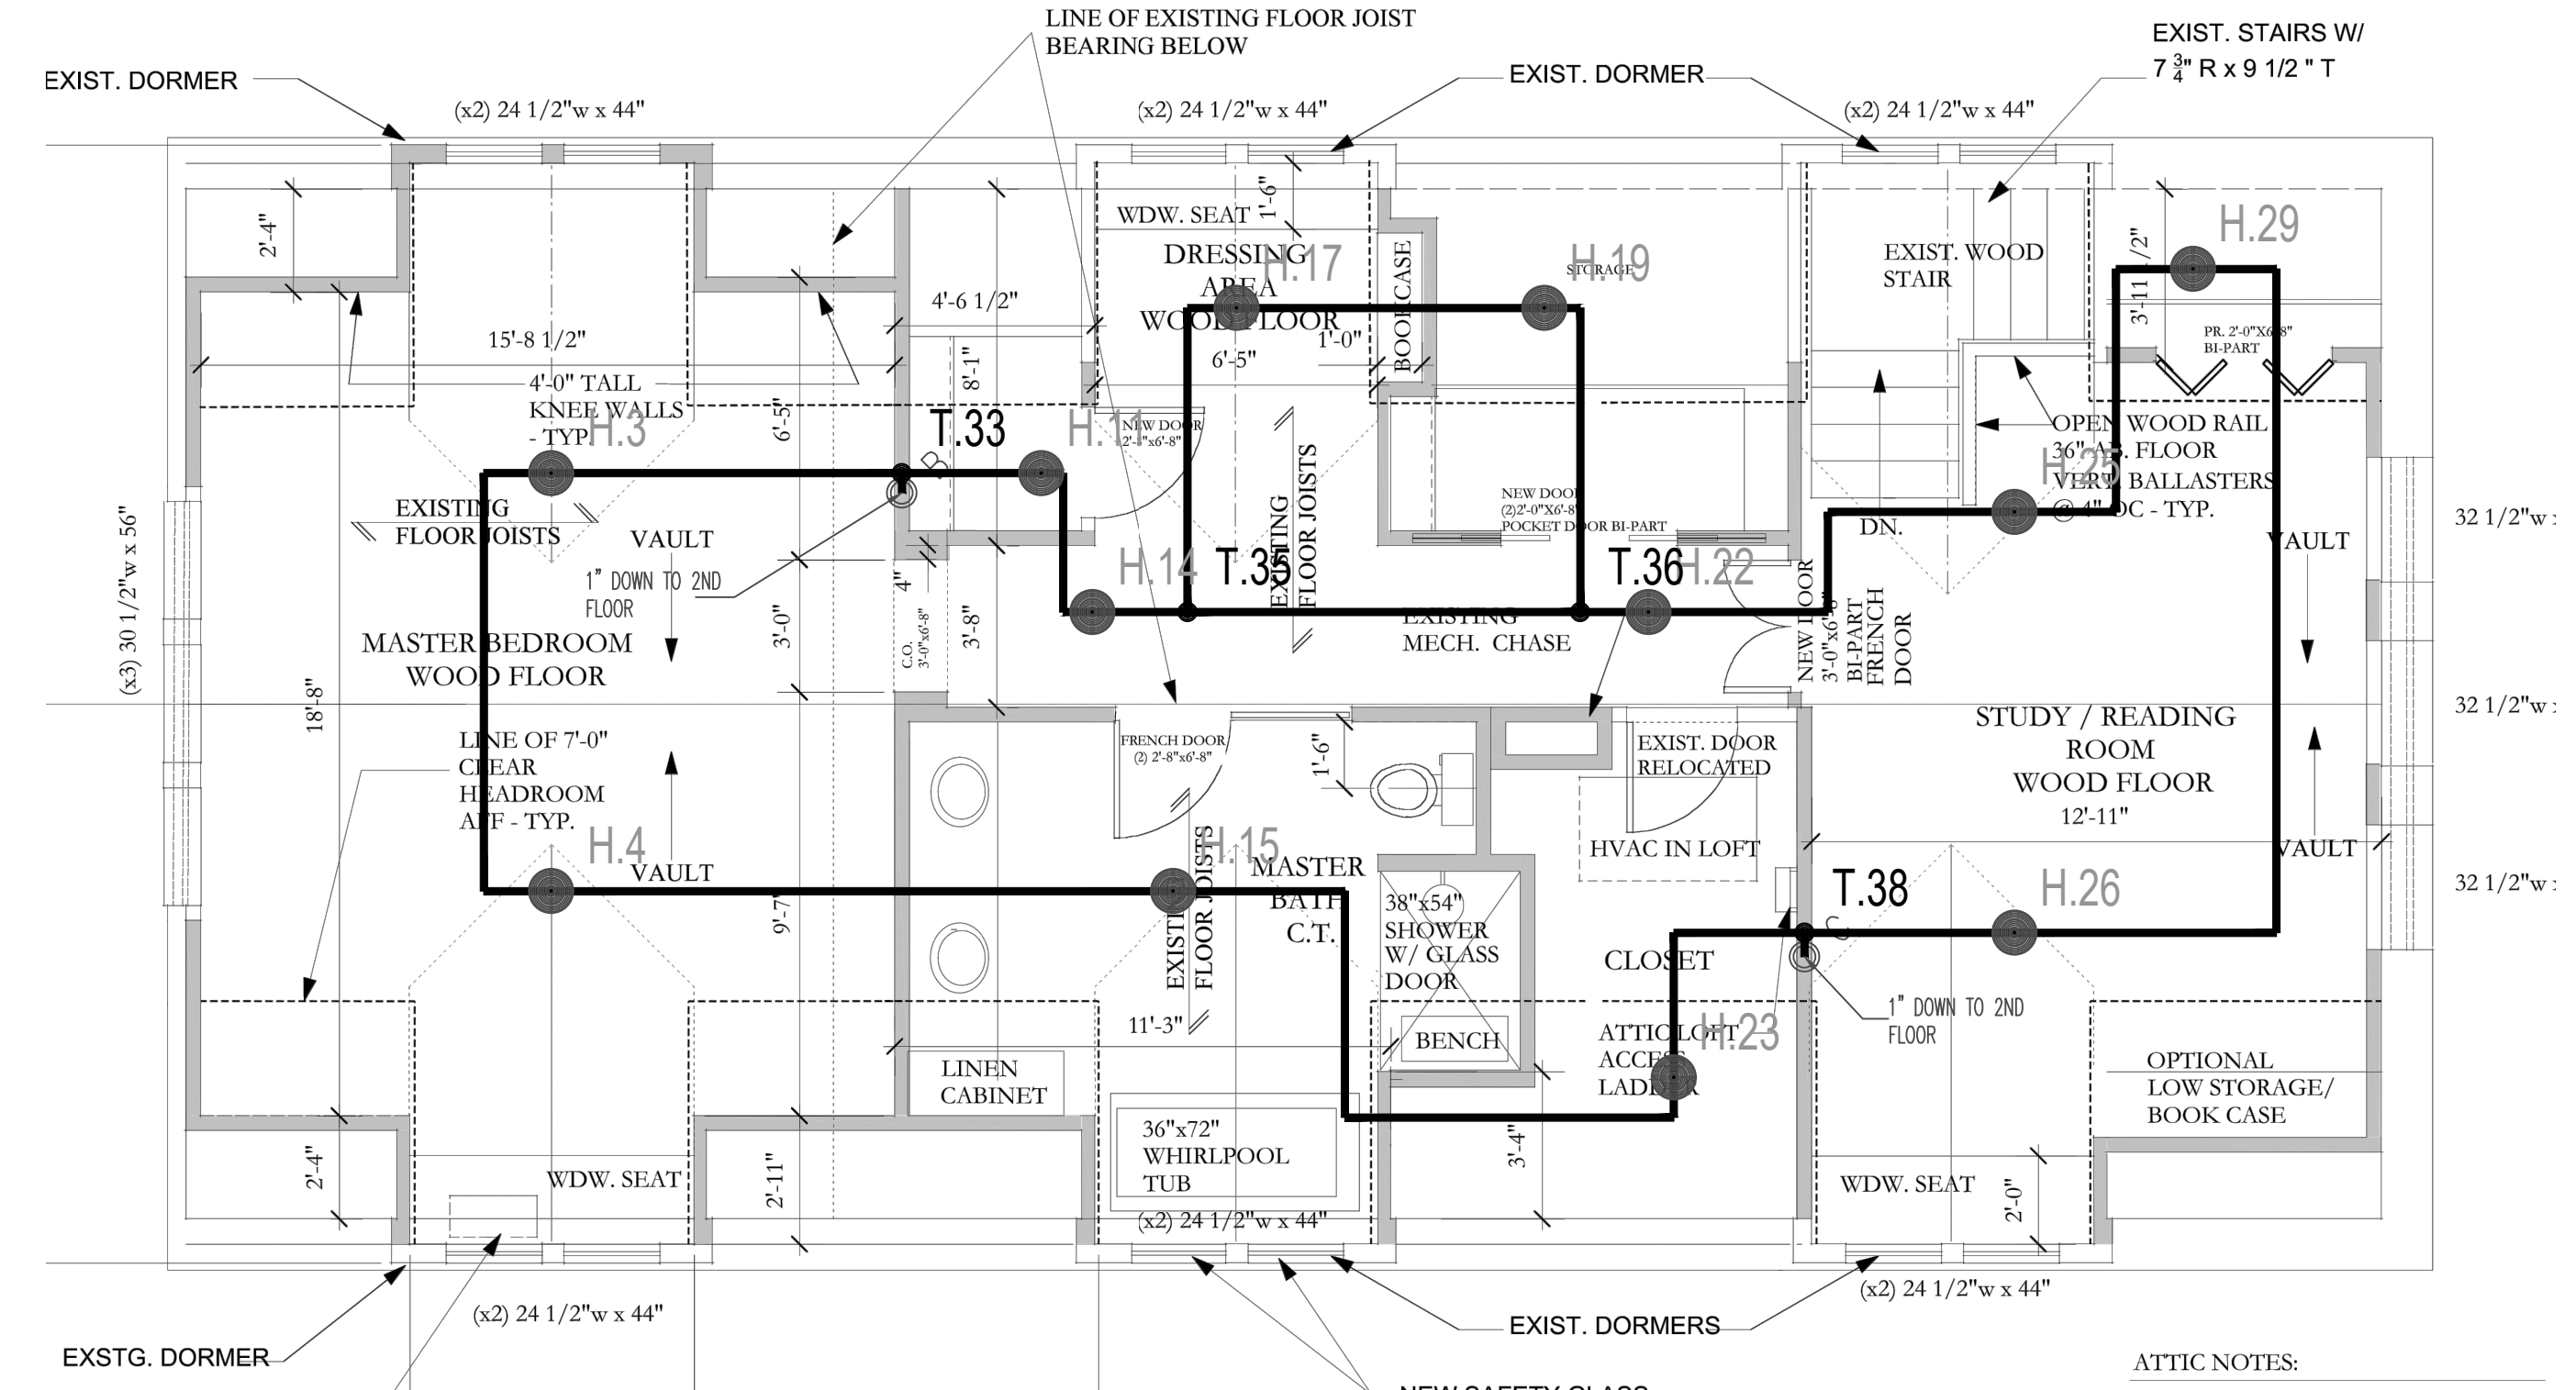




**FIRE SPRINKLER PLAN - 3RD FLOOR**  
 1/4" = 1'-0" FLOOR EL. (120'-0")

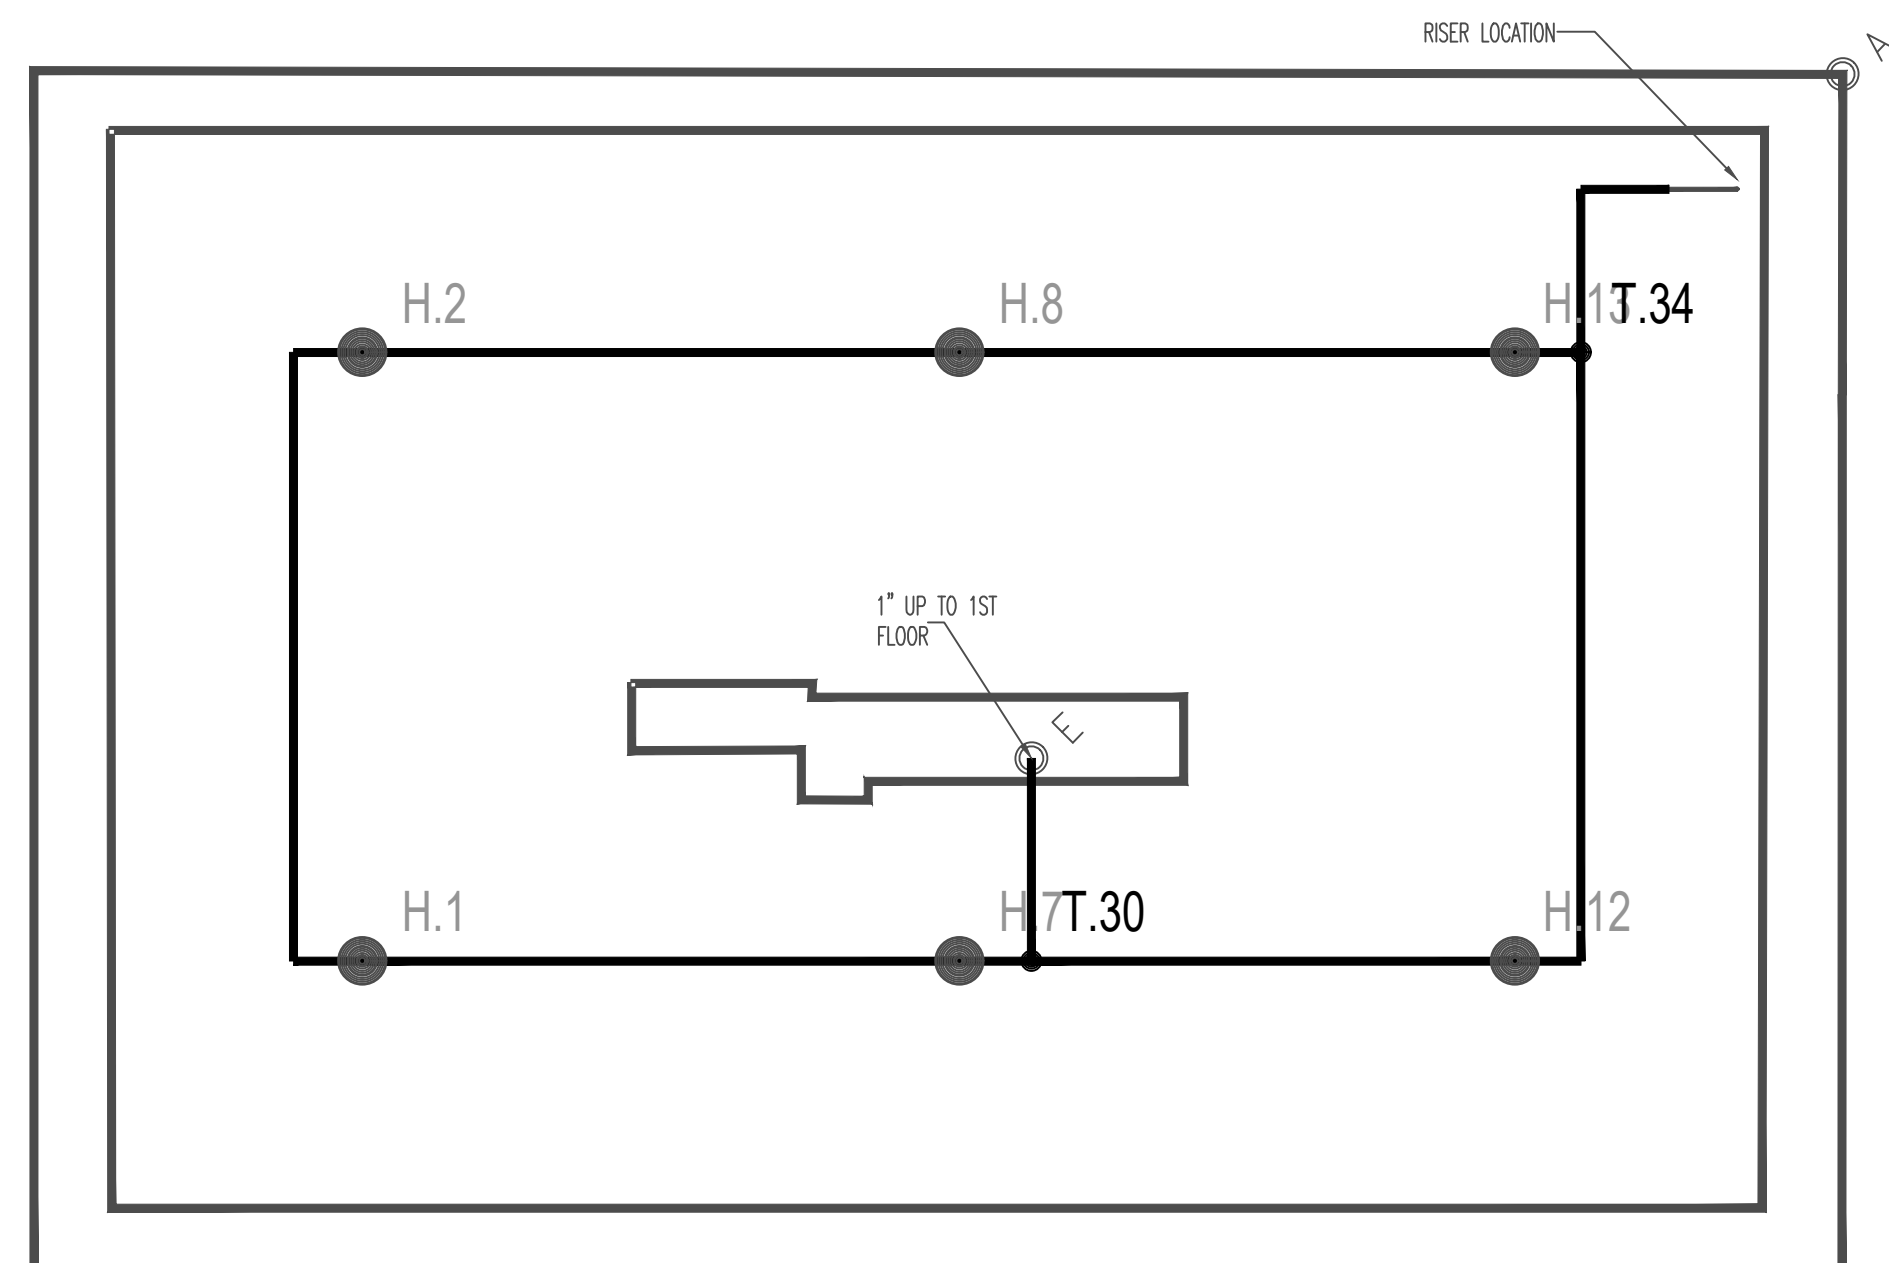

**FIRE SPRINKLER PLAN - BASEMENT**  
 1/4" = 1'-0" FLOOR EL. (90'-0")

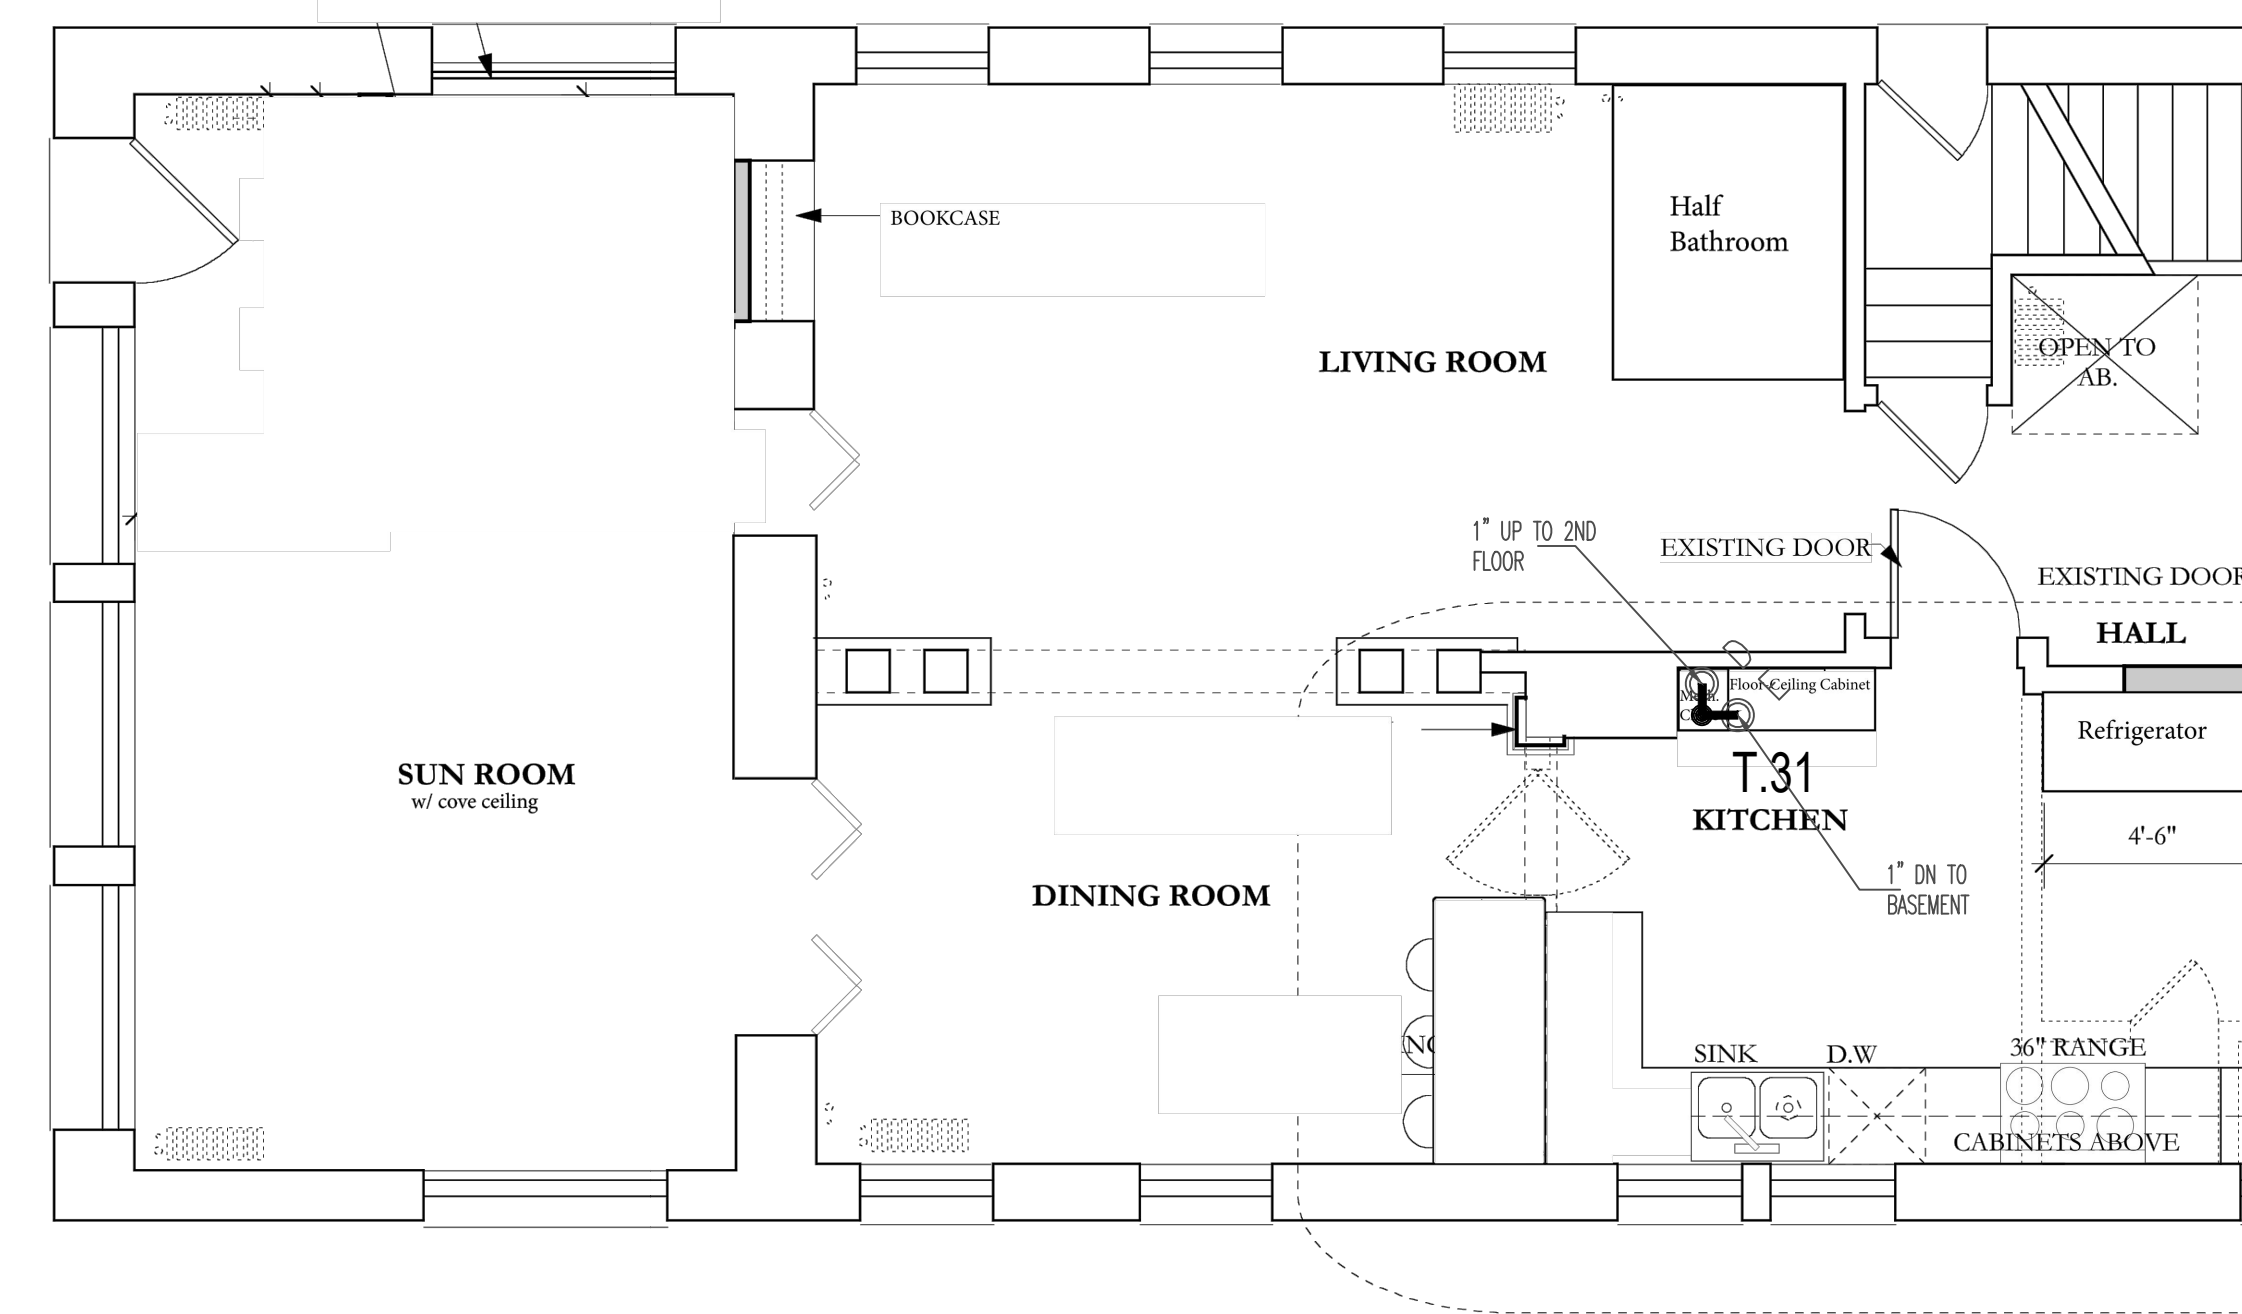

**FIRE SPRINKLER PLAN - 1ST FLOOR (NO WORK)**  
 1/4" = 1'-0" FLOOR EL. (100'-0")

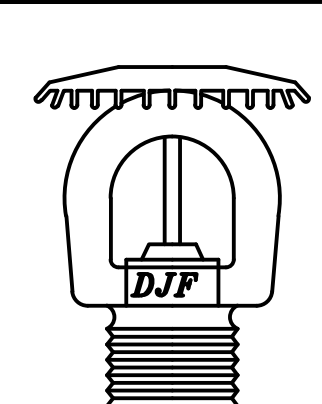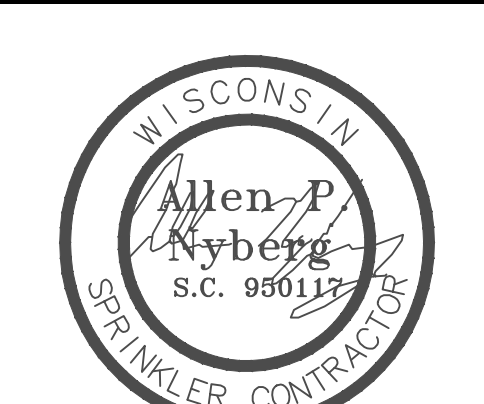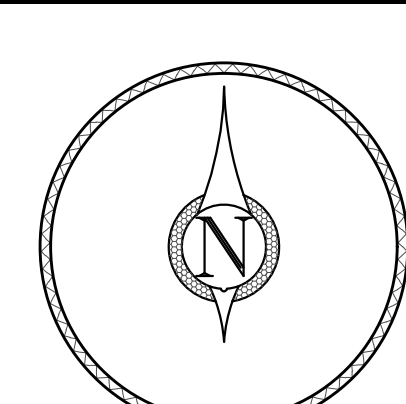

**Dave Jones**  
 PLUMBING | HEATING & COOLING | FIRE PROTECTION

Sprinklers Legend		Total This Job 29	
Total This Sheet	Description		
29	(1/2",K=4.9) RELIABLE RFD49LL 155' WHITE CONCEALED PENDENT RA3216 16"x16" SPACING		

Fire Protection		
Title	Revisions:	Date:
Contract No.		
Drawn By	NAP	
Scale	SBE PLAN	
Date	3/31/21	
Approval By	M.F.D	

Job:  
 LYTLE-PARZYCH  
 1102 SHERMAN AVE  
 MADISON, WI  
 Contractor:  
 Dave Jones Inc.  
 2225 Kilgust Road  
 Madison Wisconsin 53713