



MAIN FLOOR PLAN & LIGHTING PLAN

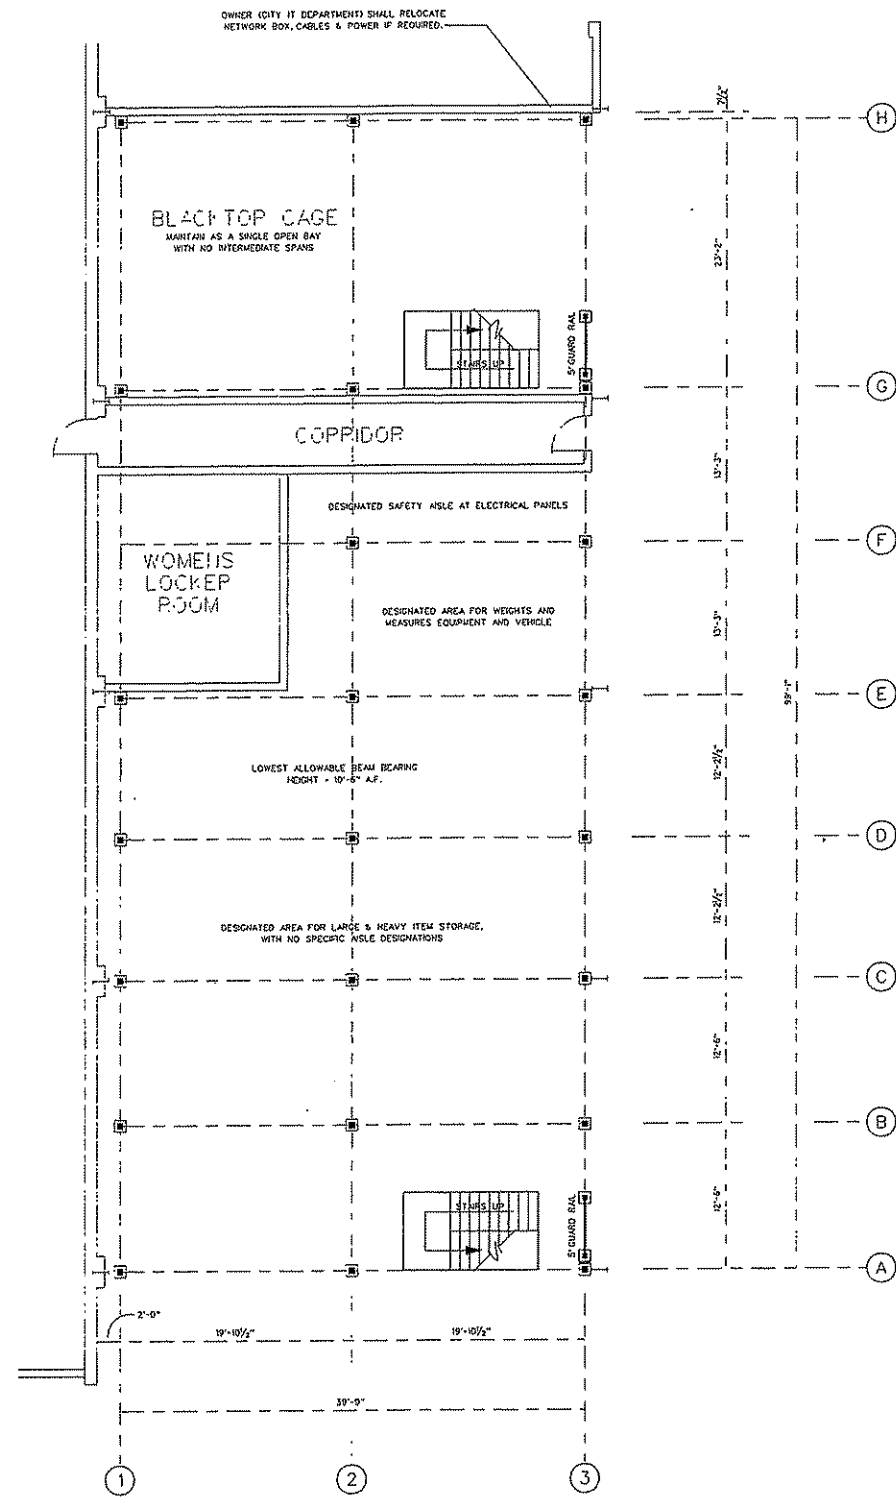

CONCEPTUAL MAIN FLOOR PLAN

SCALE: 1/16" = 1'-0"

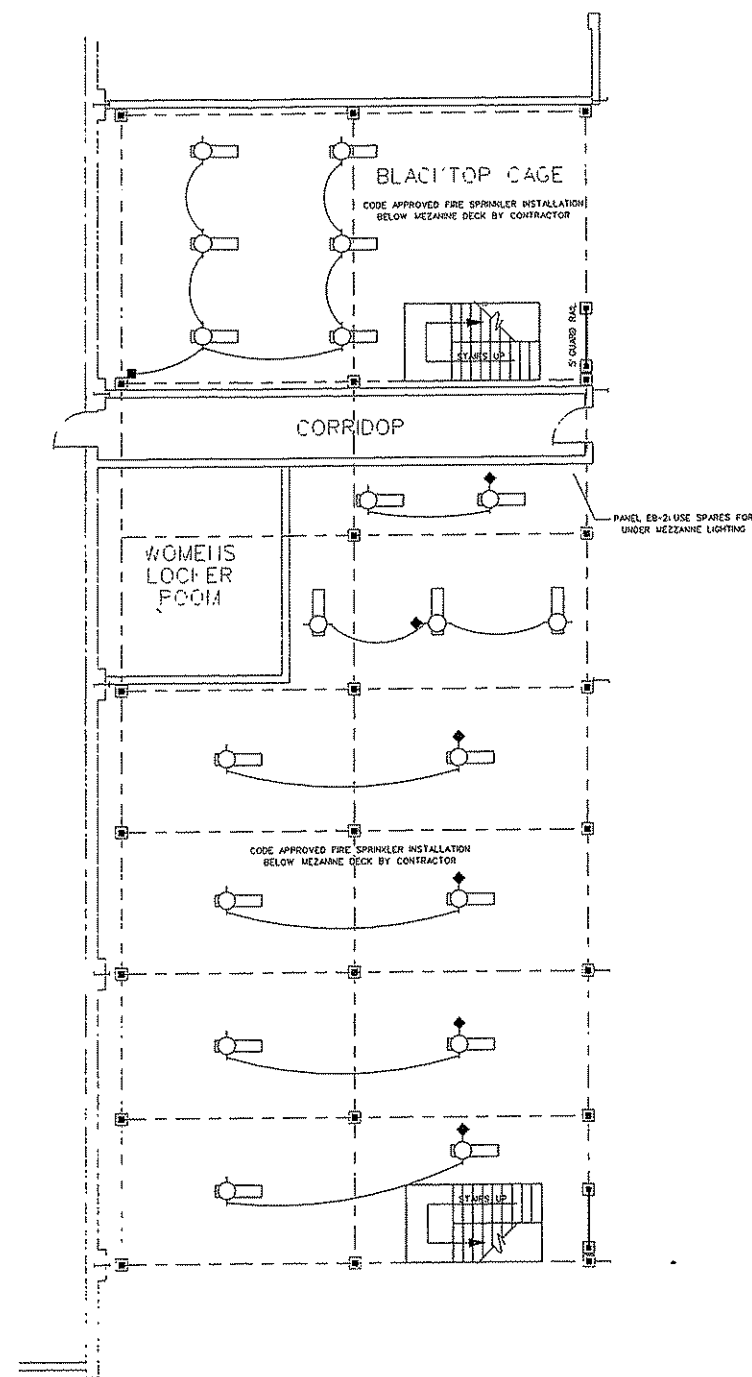

MAIN FLOOR LIGHTING PLAN

SCALE: 1/16" = 1'-0"

- MEZZANINE COLUMN AND BASE PLATE (APPROXIMATE)
- MEZZANINE BEAM CENTER LINE (APPROXIMATE)
- FLUORESCENT LIGHT FIXTURE
- FLUORESCENT FIXTURE w/ MOTION SENSOR
- ◆ MOTION SENSOR

ORIGINATOR: CITY OF MANASSAS, ENGINEERING, FACILITIES, MANAGEMENT & SUSTAINABILITY