
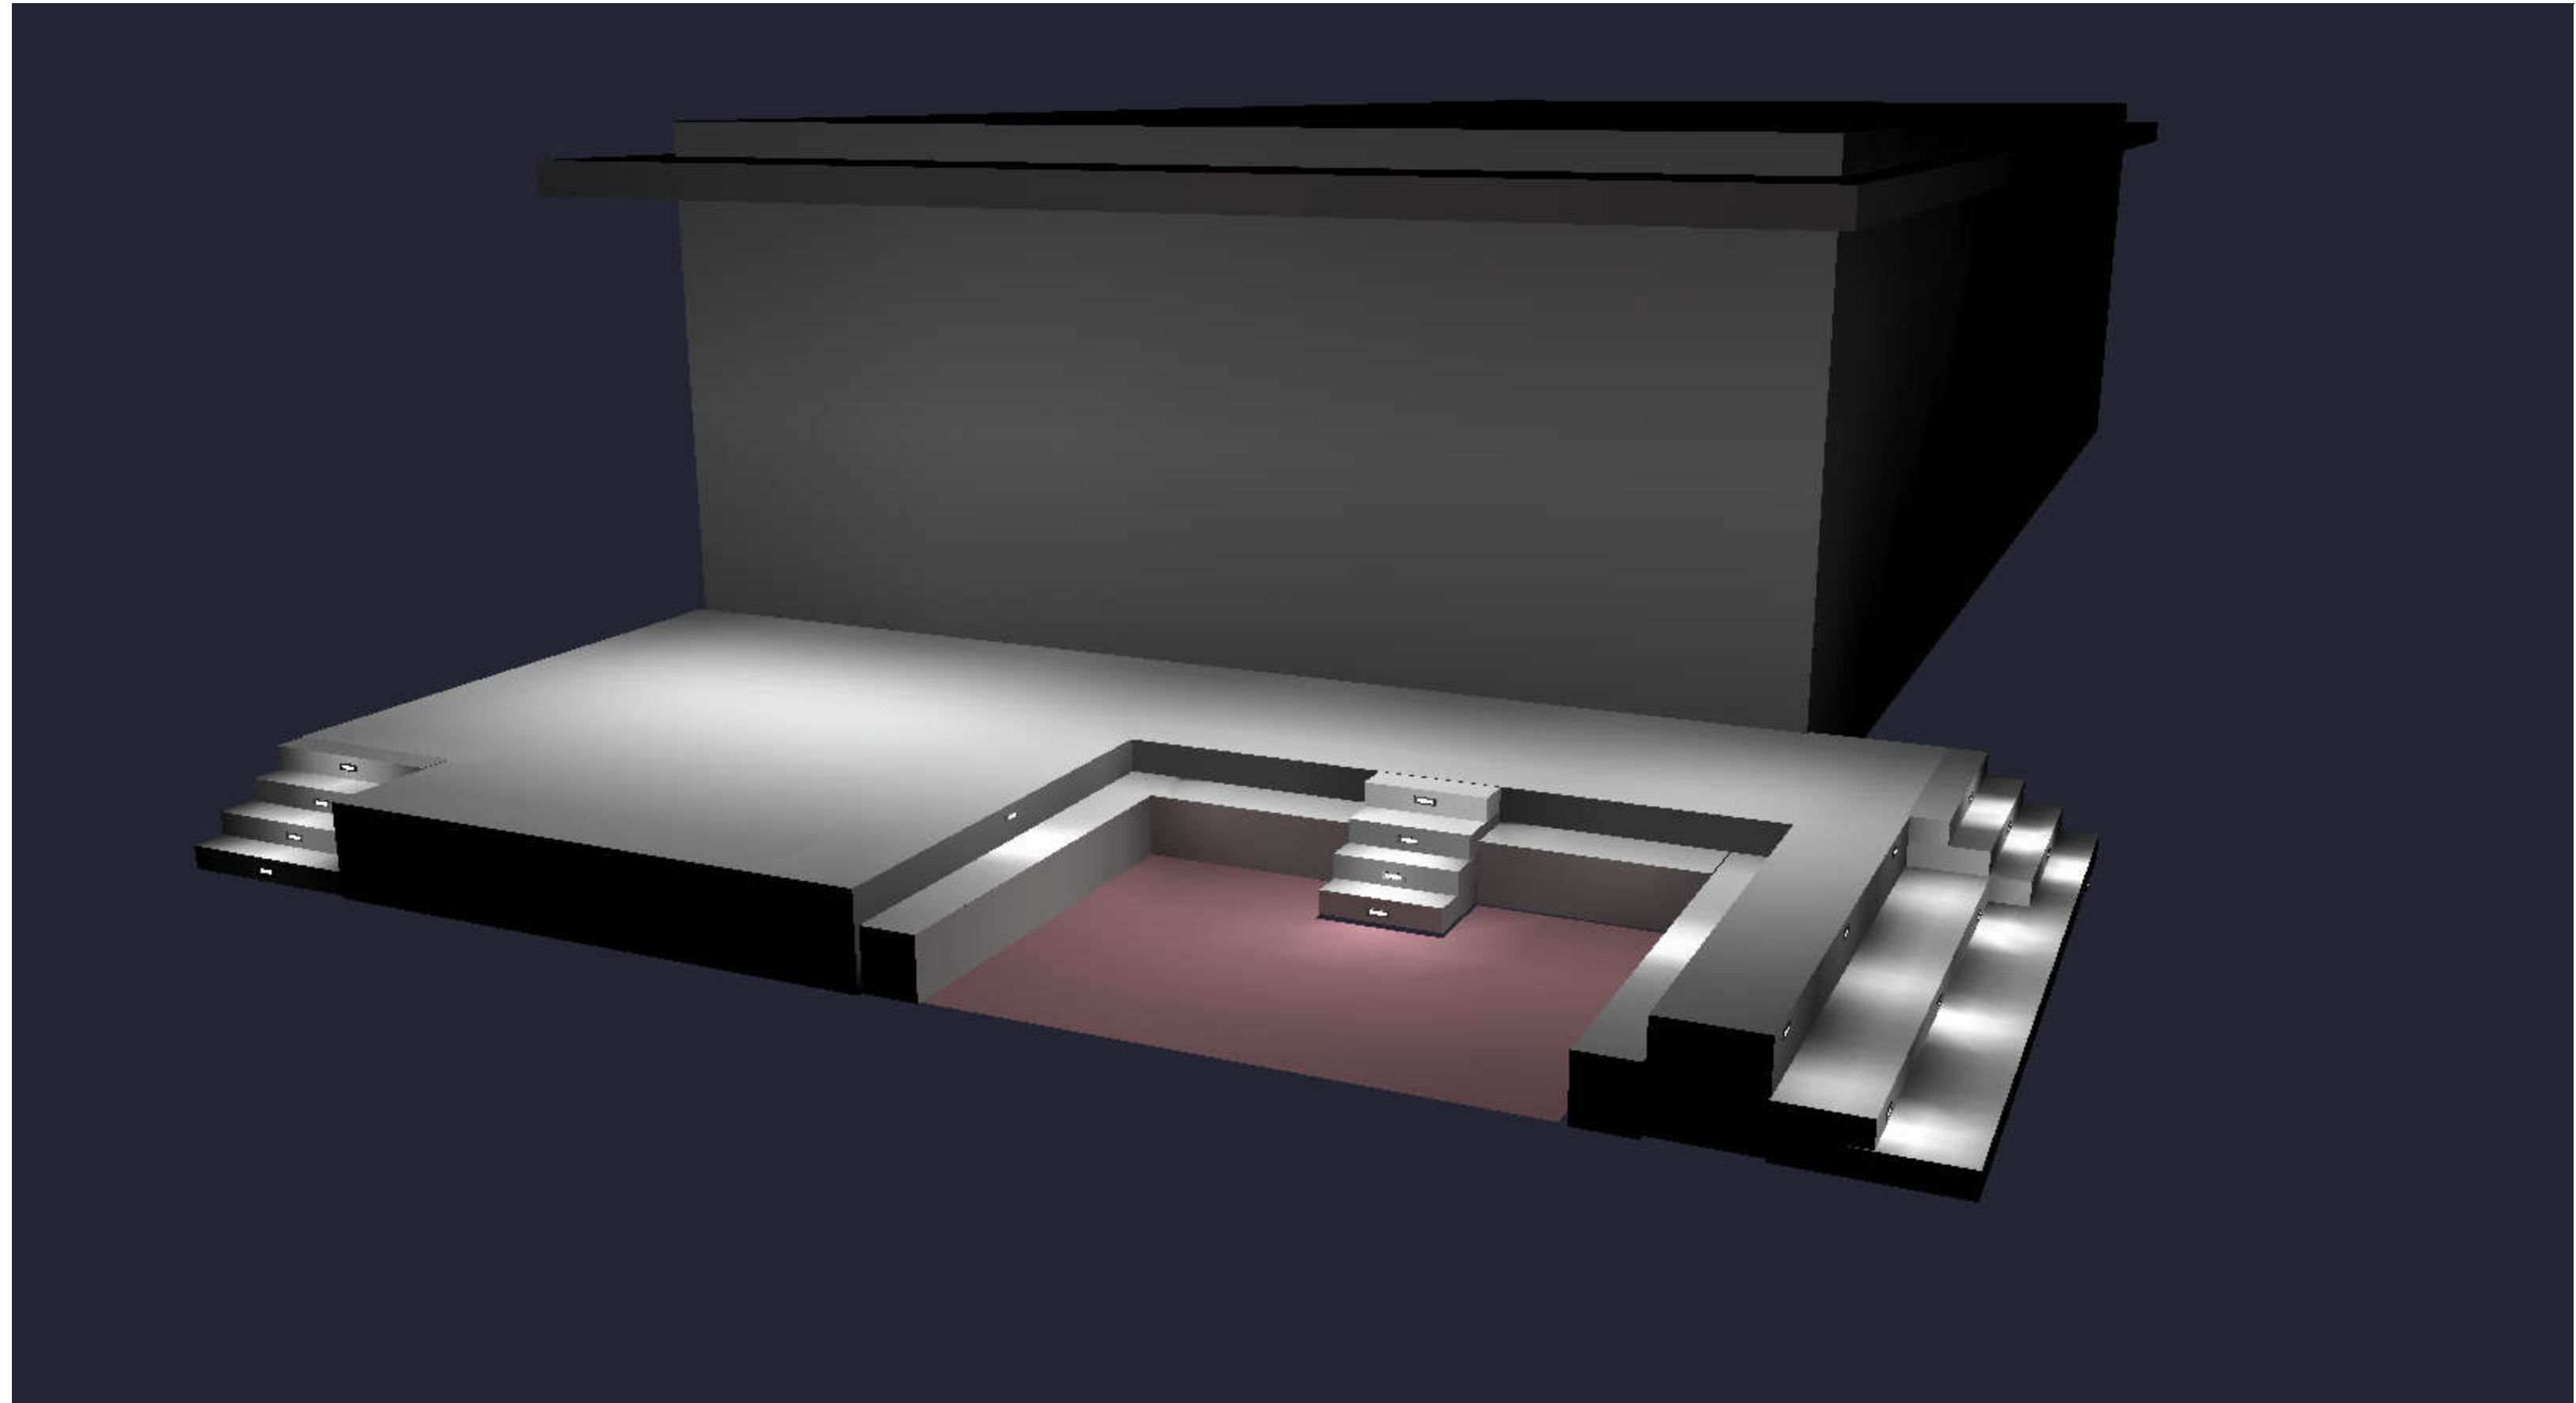


Luminaire Schedule					
Qty	Label	MFG	Description	Lum. Watts	Total Watts
4	D1	LITELINE	RA4-12RG-90-xxK-(driver)-(finish)	12	48
20	W1	COLE	L503W (finish) (glass) (dim) xxK	1.5	30

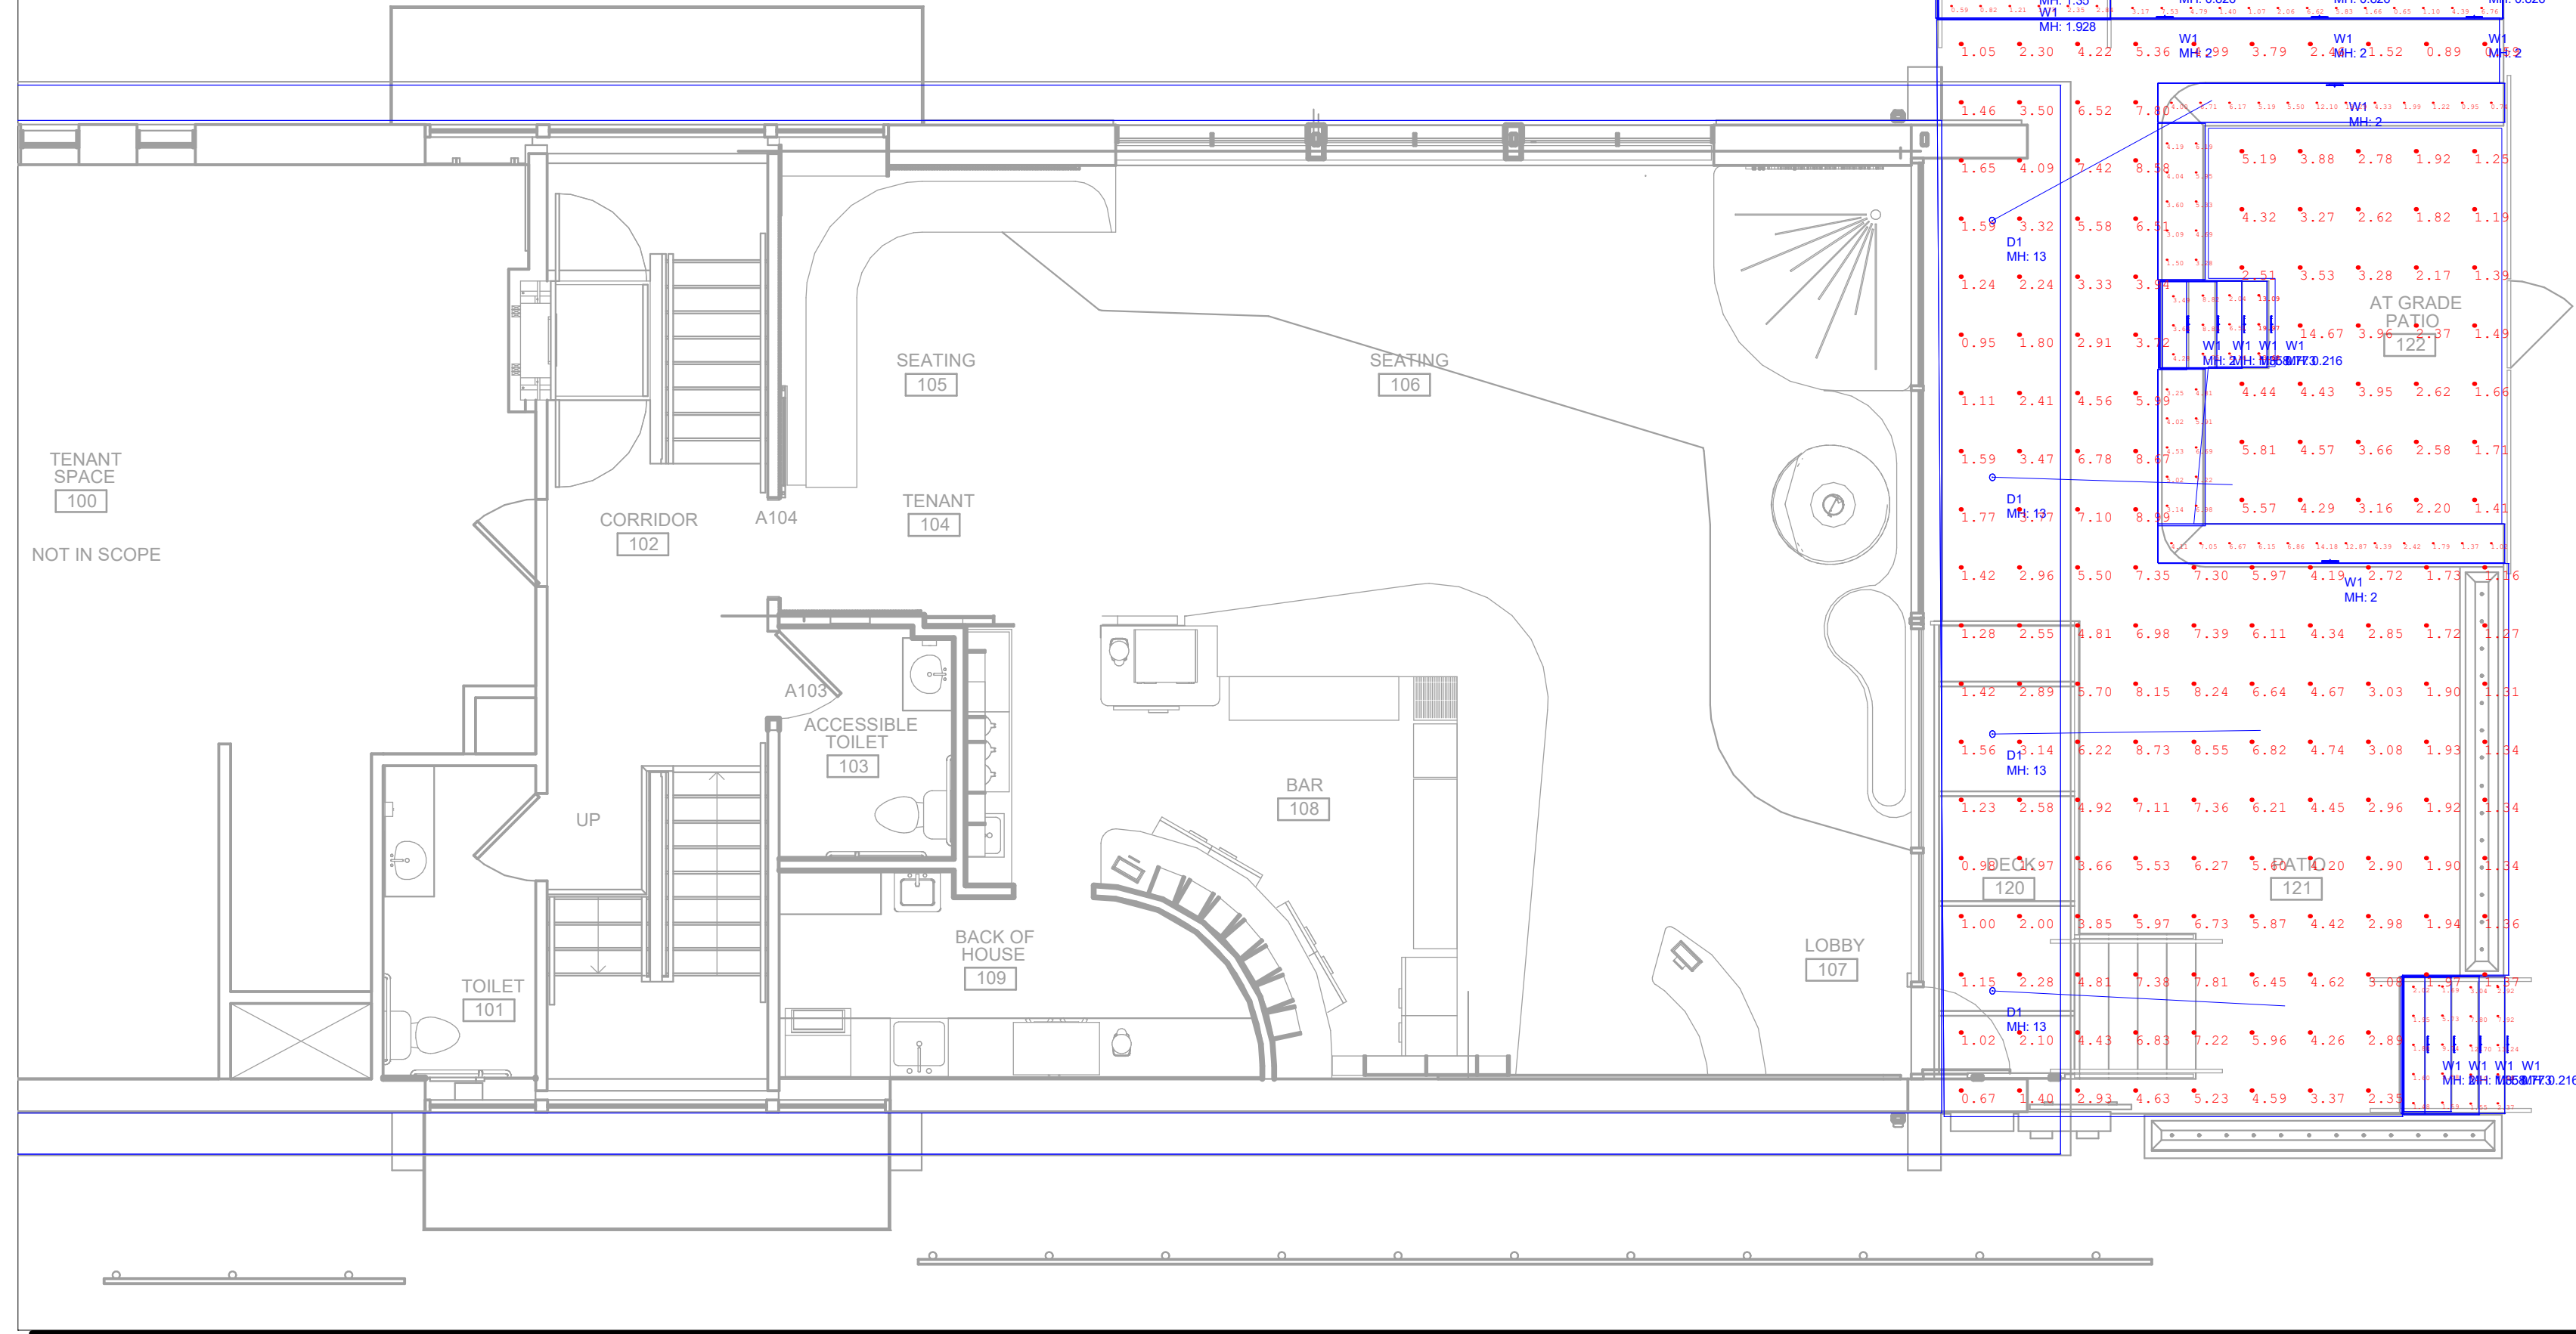

#	Date	Comments

Drawn By: JT
Date: 9/23/2022
Scale: NOT TO SCALE

THE INTERNATIONAL
MADISON, WI

PATITION LIGHTING LAYOUT REV1