


# EXHIBIT A

(page 1 of 2)

## Location Map

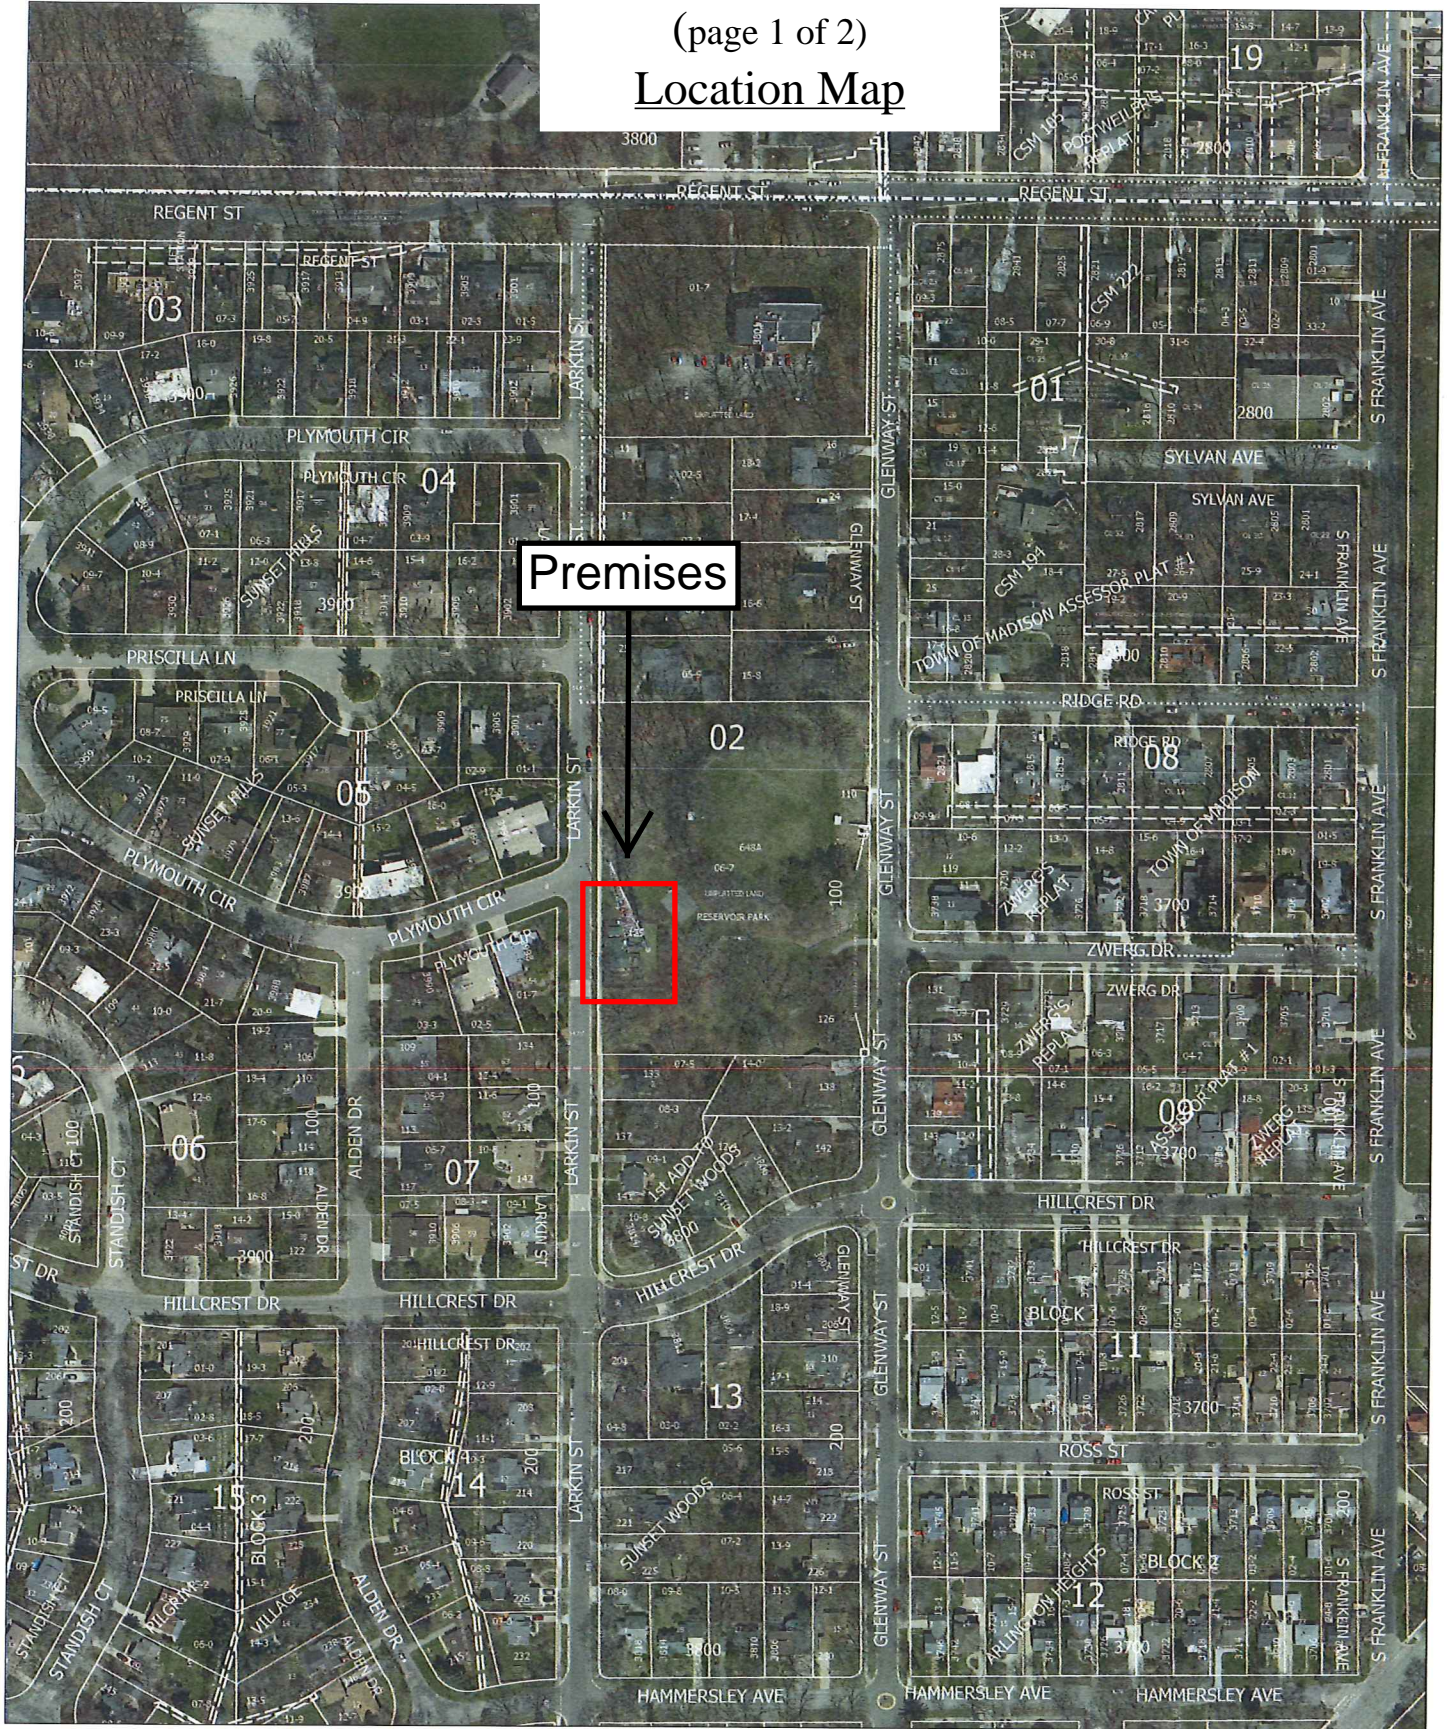

Time: 7/11/2017 9:32:40 AM

Session: C:\Users\remgl\Desktop\GT Viewer.gts

City of Madison, WI - GIS/Mapping data

Printed By: remgl

Disclaimer: The City makes no representation about the accuracy of these records and shall not be liable for any damages




# EXHIBIT A

(page 2 of 2)

## Site Plan




LARKIN STREET

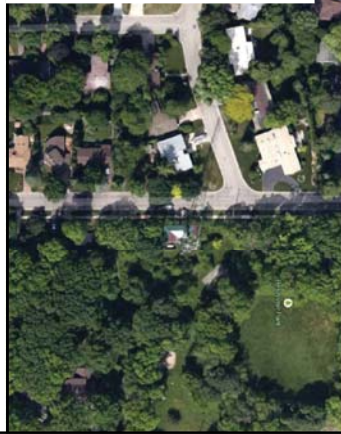

AERIAL OVERVIEW OF SITE



SITE OVERVIEW  
[LOOKING NORTHWEST]

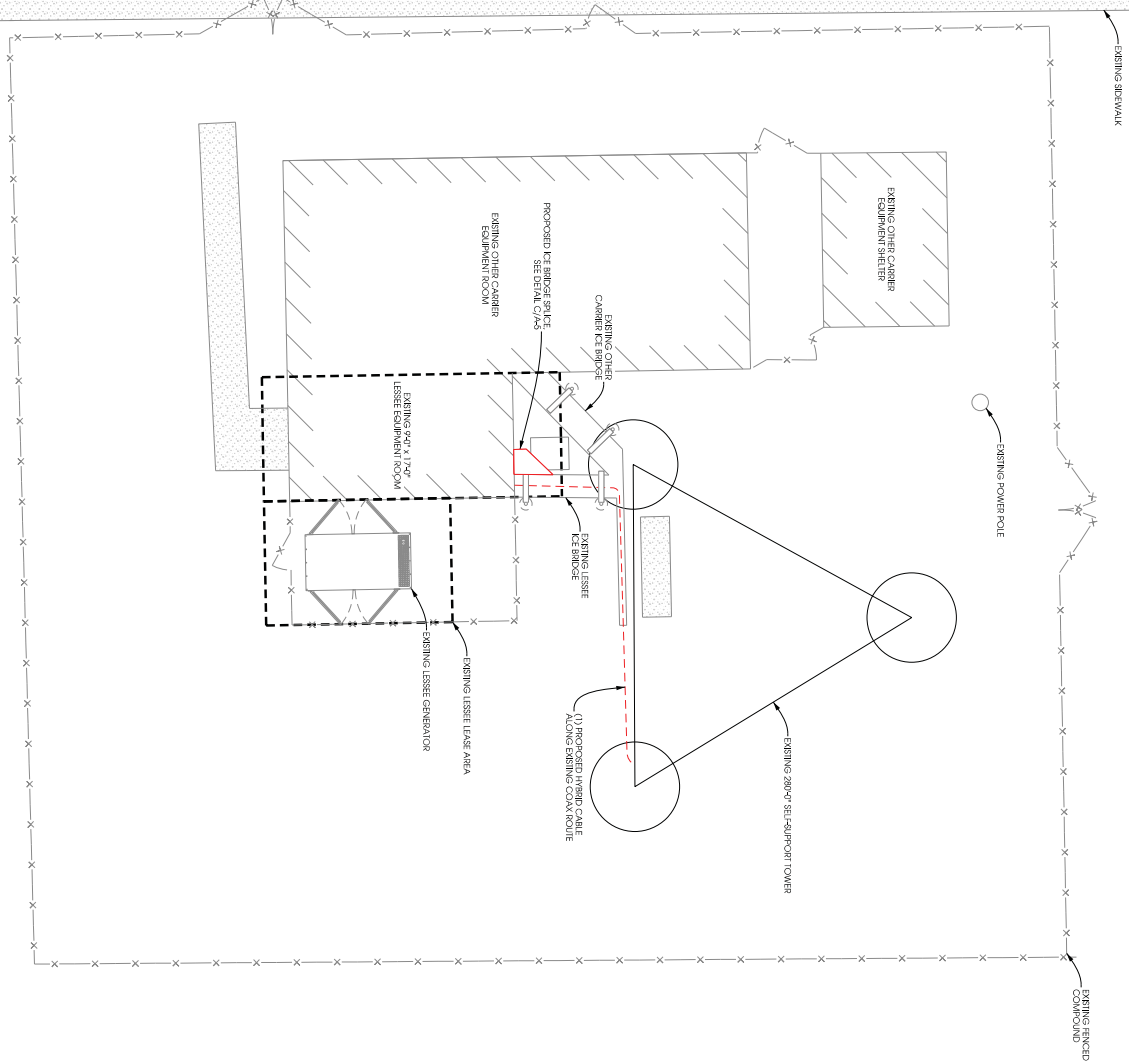

NOTE:  
NO NEW SURVEY COMPLETED OR PROVIDED.  
SITE LAYOUT BASED ON PREVIOUS SURVEY.  
FIELD CONDITIONS MAY VARY FROM DRAWING.

SCALE:  
1" = 10' - 0"  
1/4" = 1' - 0"  
1/8" = 6" - 0"

PROJECT NO:	12000A/CAD/1147/PCS Antenna MCDs Phase 3/C-1.dgn
DATE:	
DRAWN BY:	
CHECKED BY:	
DATE:	
FLOOR DATE:	
PROJECT #:	12000
CLIENT:	
SHEET NUMBER:	C-1

SHEET TITLE:  
**COMPOUND PLAN  
LARKIN STREET [113482]  
MADISON, WISCONSIN**

**Edge**  
Consulting Engineers, Inc.  
624 Water Street  
Fitchelle du Sac, WI 53578  
608.644.1449 voice  
608.644.1549 fax  
www.edgeconsult.com