


849 E Washington Ave – Bakers Place

Project Location Project Number: 13769

Contract Number: 9072

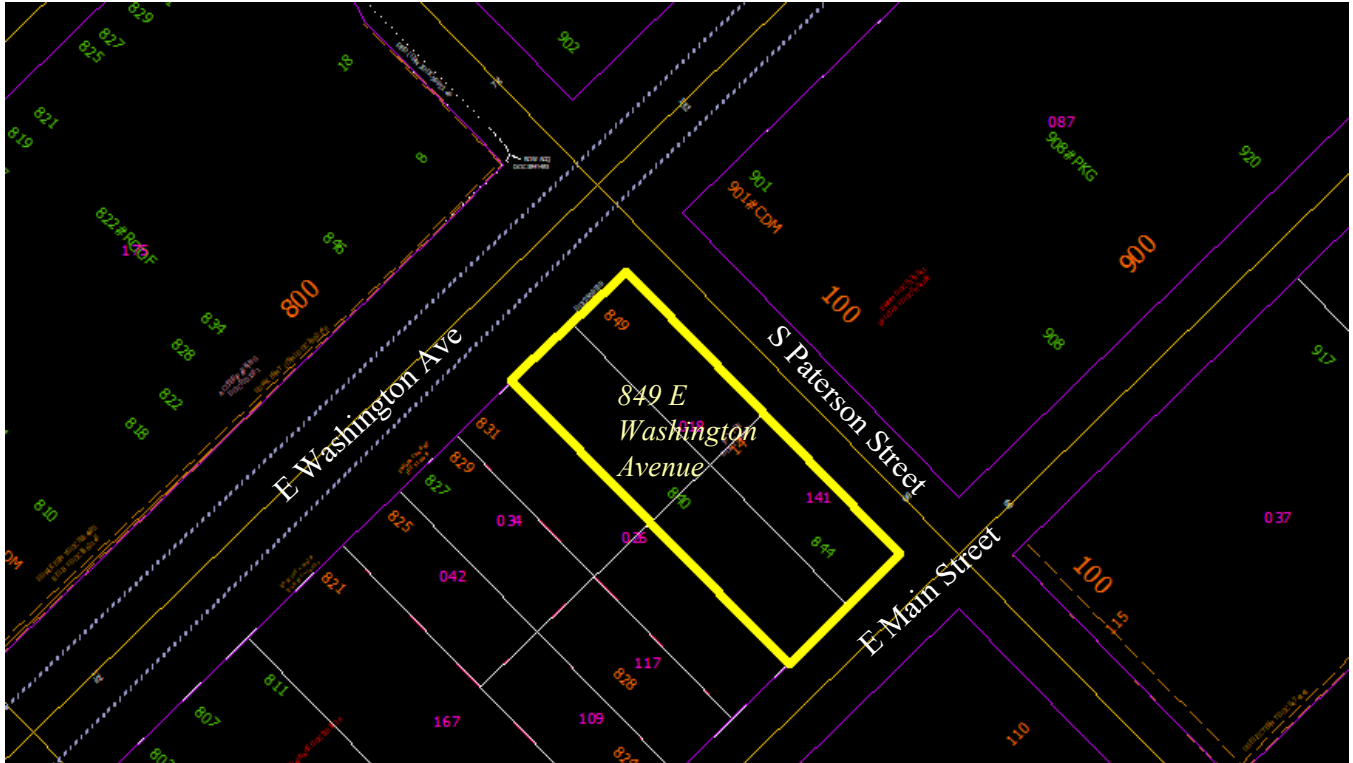

Sidewalk and restoration work as required
Lateral connections (sanitary, sewer, water)
Upsize 97' of sanitary sewer to 12" in S Paterson Street



CALL TOLL FREE 1-800-242-8511
MILWAUKEE AREA 414-259-1181
FAX A LOCATE 1-800-338-3860
TDD (HEARING IMPAIRED) 1-800-542-2289
ONLINE: www.DlggersHotline.com

SITE LINE LEGEND	
	PROPERTY LINE
	SETBACK LINE
	EASEMENT LINE
	EXISTING IMPERMEABLE CONTOUR
	EXISTING DRAINAGE CONTOUR
	NEW IMPERMEABLE CONTOUR
	NEW DRAINAGE CONTOUR
	EASEMENT
	FENCE
	STORM DRAIN
	SANITARY SEWER
	WATER
	GAS
	ELECTRICAL POWER
	UNDERGROUND ELECTRICAL POWER
	UNDERFOULDED TREES OPTIC
	TELEPHONE
	UNDERGROUD TELEPHONE
	CABLE
	EDGE OF TREE OR SHrubS

NOTE: ALL LINE TYPES MAY NOT BE USED IN THIS SET

KEYNOTES

- 1 NEW OF PVC SANITARY LATERAL, PROPOSED TO BE INSTALLED IN FRONT PROTECTIVE SLOPE DETAIL, VERIFY CONNECTION TO EXISTING SANITARY MANHOLE, FIELD VERIFY DEPTHS OF PIPE CROSSINGS.
- 2 NEW GAS LATERAL, COORDINATE WITH M&E
- 3 NEW UNDERGROUND POWER TO VALVE, IN LOWER LEVEL, COORDINATE WITH M&E
- 4 NEW COMBINED SEWER AND PIPE PROTECTIVE WATER SERVICE AND VALVE
- 5 REPLACE EXISTING OF SANITARY SEWER WITH NEW OF SANITARY SEWER AT SAME DEPTHS.
- 6 NEW WATER SERVICE AND VALVE TO EXISTING BUILDING, FIELD VERIFY ENTRANCE
- 7 NEW BURIED UNDERGROUND POWER BY M&E, FIELD VERIFY
- 8 NEW STORM ROOF DRAIN, TYP.
- 9 NEW STORM SEWER CONNECTION TO EXISTING STORM STRUCTURE, FIELD VERIFY

SITE UTILITY PLAN GENERAL NOTES

- [illegible]

THE NEUTRAL
PROJECT

BAKERS PLACE
DEVELOPMENT

10 S. PATERSON
MADISON, WI 53703

[illegible]

Due to electronic distribution, this drawing
not be printed to the scale indicated on the
drawings. Do NOT use scale to determine
dimensions or sizes.

No part of this drawing may be used or reproduced in any form or by any means, or stored in a database or retrieval system.

ANGUS-YOUNG ASSOCIATES, INC.
Copyright © 2021 All Rights Reserved

PROJECT NUMBER	71420
----------------	-------

APPROVED BY
IAD

REVIEWED BY

JAD

DRAWN BY

KAU
SITE UTILITY PLAN

C401

C401

C401

PRELIMINARY - NOT FOR CONSTRUCTION

SCALE: 1"=100'-0"

doi:10.1371/journal.pone.0142099.g001

PLOTTED BY: kcp/ps

COVER, SEE 24 x 16"