



PREPARED FOR:
 JOE MARTINO
 26 N. HANCOCK ST.
 MADISON, WI 53703

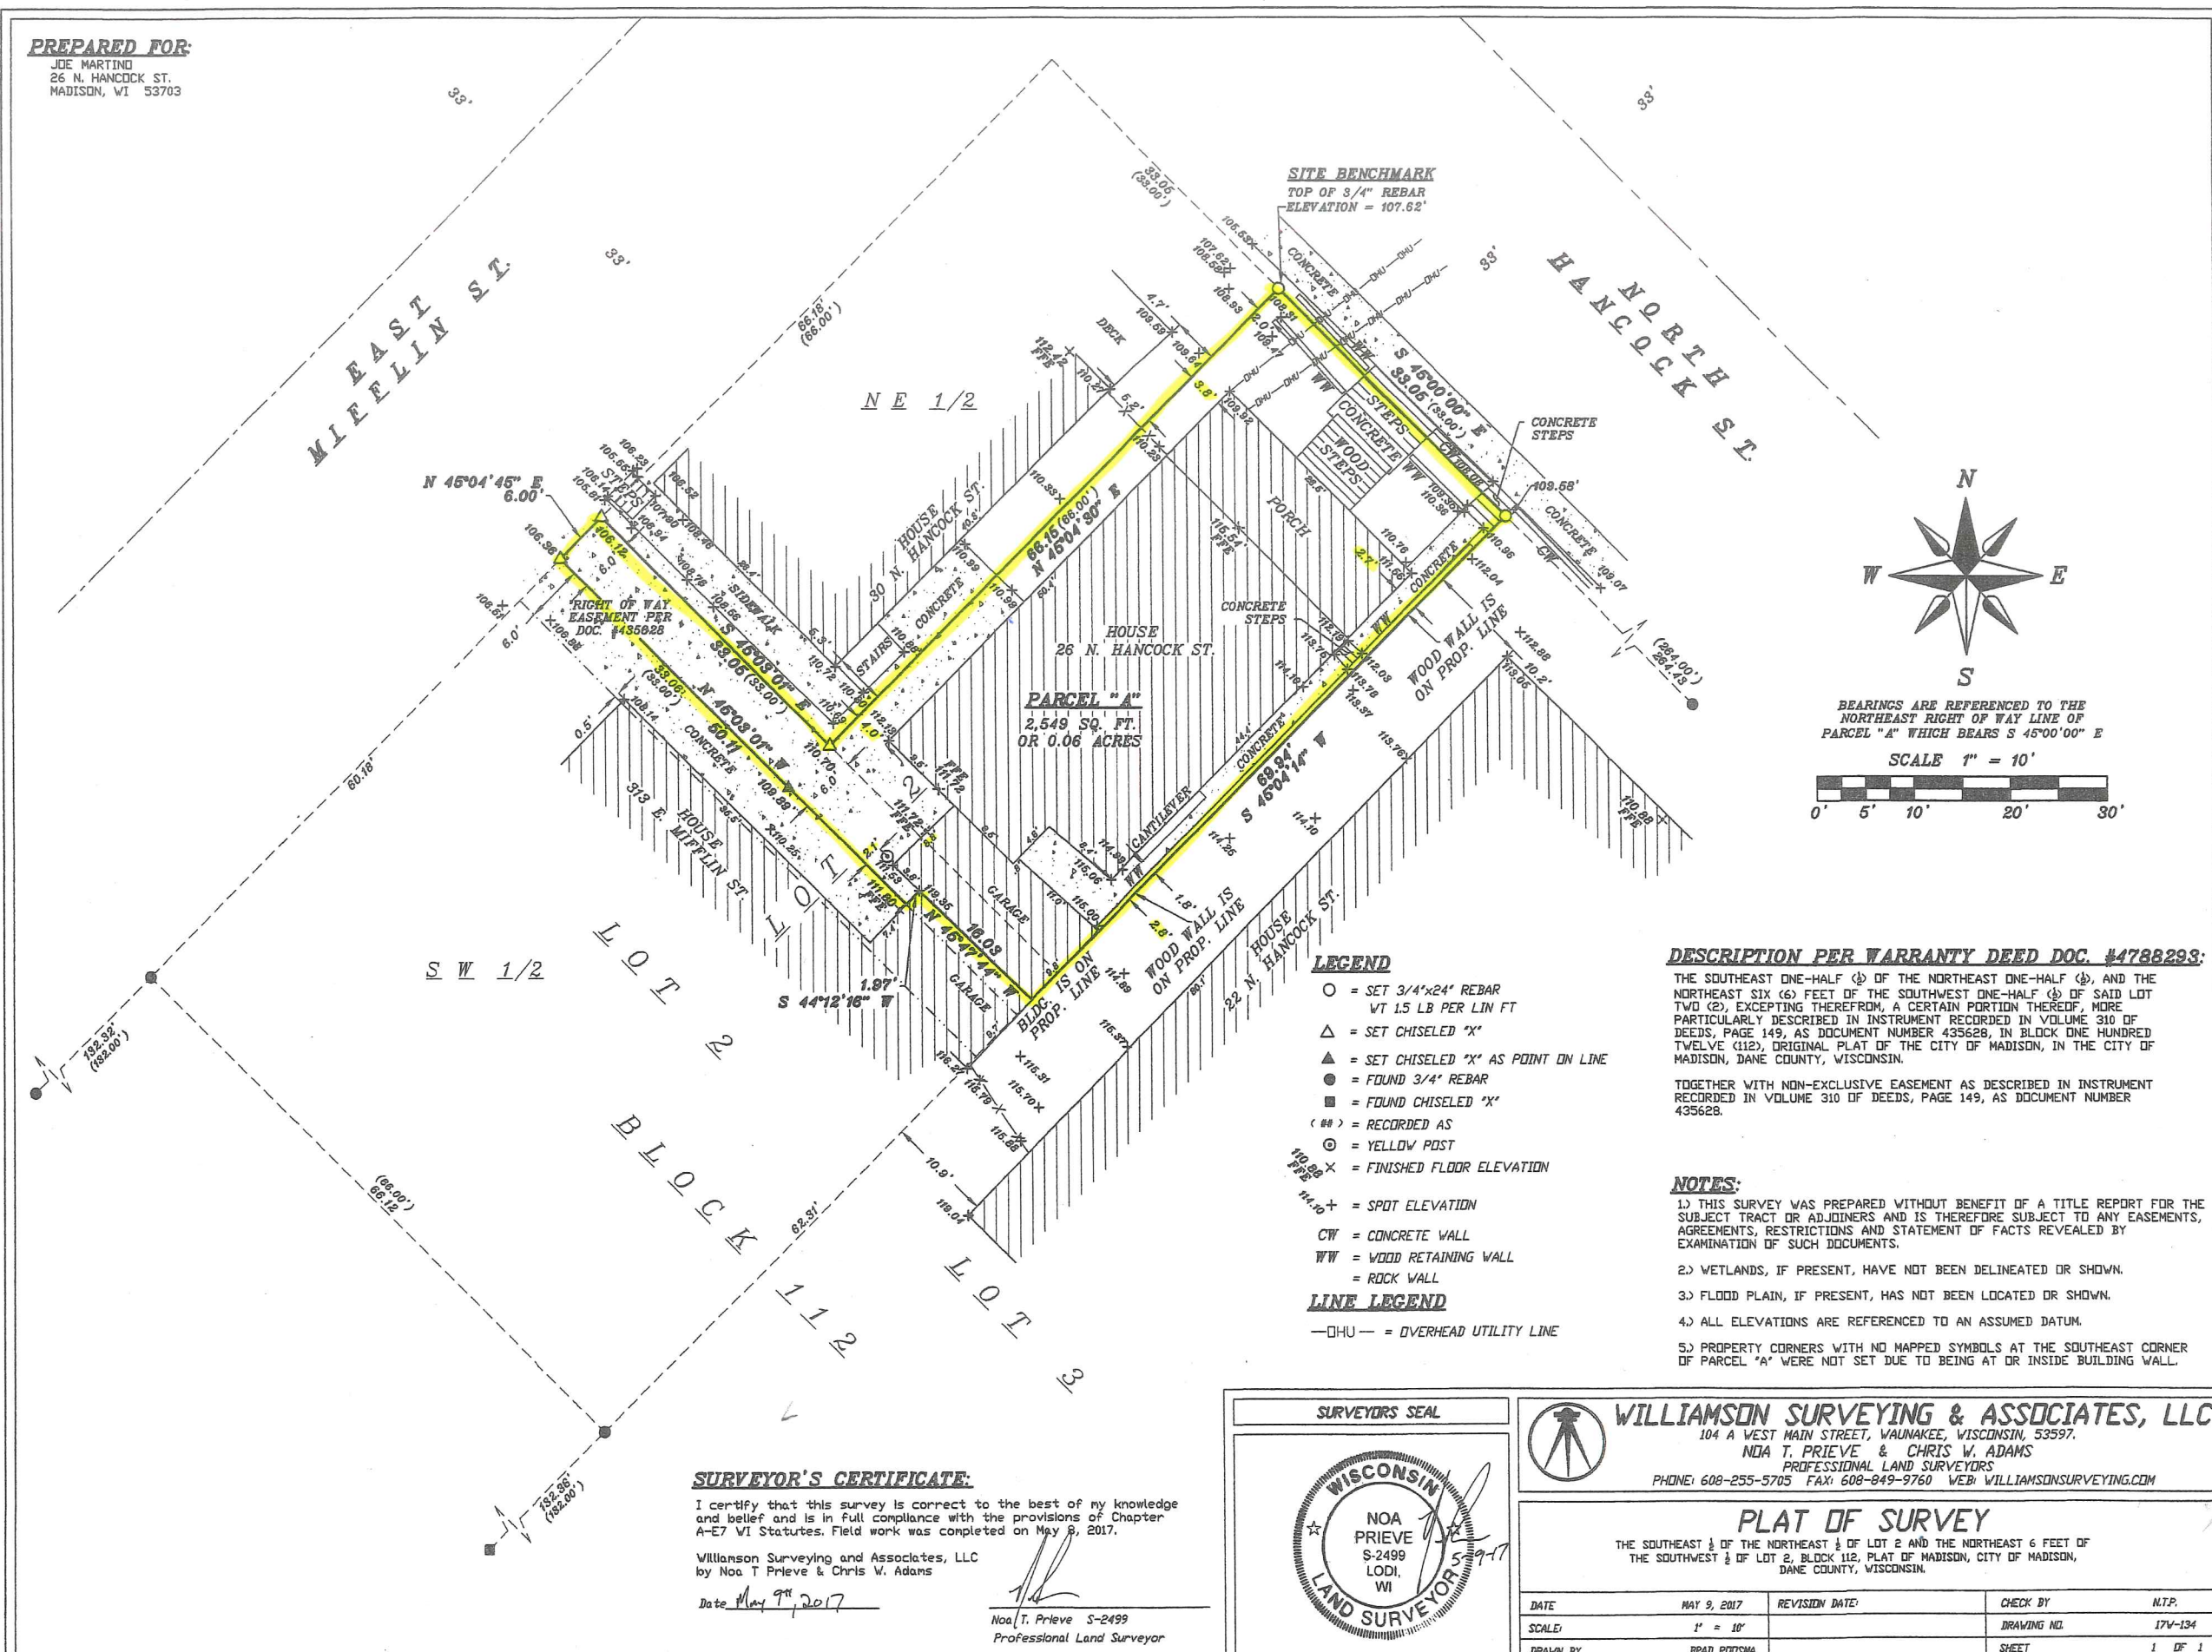

PARCEL "A"
 2,549 SQ. FT.
 OR 0.06 ACRES

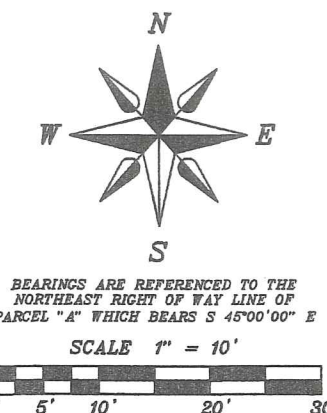

- LEGEND**
- = SET 3/4"x24" REBAR
WT 1.5 LB PER LIN FT
 - △ = SET CHISELED "X"
 - ▲ = SET CHISELED "X" AS POINT ON LINE
 - = FOUND 3/4" REBAR
 - = FOUND CHISELED "X"
 - <##> = RECORDED AS
 - ⊙ = YELLOW POST
 - × = FINISHED FLOOR ELEVATION
 - + = SPOT ELEVATION
 - CW = CONCRETE WALL
 - WW = WOOD RETAINING WALL
 - = ROCK WALL
- LINE LEGEND**
- OHU- = OVERHEAD UTILITY LINE

DESCRIPTION PER WARRANTY DEED DOC. #4788293:

THE SOUTHEAST ONE-HALF (½) OF THE NORTHEAST ONE-HALF (½), AND THE NORTHEAST SIX (6) FEET OF THE SOUTHWEST ONE-HALF (½) OF SAID LOT TWO (2), EXCEPTING THEREFROM, A CERTAIN PORTION THEREOF, MORE PARTICULARLY DESCRIBED IN INSTRUMENT RECORDED IN VOLUME 310 OF DEEDS, PAGE 149, AS DOCUMENT NUMBER 435628, IN BLOCK ONE HUNDRED TWELVE (112), ORIGINAL PLAT OF THE CITY OF MADISON, IN THE CITY OF MADISON, DANE COUNTY, WISCONSIN.

TOGETHER WITH NON-EXCLUSIVE EASEMENT AS DESCRIBED IN INSTRUMENT RECORDED IN VOLUME 310 OF DEEDS, PAGE 149, AS DOCUMENT NUMBER 435628.

NOTES:

- 1.) THIS SURVEY WAS PREPARED WITHOUT BENEFIT OF A TITLE REPORT FOR THE SUBJECT TRACT OR ADJOINERS AND IS THEREFORE SUBJECT TO ANY EASEMENTS, AGREEMENTS, RESTRICTIONS AND STATEMENT OF FACTS REVEALED BY EXAMINATION OF SUCH DOCUMENTS.
- 2.) WETLANDS, IF PRESENT, HAVE NOT BEEN DELINEATED OR SHOWN.
- 3.) FLOOD PLAIN, IF PRESENT, HAS NOT BEEN LOCATED OR SHOWN.
- 4.) ALL ELEVATIONS ARE REFERENCED TO AN ASSUMED DATUM.
- 5.) PROPERTY CORNERS WITH NO MAPPED SYMBOLS AT THE SOUTHEAST CORNER OF PARCEL "A" WERE NOT SET DUE TO BEING AT OR INSIDE BUILDING WALL.


SURVEYOR'S CERTIFICATE:

I certify that this survey is correct to the best of my knowledge and belief and is in full compliance with the provisions of Chapter A-E7 VI Statutes. Field work was completed on May 8, 2017.

Williamson Surveying and Associates, LLC
 by Noa T. Prievé & Chris W. Adams

Date May 9th, 2017

Noa T. Prievé
 Noa T. Prievé S-2499
 Professional Land Surveyor

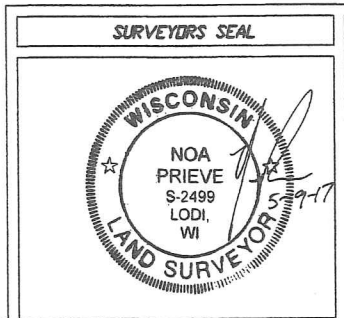


SURVEYORS SEAL

WILLIAMSON SURVEYING & ASSOCIATES, LLC
 104 A WEST MAIN STREET, VAUNAKEE, WISCONSIN, 53597.
 NOA T. PRIEVÉ & CHRIS W. ADAMS
 PROFESSIONAL LAND SURVEYORS
 PHONE: 608-255-5705 FAX: 608-849-9760 WEB: WILLIAMSONSURVEYING.COM

PLAT OF SURVEY

THE SOUTHEAST ½ OF THE NORTHEAST ½ OF LOT 2 AND THE NORTHEAST 6 FEET OF THE SOUTHWEST ½ OF LOT 2, BLOCK 112, PLAT OF MADISON, CITY OF MADISON, DANE COUNTY, WISCONSIN.

| | | | | |
|----------|-------------|----------------|-------------|---------|
| DATE | MAY 9, 2017 | REVISION DATE: | CHECK BY | N.T.P. |
| SCALE: | 1" = 10' | | DRAWING NO. | 17V-134 |
| DRAWN BY | BRAD ROOSHA | | SHEET | 1 OF 1 |

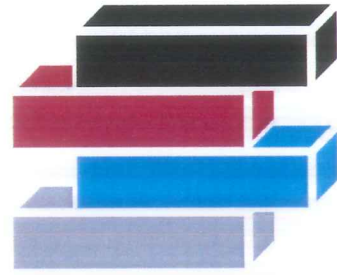

VERTICAL WORKS INC.

modular innovations

DESIGN CODES:

2015 WISCONSIN UNIFORM DWELLING CODE
 CHAPTERS SPS 321, 323
 2015 WISCONSIN ELECTRICAL CODE
 CHAPTER SPS 324
 WISCONSIN PLUMBING CODE
 CHAPTERS SPS 325
 WISCONSIN RESIDENTIAL ENERGY CODE
 CHAPTER SPS 322

DESIGN CRITERIA:

TYPE OF CONSTRUCTION
 WOOD FRAME UNPROTECTED


ROOF LOAD = 40 PSF LIVE
 ROOF LOAD = 7 PSF DEAD
 CEILING LOAD = 5 PSF LIVE
 CEILING LOAD = 7 PSF DEAD
 FLOOR LOAD = 40 PSF LIVE
 FLOOR LOAD = 10 PSF DEAD
 WIND LOAD = 20 PSF

R-VALUES AND U-FACTORS


| CEILING R-VALUE | WOOD FRAME WALL R-VALUE | FLOOR R-VALUE | WINDOW U-FACTOR |
|-----------------|-------------------------|---------------|-----------------|
| 49 | 21 | N/A | 0.29 |

PAGES:

- 1 - COVER PAGE
- 2 - PRODUCT SPECIFICATIONS
- 3 - CROSS SECTION
- 4 - FRONT ELEVATION
- 5 - REAR ELEVATION
- 6 - LEFT ELEVATION
- 7 - RIGHT ELEVATION
- 8 - EXISTING FOUNDATION FLOOR PLAN
- 9 - EXISTING FIRST FLOOR PLAN
- 10 - EXISTING SECOND FLOOR PLAN
- 11 - NEW THIRD FLOOR PLAN
- 12 - DOOR & WINDOW SCHEDULES - THIRD FLOOR
- 13 - ELECTRICAL PLAN - THIRD FLOOR
- 14 - KITCHEN CABINET ELEVATIONS
- 15 - MASTER BATH CABINET ELEVATIONS
- 16 - SITE PLAN FOR ZONING VARIANCE

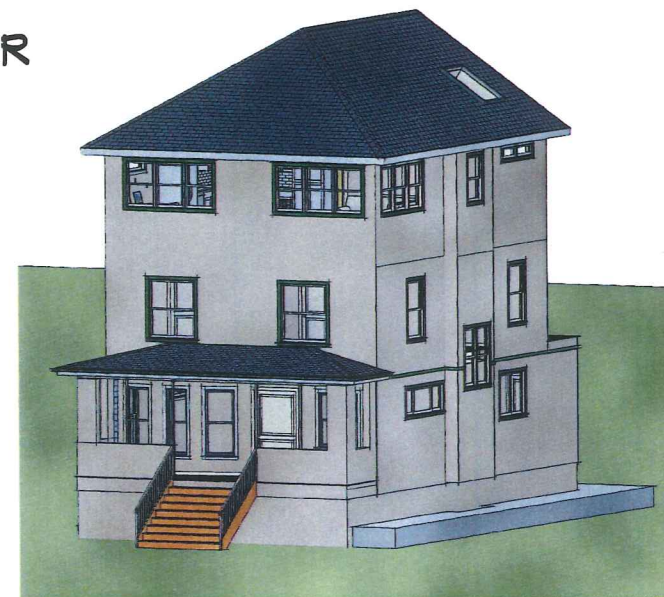

COVER PAGE

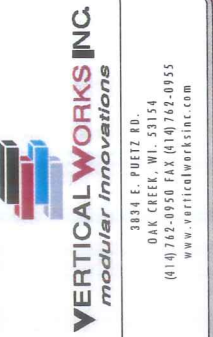

THIS DOCUMENT CONTAINS CONFIDENTIAL OR PROPRIETARY INFORMATION OF VERTICAL WORKS, INC. NEITHER THIS DOCUMENT NOR THE INFORMATION HEREIN IS TO BE REPRODUCED, COPIED, EITHER IN WHOLE OR IN PART EXCEPT AS SPECIFICALLY AUTHORIZED BY VERTICAL WORKS, INC. CONTACT MANUFACTURE FOR FURTHER INSTRUCTION.

CUSTOMER: JOE MARTINO
 DEALER: VERTICAL WORKS, INC.
 MODEL: CUSTOM THIRD STORY ADDITION
 QUOTE: 0096-M SERIAL:
 DRAWN BY: JLK

CUSTOMER PACKAGE

DATES

| ORIGINAL PLAN |
|---------------|
| 3-3-17 |
| 3-26-17 |
| 4-25-17 |
| 5-21-17 |
| 5-27-17 |
| 6-11-17 |
| 6-17-17 |
| 7-3-17 |

1

SCALE: NTS

DATE: _____ CUSTOMER SIGNATURE: _____ CUSTOMER SIGNATURE: _____ DEALER SIGNATURE: _____

PRODUCT SPECIFICATIONS

FLOOR SYSTEM

2-PLY 1 3/4" x 14" LVL EXTERIOR RIM
 FLOOR TRUSSES @ 24" O.C.
 2X4 #2 & BTR SOLID LATERAL BRACING
 3/4" T&G OSB SUBFLOOR GLUED & SCREWED

EXTERIOR

8' WALL HEIGHT
 2x6 STUDS @ 16" O.C.
 SINGLE BOTTOM & DOUBLE TOP PLATES SPF #2 & BTR
 2x10 SYP #1 R-10 INSULATED WINDOW & DOOR HEADERS
 7/16" ZIP SYSTEM WALL SHEETING GLUED & SCREWED

SIDING

TYPE - MASTIC QUEST VINYL SIDING
 COLOR - TBA

GABLES

TYPE - MASTIC QUEST VINYL SIDING
 COLOR - TBA

SIDING TRIM

CORNERS - MASTIC 4" VINYL
 COLOR - TBA

DOORS & WINDOWS - MASTIC J-CHANNEL
 COLOR - TBA

DECK

STYLE - N/A

COLOR - N/A

RAILING - N/A

SOFFIT & FASCIA

SOFFIT - MASTIC 16" CENTER VENT
 COLOR - TBA

FASCIA - MASTIC 6" RIBBED
 COLOR - TBA

WINDOWS

TYPE - DOUBLE HUNG VINYL WINDOWS

COLOR - TBA

JAMBS - WOOD

COLOR - TBA

DOORS

REAR DOOR - TBA

PATIO DOOR - N/A

COLOR - N/A

JAMBS - N/A

COLOR - N/A

COLOR - N/A

LOCKSETS - EXTERIOR

STYLE - TBA

DEADBOLT - TBA

COLOR - TBA

ROOF

ENGINEERED ATTIC ROOF TRUSSES @ 24" O.C.

7/12 ROOF PITCH

12" ENERGY HEEL

1/2" ZIP SYSTEM ROOF SHEETING

ICE & WATER SHIELD FIRST 3'

EAVE & RAKE FASCIA TO BE 6"

OVERHANGS - EAVE 20" - RAKE 20"

SHINGLES

TYPE - GAF TIMBERLINE HD

COLOR - TBA

VALLEYS - CLOSED CUT

COLOR - N/A

RIDGE VENT - GAF SNOWCOUNTRY

SKYLIGHTS

TYPE - VELUX DECK MOUNTED 48"X48"

INTERIOR

8' VAULTED CEILINGS

2X4/2X6 SPF #2 & BTR STUDS @ 16" O.C.

MATE WALL 2X4 SPF STUDS STD/FLAT @ 16" O.C.

SINGLE BOTTOM & DOUBLE TOP PLATES #2 & BTR

INSULATION

CEILING - R-49 FIBERGLASS

EXTERIOR WALLS - R-21 FIBERGLASS

INTERIOR WALLS - N/A

SILL BOX - R-20 STYROFOAM

DRYWALL TEXTURE

CEILING - SMOOTH FINISH

WALLS - SMOOTH FINISH

CORNERS - SQUARE (PLASTIC)

PAINT

VAPOR BARRIER - HCI 8230W

WALL & CEILING FINISH - N/A

SHELVING

TYPE - N/A

COLOR - N/A

DOORS

STYLE - N/A

COLOR - N/A

JAMB - N/A

JAMB COLOR - N/A

LOCKSETS & ACCESSORIES

STYLE - N/A

COLOR - N/A

HINGES & STOPS - NICKEL

CASING

STYLE - N/A

COLOR - N/A

BASE MOLDING

STYLE - N/A

COLOR - N/A

SHOE MOLDING

STYLE - N/A

COLOR - N/A

RAILING/SPINDLES

NEWEL - N/A

SPINDLES - N/A

RAILS - N/A

HALF WALL - N/A

STAIR RAIL - N/A

COLOR - N/A

MASTER BATH

SHOWER

BASE - TBA

COLOR - TBA

WALLS - TBA

SHOWER DOOR - TBA

SHOWER FAUCET

STYLE - TBA

COLOR - TBA

CABINETS

STYLE - TBA

COLOR - TBA

KNOBS - DOORS - N/A

COUNTERTOP

STYLE - TBA

EDGE PROFILE - TBA

COLOR - TBA

SINK

STYLE - TBA

COLOR - TBA

FAUCET

STYLE - TBA

COLOR - TBA

TOILET

TYPE - TBA

COLOR - TBA

ACCESSORIES

TOWEL BAR - TBA

TOILET PAPER HOLDER - TBA

TOILET HANDLE - TBA

COLOR - TBA

MIRROR - TBA

ELECTRICAL

CUTLER HAMMER 100 AMP PANEL

SWITCHES - TOGGLE STYLE

COLOR - WHITE

OUTLETS - DUPLEX

COLOR - WHITE

PHONE/CABLE - COLOR - WHITE

LIGHTING

EXTERIOR REAR - TBA

DINING ROOM - TBA

MASTER BEDROOM - TBA

LIVING ROOM - TBA

STAIR AREA - TBA

RECESSED LIGHTS - SEA-GULL TRAVERSE II

COLOR - WHITE

BATHROOM SINKS - TBA

BATHROOM FAN - BROAN

HEATING

SYSTEM - MINI-SPLIT HEAT PUMP

BOOTS/DUCTWORK

N/A

REGISTERS

N/A

COLOR - WHITE

ANY FLOOR OR TOEKICK VENTS TO BE TAN COLOR

FLOORING

TYPE - TBA

COLOR - TBA



3834 E. PUETZ RD.
 OAK CREEK, WI 53154
 (414) 762-0950 FAX (414) 762-0955
 www.verticalworksinc.com

THIS DOCUMENT CONTAINS
 CONFIDENTIAL OR PROPRIETARY
 INFORMATION OF VERTICAL WORKS,
 INC. NEITHER THIS DOCUMENT NOR
 THE INFORMATION HEREIN IS TO BE
 REPRODUCED, DISTRIBUTED, USED
 OR IN ANY MANNER AS
 SPECIFICALLY AUTHORIZED BY
 VERTICAL WORKS, INC. CONTACT
 MANUFACTURE FOR FURTHER
 INSTRUCTION.

PRODUCT SPECIFICATIONS

CUSTOMER: JOE MARTINO
 DEALER: VERTICAL WORKS, INC.
 MODEL: CUSTOM THIRD STORY ADDITION
 QUOTE: 0096-M SERIAL:
 DRAWN BY: JLK

CUSTOMER PACKAGE


DATES

| | |
|---------------|--------|
| ORIGINAL PLAN | 3-3-17 |
| 3-26-17 | |
| 4-25-17 | |
| 5-21-17 | |
| 5-27-17 | |
| 6-11-17 | |
| 6-17-17 | |
| 7-3-17 | |

2

SCALE: NTS

DATE: _____ CUSTOMER SIGNATURE: _____ CUSTOMER SIGNATURE: _____ DEALER SIGNATURE: _____

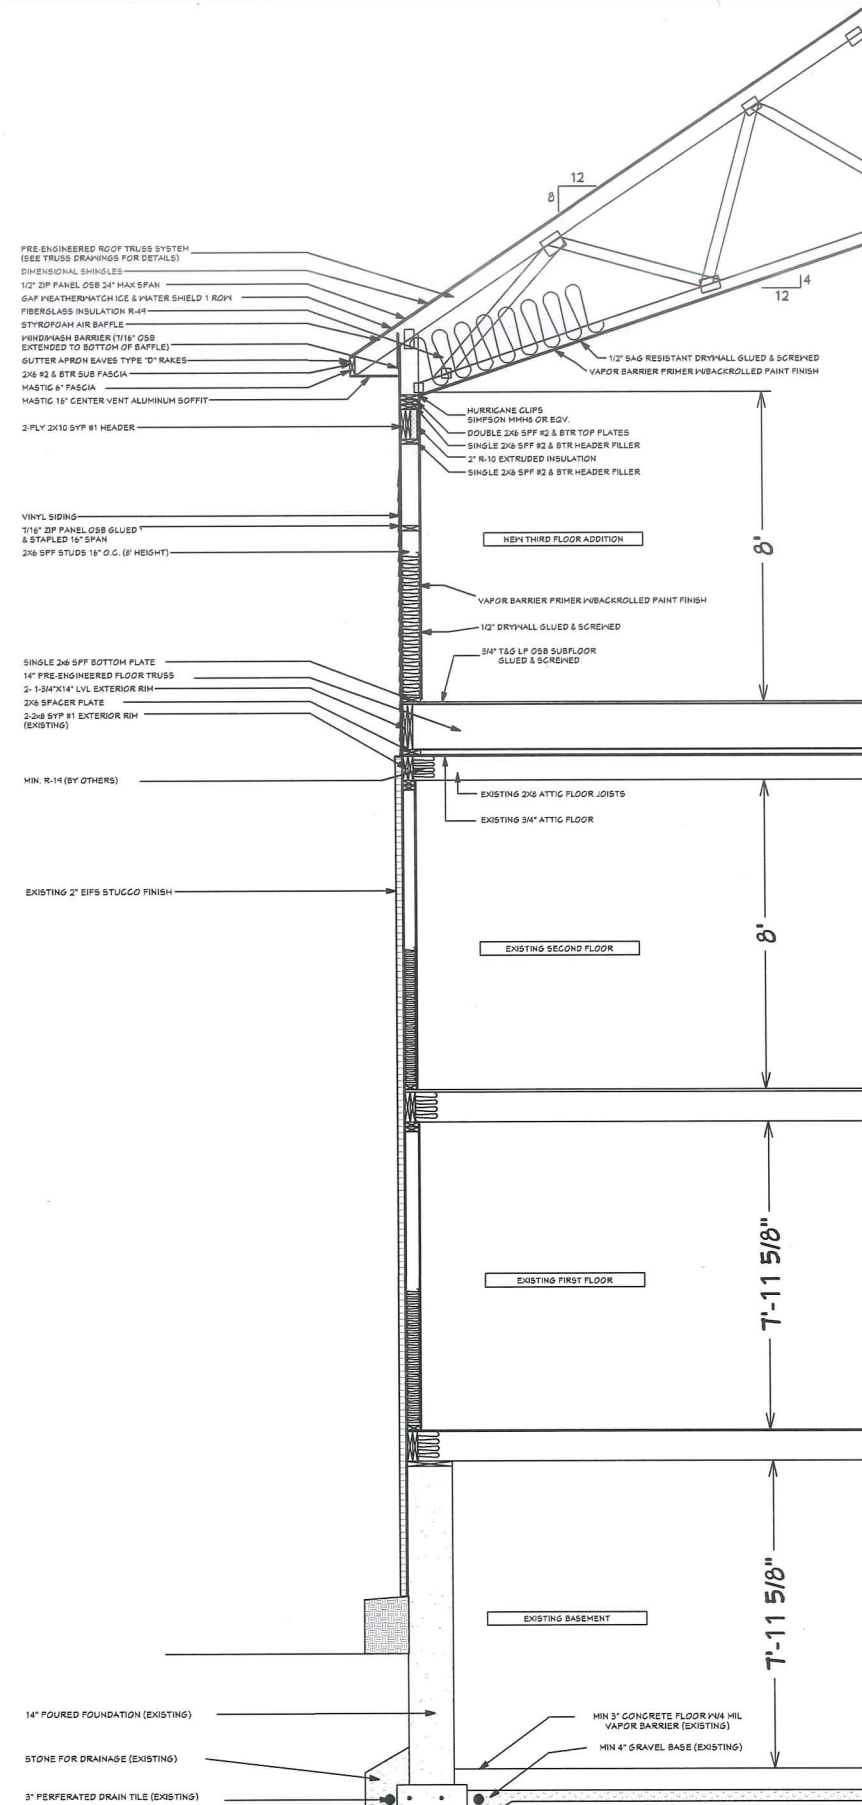

CROSS SECTION

VERTICAL WORKS INC.
modular innovations
 3834 E. PUETZ RD.
 OAK CREEK, WI. 53154
 (414) 742-0950 FAX (414) 742-0955
 www.verticalworksinc.com

THIS DOCUMENT CONTAINS CONFIDENTIAL OR PROPRIETARY INFORMATION OF VERTICAL WORKS, INC. NEITHER THIS DOCUMENT NOR THE INFORMATION HEREIN IS TO BE REPRODUCED, DISTRIBUTED, USED OR DISCLOSED IN ANY MANNER WITHOUT THE EXPRESS WRITTEN PERMISSION OF VERTICAL WORKS, INC. CONTACT MANUFACTURE FOR FURTHER INSTRUCTION.

CUSTOMER: JOE MARTINO
DEALER: VERTICAL WORKS, INC.
MODEL: CUSTOM THIRD STORY ADDITION
QUOTE: 0096-M
SERIAL:
DRAWN BY: JLK

CUSTOMER PACKAGE

DATES

| | |
|---------------|--------|
| ORIGINAL PLAN | 3-3-17 |
| 3-26-17 | |
| 4-25-17 | |
| 5-21-17 | |
| 5-27-17 | |
| 6-11-17 | |
| 6-17-17 | |
| 7-3-17 | |

3

SCALE: 3/16"=1'

DATE: _____ CUSTOMER SIGNATURE: _____ CUSTOMER SIGNATURE: _____ DEALER SIGNATURE: _____



FRONT ELEVATION

VERTICAL WORKS INC.
modular innovations
 3834 E. FUETZ RD.
 OAK CREEK, WI. 53154
 (414) 762-0950 FAX (414) 762-0955
 www.verticalworksinc.com

THIS DOCUMENT CONTAINS CONFIDENTIAL OR PROPRIETARY INFORMATION OF VERTICAL WORKS, INC. NEITHER THIS DOCUMENT NOR THE INFORMATION CONTAINED HEREIN IS TO BE REPRODUCED, COPIED, DISTRIBUTED, USED OR DISCLOSED EITHER IN WHOLE OR IN PART EXCEPT AS SPECIFICALLY AUTHORIZED BY VERTICAL WORKS, INC. CONTACT VERTICAL WORKS, INC. FOR FURTHER INSTRUCTION.

CUSTOMER: JOE MARTINO
DEALER: VERTICAL WORKS, INC.
MODEL: CUSTOM THIRD STORY ADDITION
QUOTE: 0096-M
SERIAL:
DRAWN BY: JLK

CUSTOMER PACKAGE


DATES

| | |
|---------------|--------|
| ORIGINAL PLAN | 3-3-17 |
| 3-26-17 | |
| 4-25-17 | |
| 5-21-17 | |
| 5-27-17 | |
| 6-11-17 | |
| 6-17-17 | |
| 7-3-17 | |

4

SCALE: 3/16"=1'

DATE: _____ CUSTOMER SIGNATURE: _____ CUSTOMER SIGNATURE: _____ DEALER SIGNATURE: _____

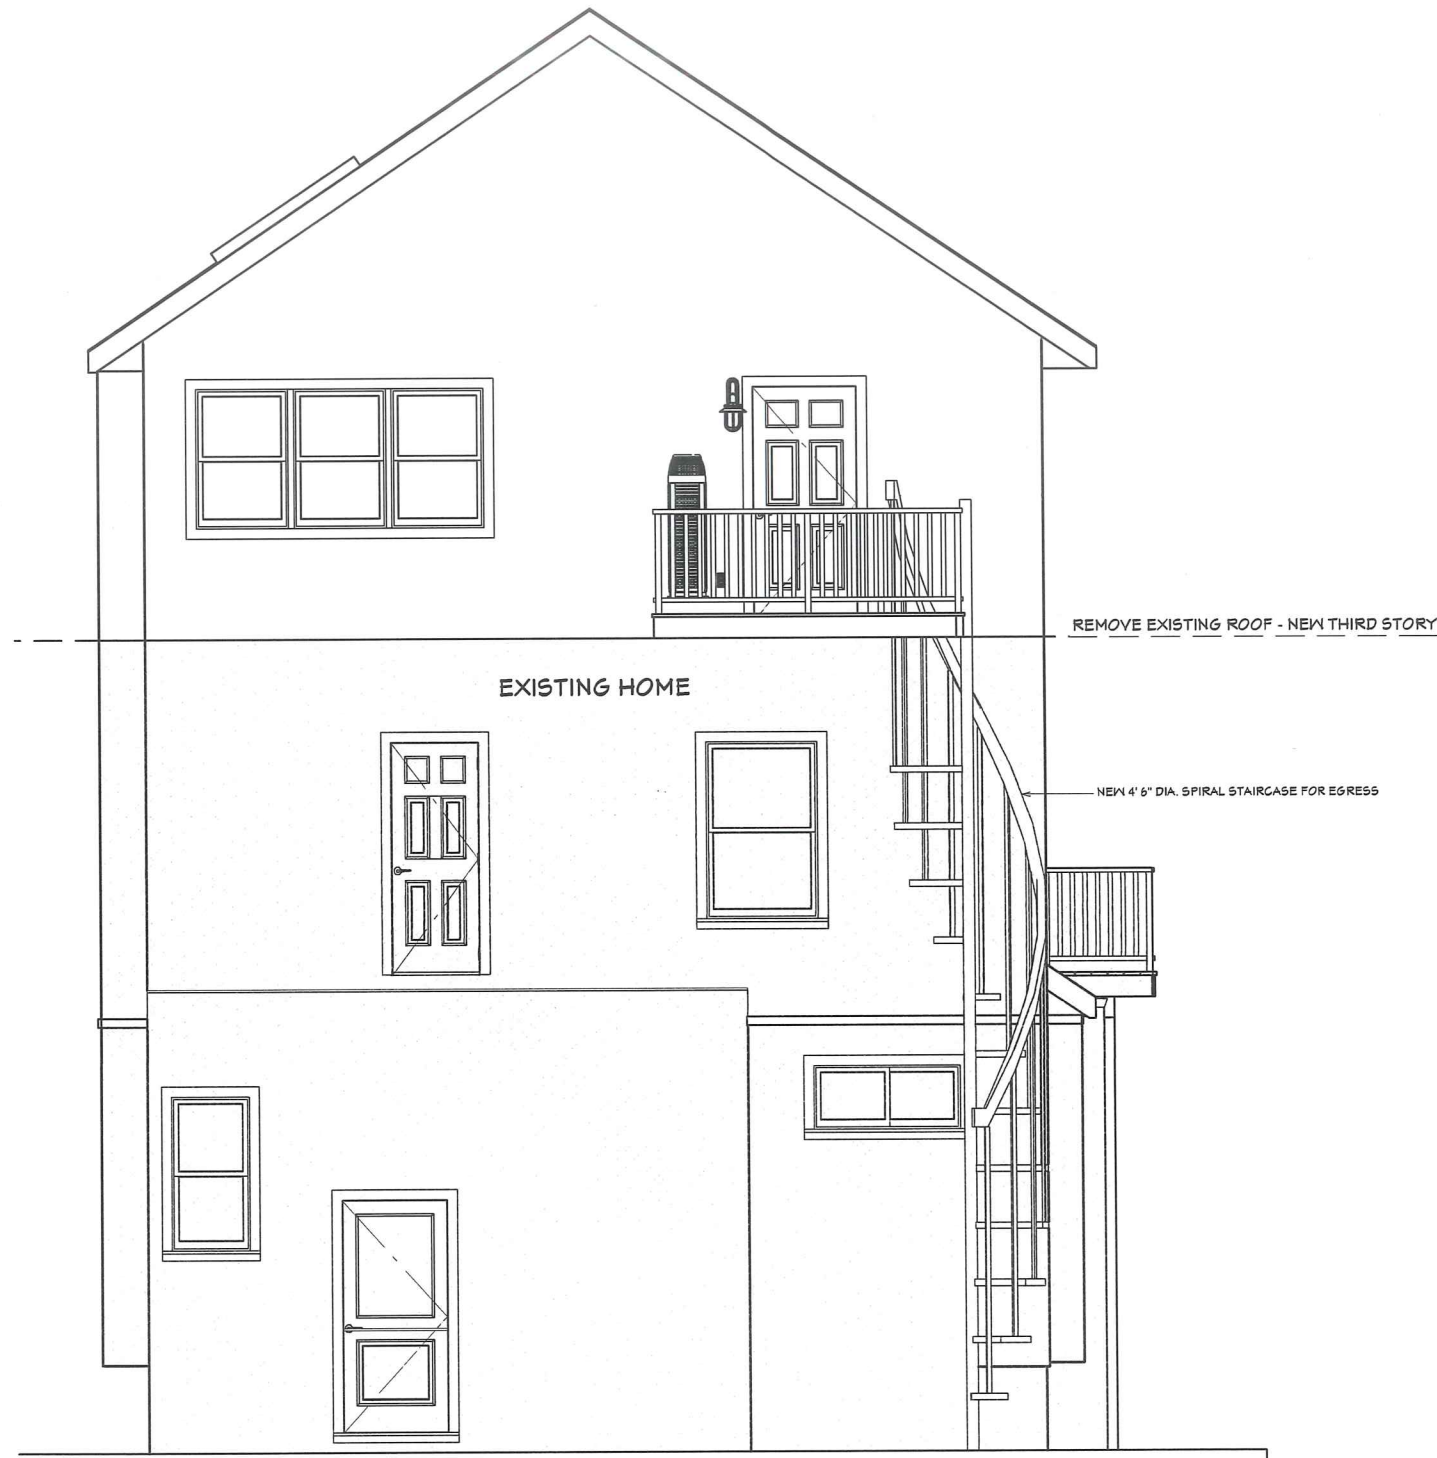

REAR ELEVATION

VERTICAL WORKS INC.
modular innovations
 3834 E. PUETZ RD.
 OAK CREEK, WI. 53154
 (414) 762-0950 FAX (414) 762-0955
 www.verticalworksinc.com

THIS DOCUMENT CONTAINS CONFIDENTIAL OR PROPRIETARY INFORMATION OF VERTICAL WORKS, INC. NEITHER THIS DOCUMENT NOR THE INFORMATION HEREIN IS TO BE REPRODUCED, DISTRIBUTED, COPIED, OR IN ANY MANNER USED SPECIFICALLY AUTHORIZED BY VERTICAL WORKS, INC. CONTACT MANUFACTURE FOR FURTHER INSTRUCTION.

CUSTOMER: JOE MARTINO
 DEALER: VERTICAL WORKS, INC.
 MODEL: CUSTOM THIRD STORY ADDITION
 QUOTE: 00916-M SERIAL:
 DRAWN BY: JLK

CUSTOMER PACKAGE

DATES
 ORIGINAL PLAN
 3-3-17

| |
|---------|
| 3-26-17 |
| 4-25-17 |
| 5-21-17 |
| 5-27-17 |
| 6-11-17 |
| 6-17-17 |
| 7-3-17 |

5

SCALE: 3/16"=1'

DATE: _____ CUSTOMER SIGNATURE: _____ CUSTOMER SIGNATURE: _____ DEALER SIGNATURE: _____



LEFT ELEVATION

VERTICAL WORKS INC.
modular innovations

3834 E. PUETZ RD.
 OAK CREEK, WI. 53154
 (414) 742-0950 FAX (414) 742-0955
 www.verticalworksinc.com

THIS DOCUMENT CONTAINS CONFIDENTIAL OR PROPRIETARY INFORMATION OF VERTICAL WORKS, INC. NEITHER THIS DOCUMENT NOR THE INFORMATION HEREIN IS TO BE REPRODUCED, COPIED, EITHER IN WHOLE OR IN PART EXCEPT AS SPECIFICALLY AUTHORIZED BY VERTICAL WORKS, INC. CONTACT MANUFACTURE FOR FURTHER INSTRUCTION.

CUSTOMER: JOE MARTINO
 DEALER: VERTICAL WORKS, INC.
 MODEL: CUSTOM THIRD STORY ADDITION
 QUOTE: 0096-M SERIAL:
 DRAWN BY: JLK

CUSTOMER PACKAGE

DATES

| | |
|---------------|---------|
| ORIGINAL PLAN | 3-3-17 |
| | 3-26-17 |
| | 4-25-17 |
| | 5-21-17 |
| | 5-27-17 |
| | 6-11-17 |
| | 6-17-17 |
| | 7-3-17 |

6

SCALE: 3/16"=1'

DATE: _____ CUSTOMER SIGNATURE: _____ CUSTOMER SIGNATURE: _____ DEALER SIGNATURE: _____



RIGHT ELEVATION

VERTICAL WORKS INC.
modular innovations
 3834 E. FUETT RD.
 OAK CREEK, WI. 53154
 (414) 762-0958 FAX (414) 762-0955
 www.verticalworksinc.com

THIS DOCUMENT CONTAINS
 CONFIDENTIAL OR PROPRIETARY
 INFORMATION OF VERTICAL WORKS
 INC. NEITHER THIS DOCUMENT NOR
 THE INFORMATION HEREIN IS TO BE
 REPRODUCED, COPIED, EITHER IN WHOLE
 OR IN PART EXCEPT AS
 SPECIFICALLY AUTHORIZED BY
 VERTICAL WORKS, INC. CONTACT
 MANUFACTURE FOR FURTHER
 INSTRUCTION.

CUSTOMER: JOE MARTINO
 DEALER: VERTICAL WORKS, INC.
 MODEL: CUSTOM THIRD STORY ADDITION
 QUOTE: 0096-M SERIAL:
 DRAWN BY: JLK

CUSTOMER PACKAGE

DATES


| | |
|---------------|--|
| ORIGINAL PLAN | |
| 3-3-17 | |
| 3-26-17 | |
| 4-25-17 | |
| 5-21-17 | |
| 5-27-17 | |
| 6-11-17 | |
| 6-17-17 | |
| 7-3-17 | |

7

SCALE: 3/16"=1'

DATE: _____ CUSTOMER SIGNATURE: _____ CUSTOMER SIGNATURE: _____ DEALER SIGNATURE: _____

EXISTING FOUNDATION FLOOR PLAN

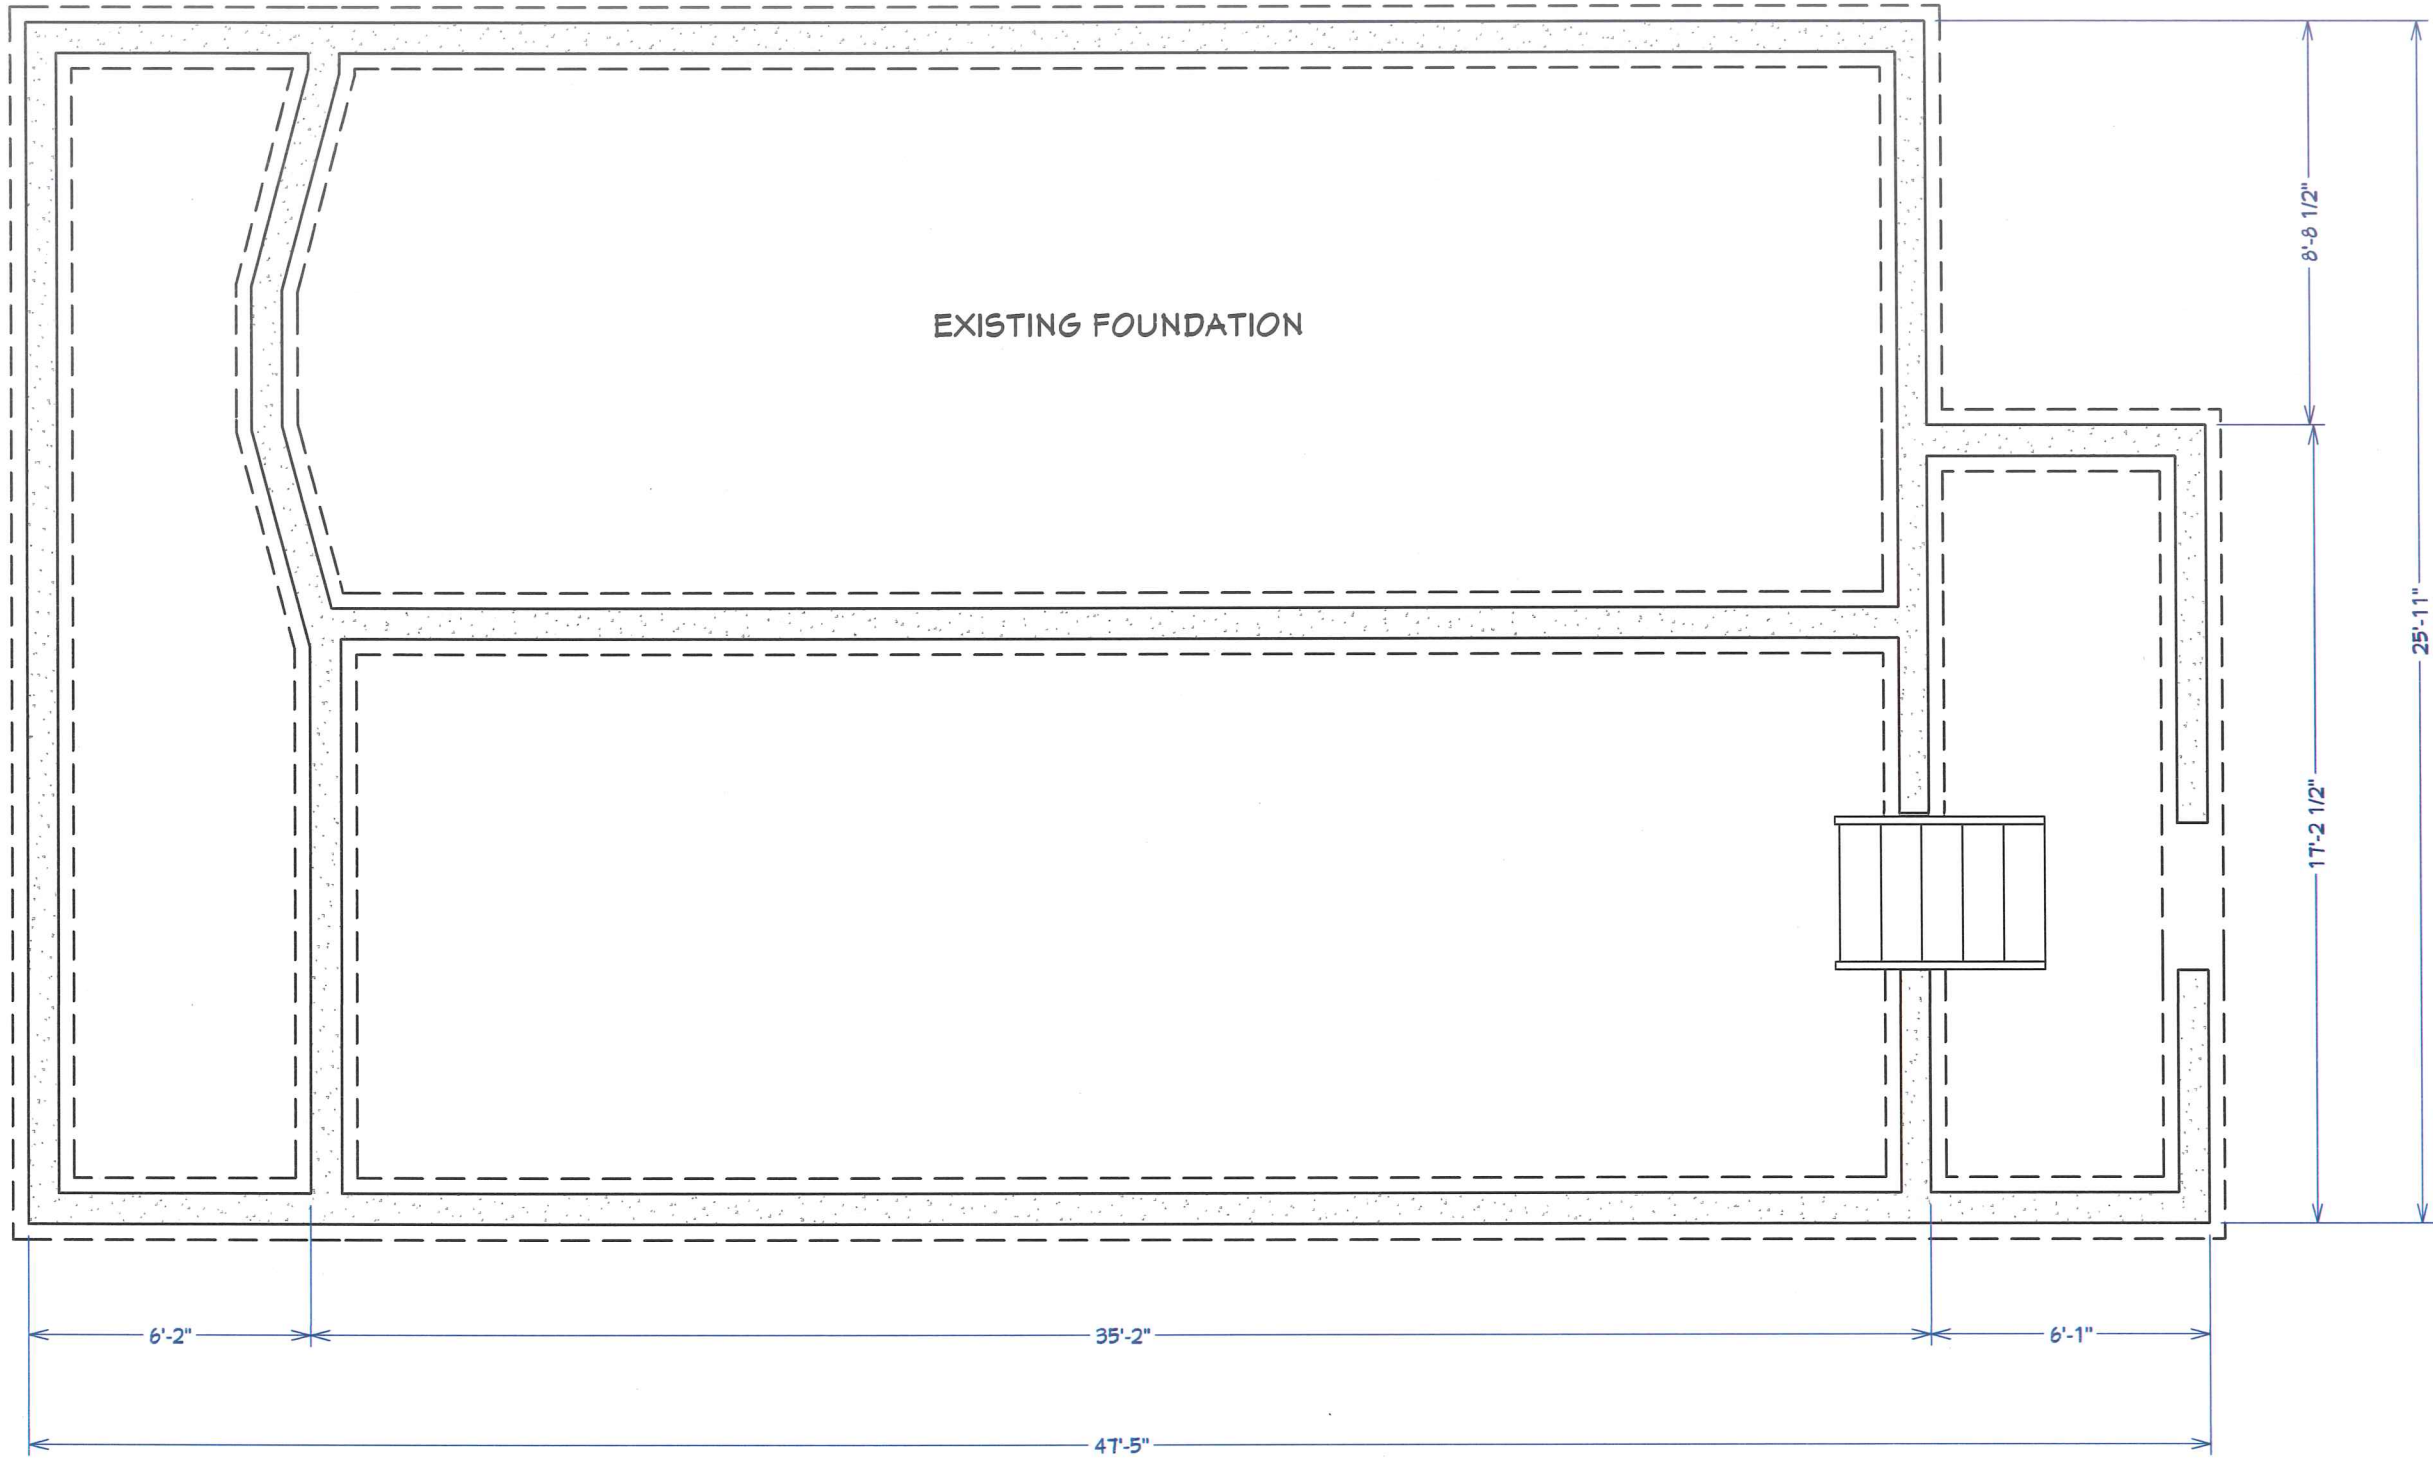

EXISTING FOUNDATION

VERTICAL WORKS INC.
modular innovations

3834 E. PUETZ RD.
 OAK CREEK, WI. 53154
 (414) 762-0950 FAX (414) 762-0955
 www.verticalworksinc.com

THIS DOCUMENT CONTAINS
 CONFIDENTIAL OR PROPRIETARY
 INFORMATION OF VERTICAL WORKS,
 INC. NEITHER THIS PACKAGE NOR
 THE INFORMATION CONTAINED HEREIN
 IS TO BE REPRODUCED, COPIED,
 REPRODUCED, DISTRIBUTED, USED
 OR DISCLOSED EITHER IN WHOLE
 OR IN PART EXCEPT AS
 SPECIFICALLY AUTHORIZED BY
 VERTICAL WORKS, INC. CONTACT
 MANUFACTURE FOR FURTHER
 INSTRUCTION.

CUSTOMER: JOE MARTINO
 DEALER: VERTICAL WORKS, INC.
 MODEL: CUSTOM THIRD STORY ADDITION
 QUOTE: 0096-M SERIAL:
 DRAWN BY: JLK

CUSTOMER PACKAGE


DATES

| | |
|---------------|--|
| ORIGINAL PLAN | |
| 3-3-17 | |
| 3-26-17 | |
| 4-25-17 | |
| 5-21-17 | |
| 5-27-17 | |
| 6-11-17 | |
| 6-17-17 | |
| 7-3-17 | |

8

SCALE: 1/4" = 1'

DATE: _____ CUSTOMER SIGNATURE: _____ CUSTOMER SIGNATURE: _____ DEALER SIGNATURE: _____

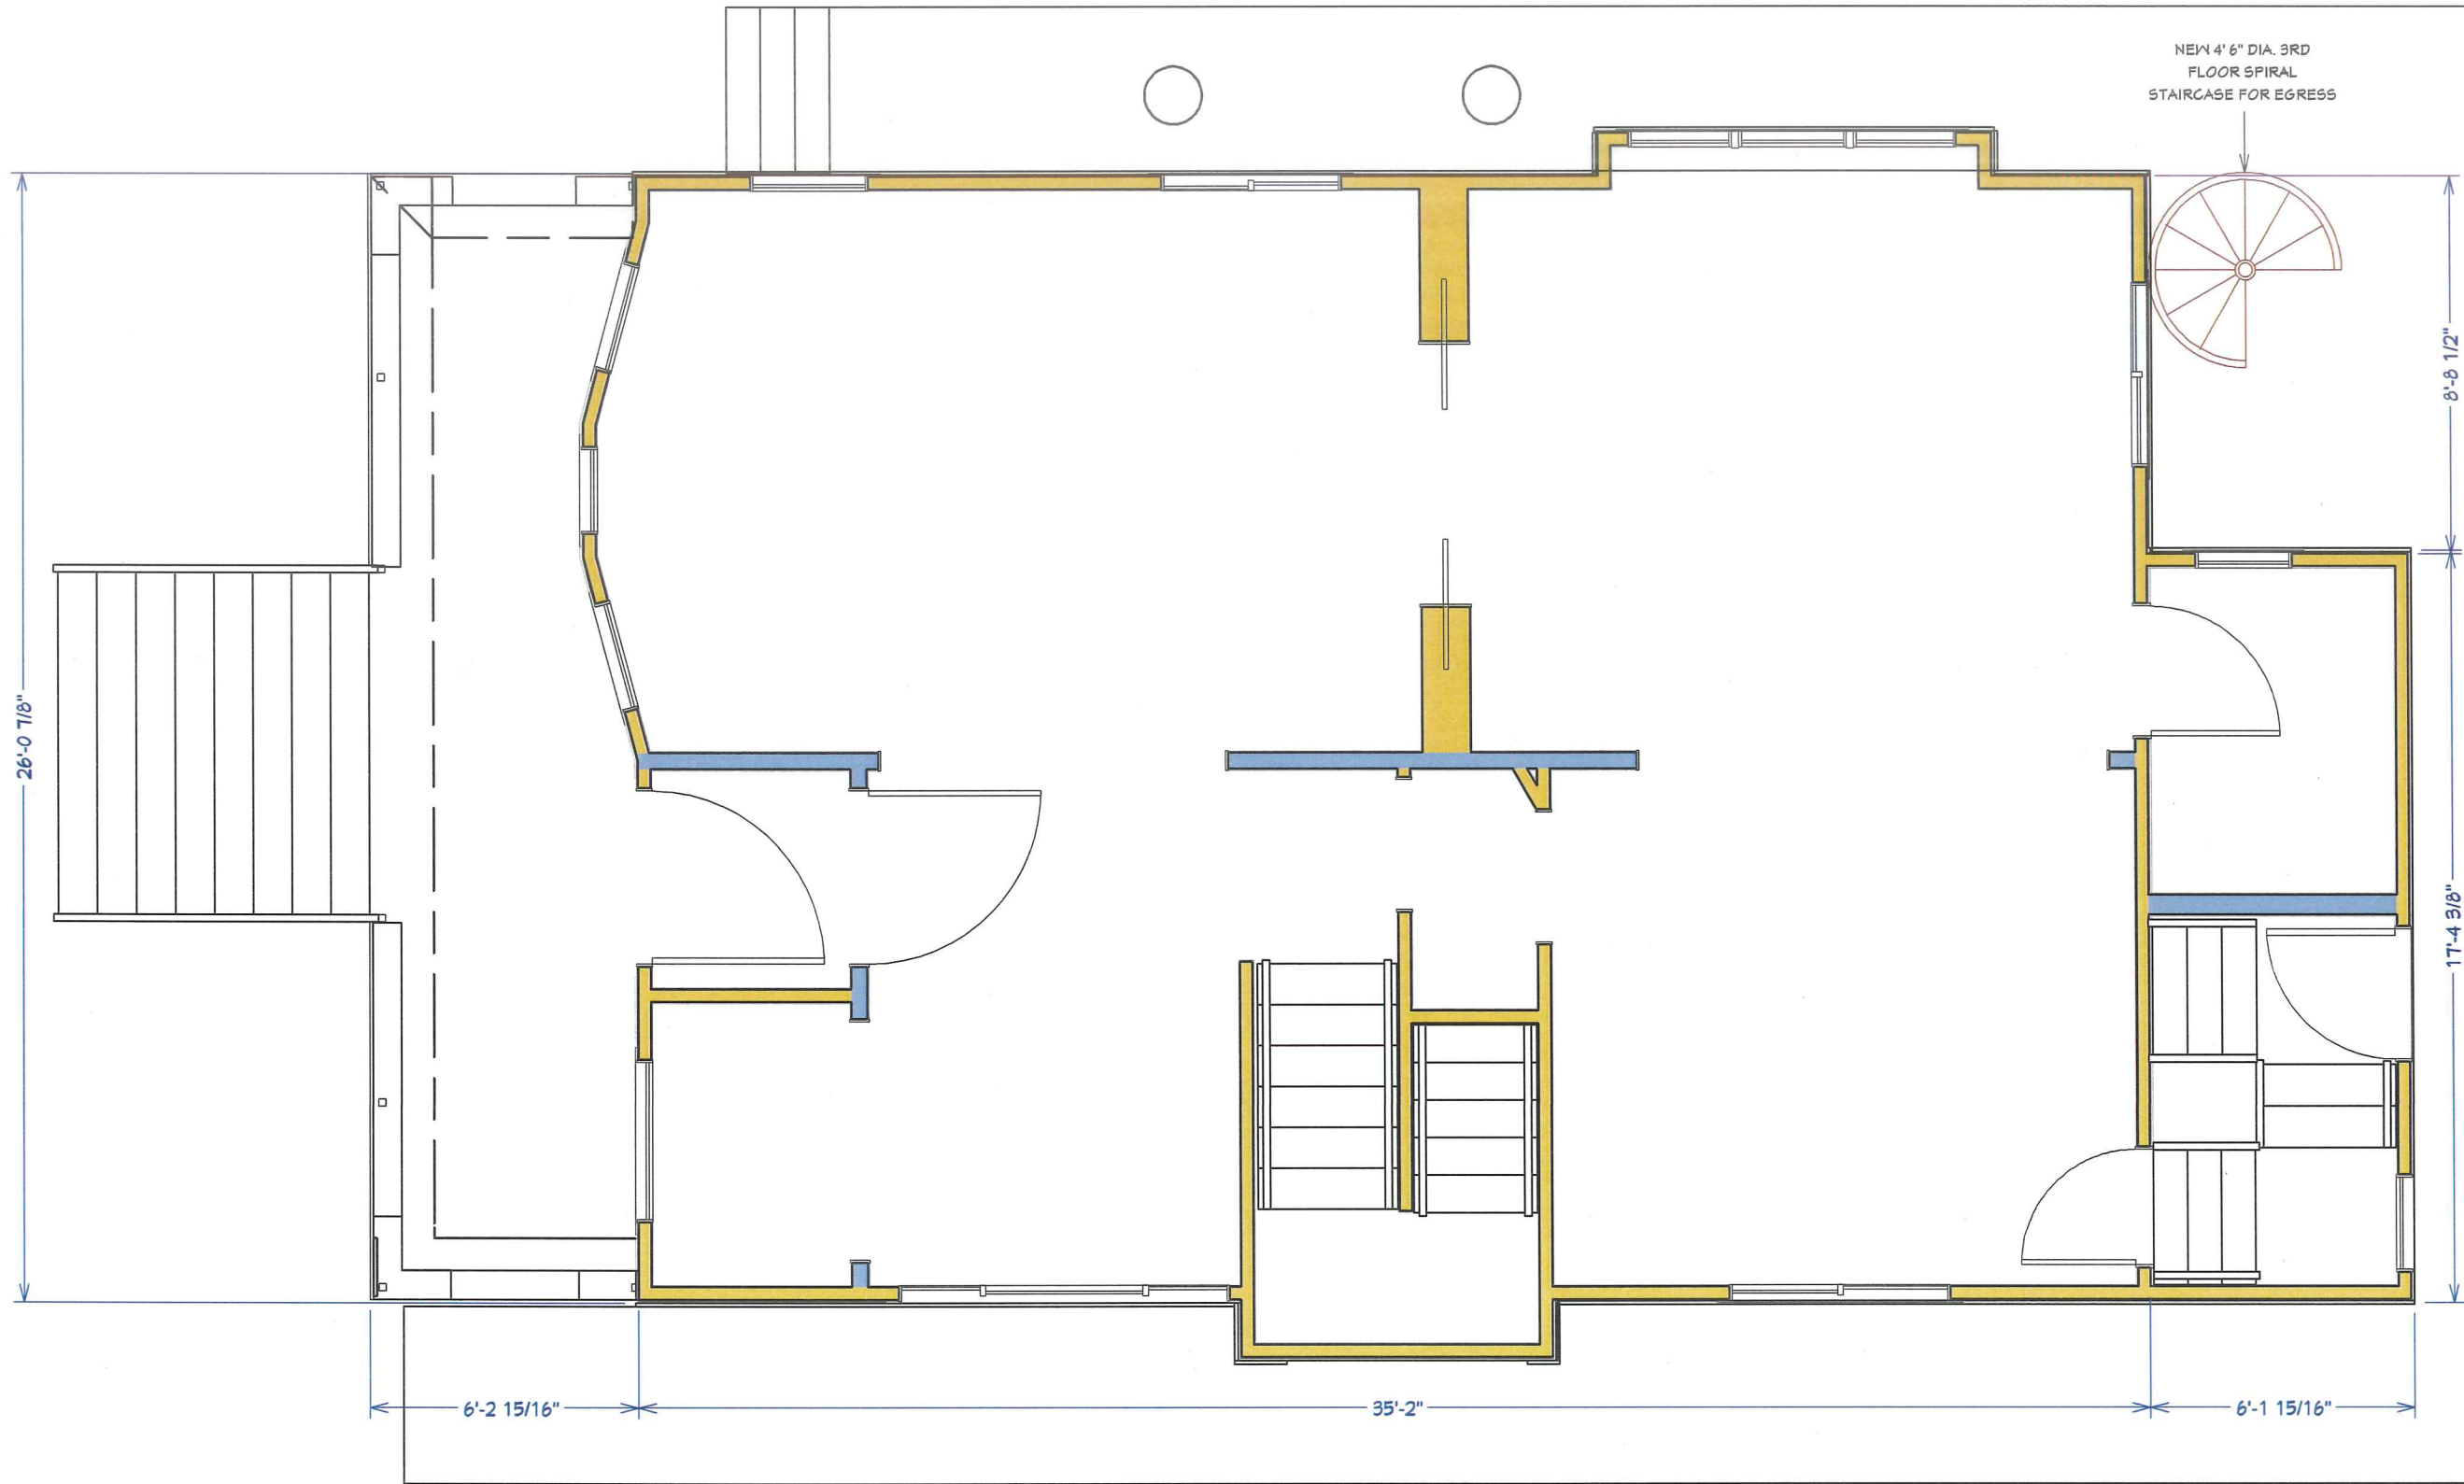

EXISTING FIRST FLOOR PLAN 1197 S.F.

VERTICAL WORKS INC.
modular innovations
 3834 E. PUETZ RD.
 OAK CREEK, WI, 53154
 (414) 762-0950 FAX (414) 762-0955
 www.verticalworksinc.com

THIS DOCUMENT CONTAINS CONFIDENTIAL OR PROPRIETARY INFORMATION OF VERTICAL WORKS, INC. NEITHER THIS DOCUMENT NOR THE INFORMATION HERE IS TO BE REPRODUCED, DISTRIBUTED, USED OR DISCLOSED EITHER IN WHOLE OR SPECIALLY AUTHORIZED BY VERTICAL WORKS, INC. CONTACT MANUFACTURE FOR FURTHER INSTRUCTION.

CUSTOMER: JOE MARTINO
 DEALER: VERTICAL WORKS, INC.
 MODEL: CUSTOM THIRD STORY ADDITION
 QUOTE: 0096-M SERIAL:
 DRAWN BY: JLK

CUSTOMER PACKAGE


DATES

| | |
|---------------|--------|
| ORIGINAL PLAN | 3-3-17 |
| 3-26-17 | |
| 4-25-17 | |
| 5-21-17 | |
| 5-27-17 | |
| 6-11-17 | |
| 6-17-17 | |
| 7-3-17 | |

9

SCALE: 1/4"=1'

DATE: _____ CUSTOMER SIGNATURE: _____ CUSTOMER SIGNATURE: _____ DEALER SIGNATURE: _____

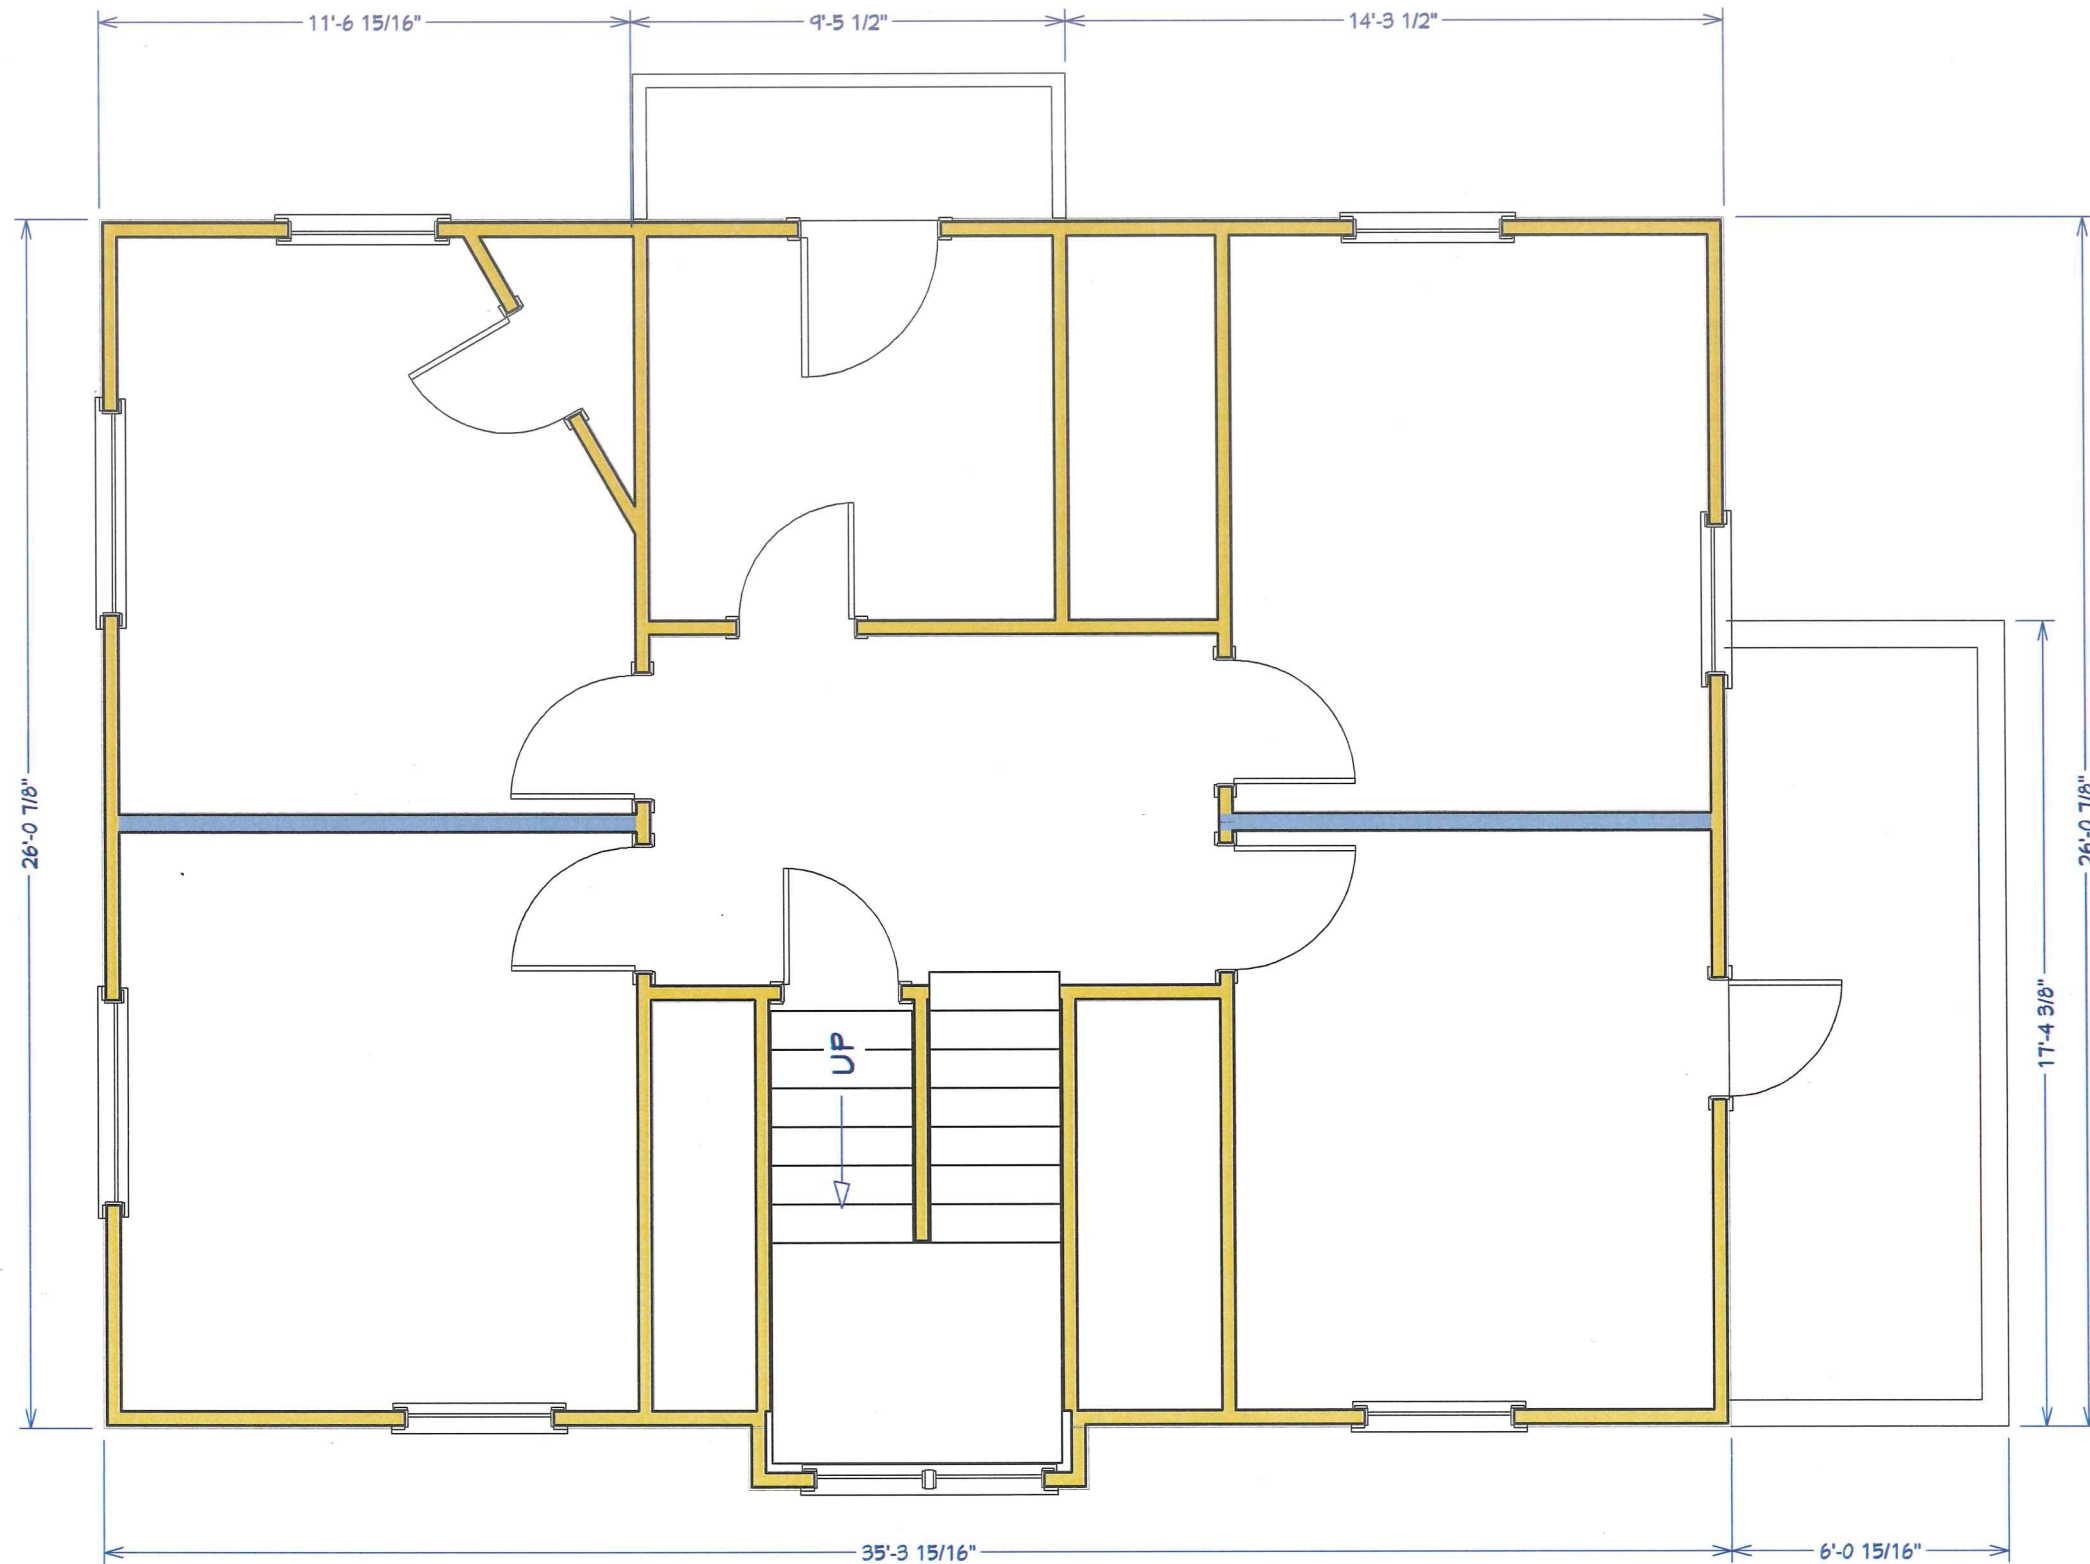

EXISTING SECOND FLOOR PLAN 9225F

VERTICAL WORKS INC.
modular innovations
 3834 E. PUETZ RD.
 OAK CREEK, WI, 53154
 (414) 762-0950 FAX (414) 762-0955
 WWW.VERTICALWORKSINC.COM

THIS DOCUMENT CONTAINS
 CONFIDENTIAL OR PROPRIETARY
 INFORMATION OF VERTICAL WORKS
 INC. NEITHER THIS DOCUMENT NOR
 THE INFORMATION HEREIN IS TO BE
 REPRODUCED, DISTRIBUTED, USED
 OR DISCLOSED IN ANY MANNER,
 OR IN ANY MANNER, WITHOUT THE
 SPECIFIC AUTHORIZATION BY
 VERTICAL WORKS, INC. CONTACT
 MANUFACTURE FOR FURTHER
 INSTRUCTION.

CUSTOMER: JOE MARTINO
 DEALER: VERTICAL WORKS, INC.
 MODEL: CUSTOM THIRD STORY ADDITION
 QUOTE: 0096-M SERIAL:
 DRAWN BY: JLK

CUSTOMER PACKAGE


DATES

| | |
|---------------|--------|
| ORIGINAL PLAN | 3-3-17 |
| 3-26-17 | |
| 4-25-17 | |
| 5-21-17 | |
| 5-27-17 | |
| 6-11-17 | |
| 6-17-17 | |
| 7-3-17 | |

10

SCALE: 1/4" = 1'

DATE: _____ CUSTOMER SIGNATURE: _____ CUSTOMER SIGNATURE: _____ DEALER SIGNATURE: _____

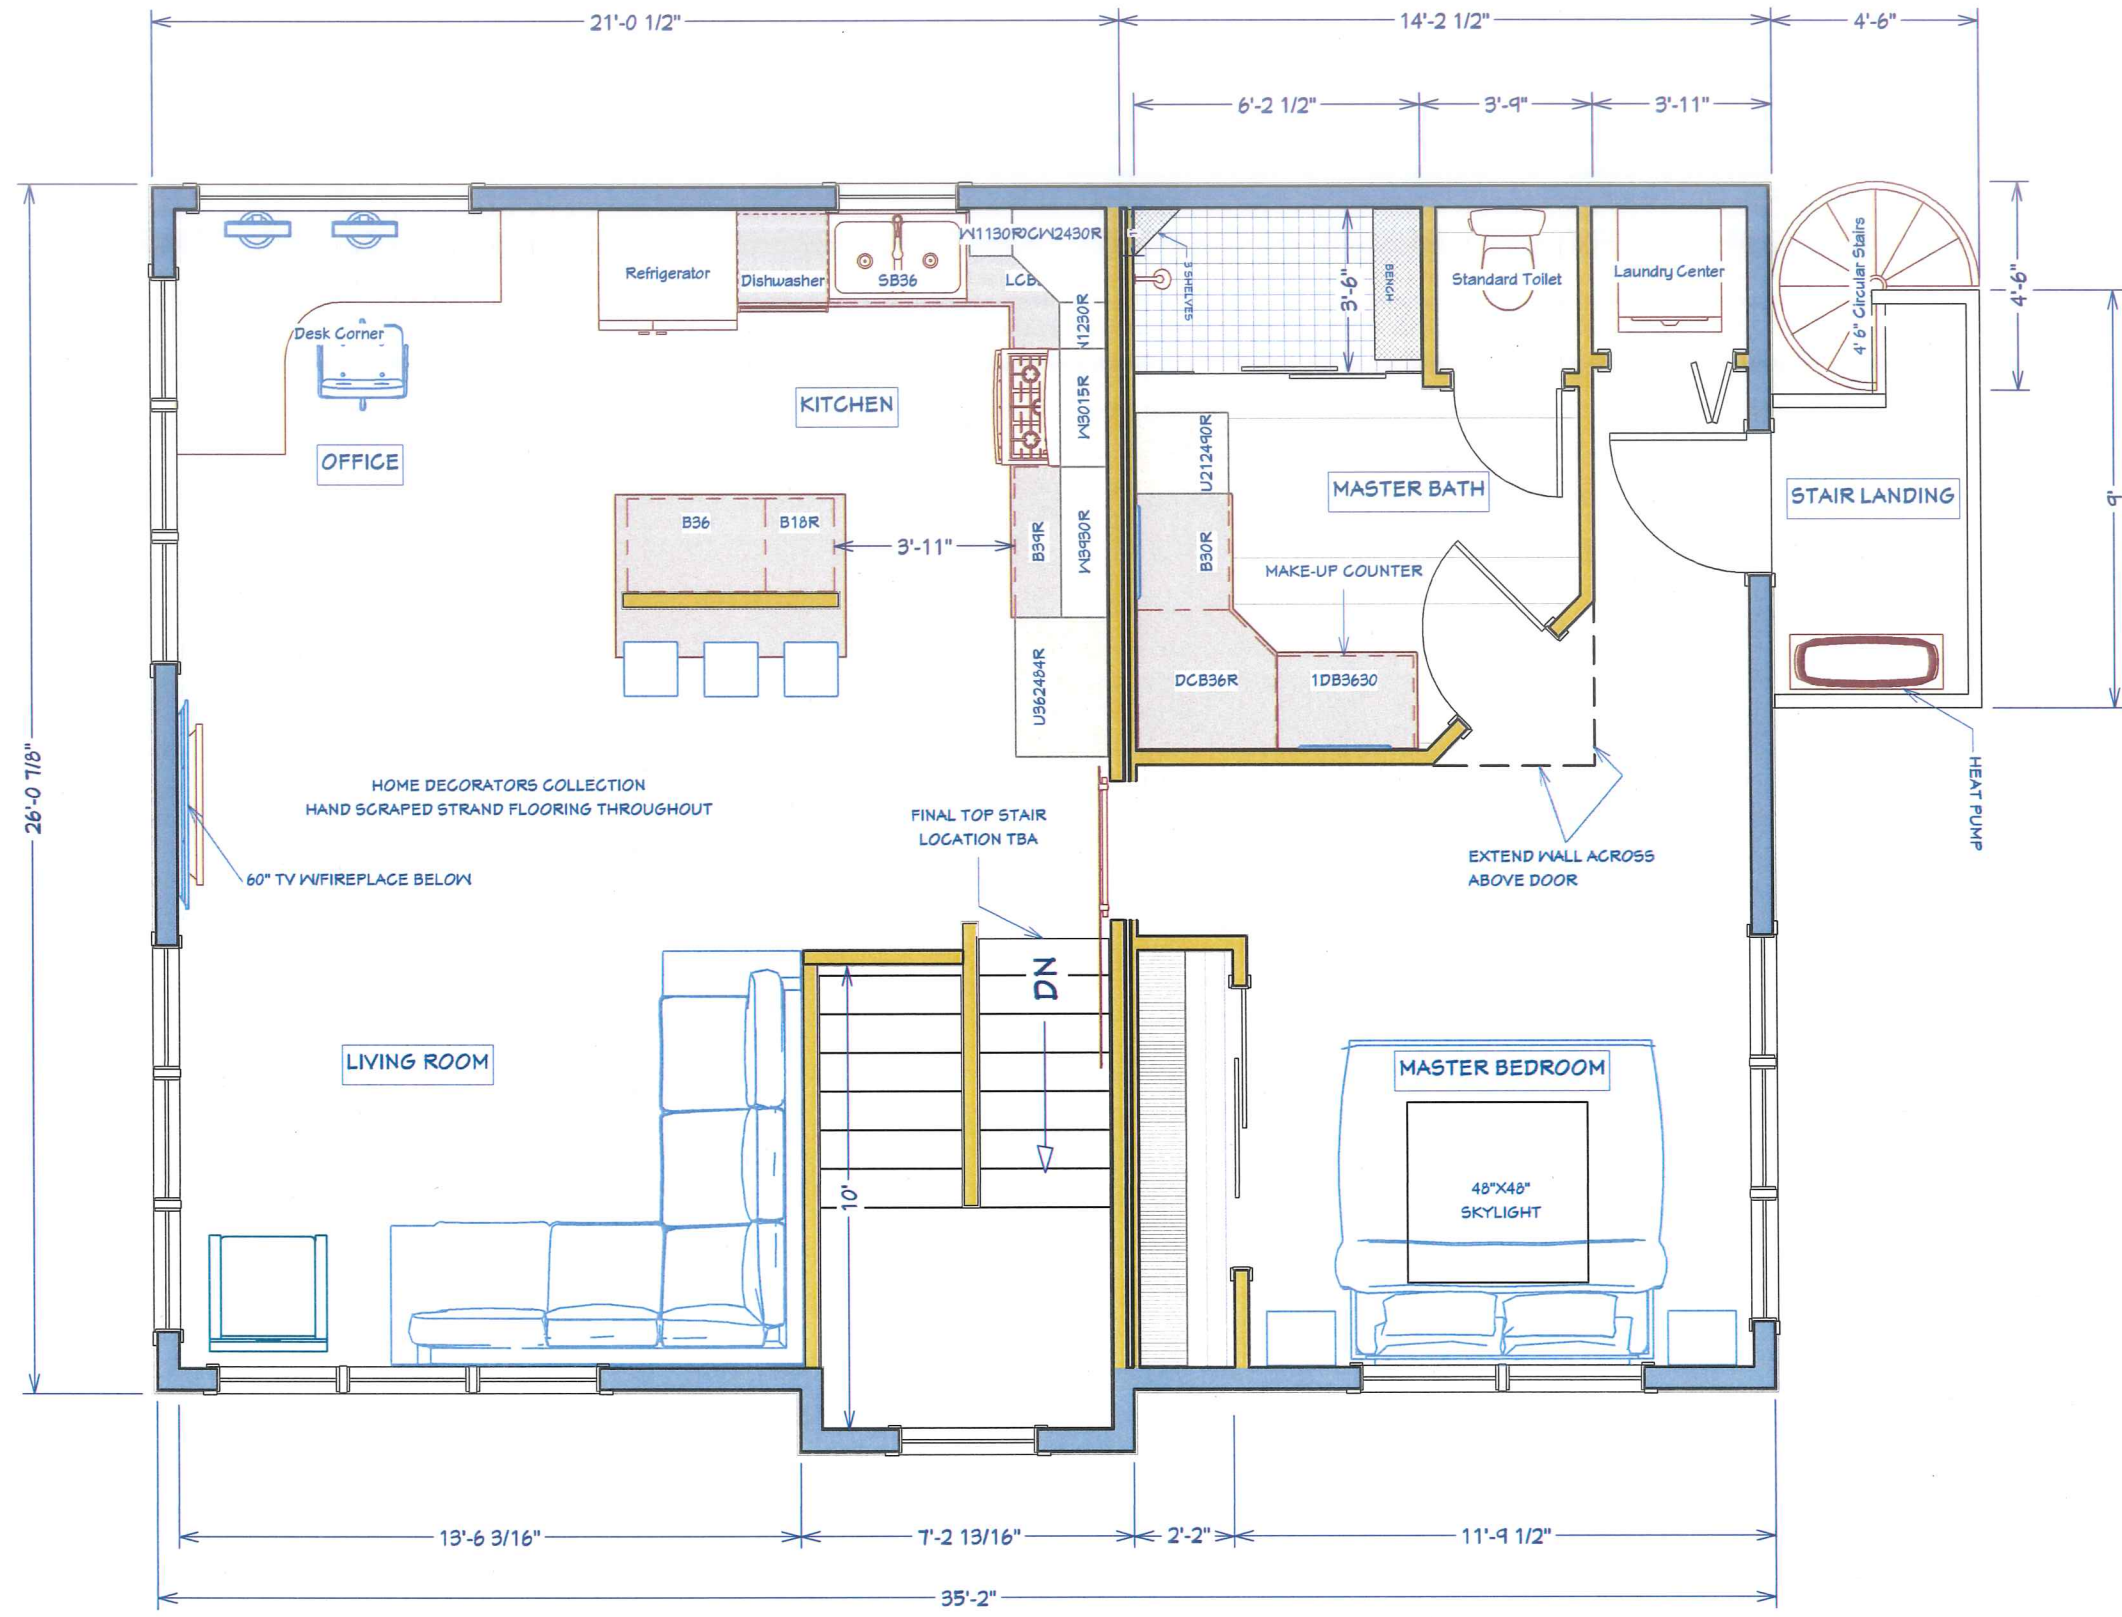

NEW THIRD FLOOR PLAN 9215F



THIS DOCUMENT CONTAINS CONFIDENTIAL OR PROPRIETARY INFORMATION OF VERTICAL WORKS, INC. NEITHER THIS DOCUMENT NOR THE INFORMATION HEREIN IS TO BE REPRODUCED, DISTRIBUTED, USED OR DISCLOSED EITHER IN WHOLE OR IN PART WITHOUT THE SPECIFIC AUTHORIZATION BY VERTICAL WORKS, INC. CONTACT MANUFACTURE FOR FURTHER INSTRUCTION.

CUSTOMER: JOE MARTINO
 DEALER: VERTICAL WORKS, INC.
 MODEL: CUSTOM THIRD STORY ADDITION
 QUOTE: 00916-M SERIAL:
 DRAWN BY: JLK

CUSTOMER PACKAGE


DATES

| | |
|---------------|---------|
| ORIGINAL PLAN | 3-3-17 |
| | 3-26-17 |
| | 4-25-17 |
| | 5-21-17 |
| | 5-27-17 |
| | 6-11-17 |
| | 6-17-17 |
| | 7-3-17 |

11

SCALE: 1/4"=1'

DATE: _____ CUSTOMER SIGNATURE: _____ CUSTOMER SIGNATURE: _____ DEALER SIGNATURE: _____

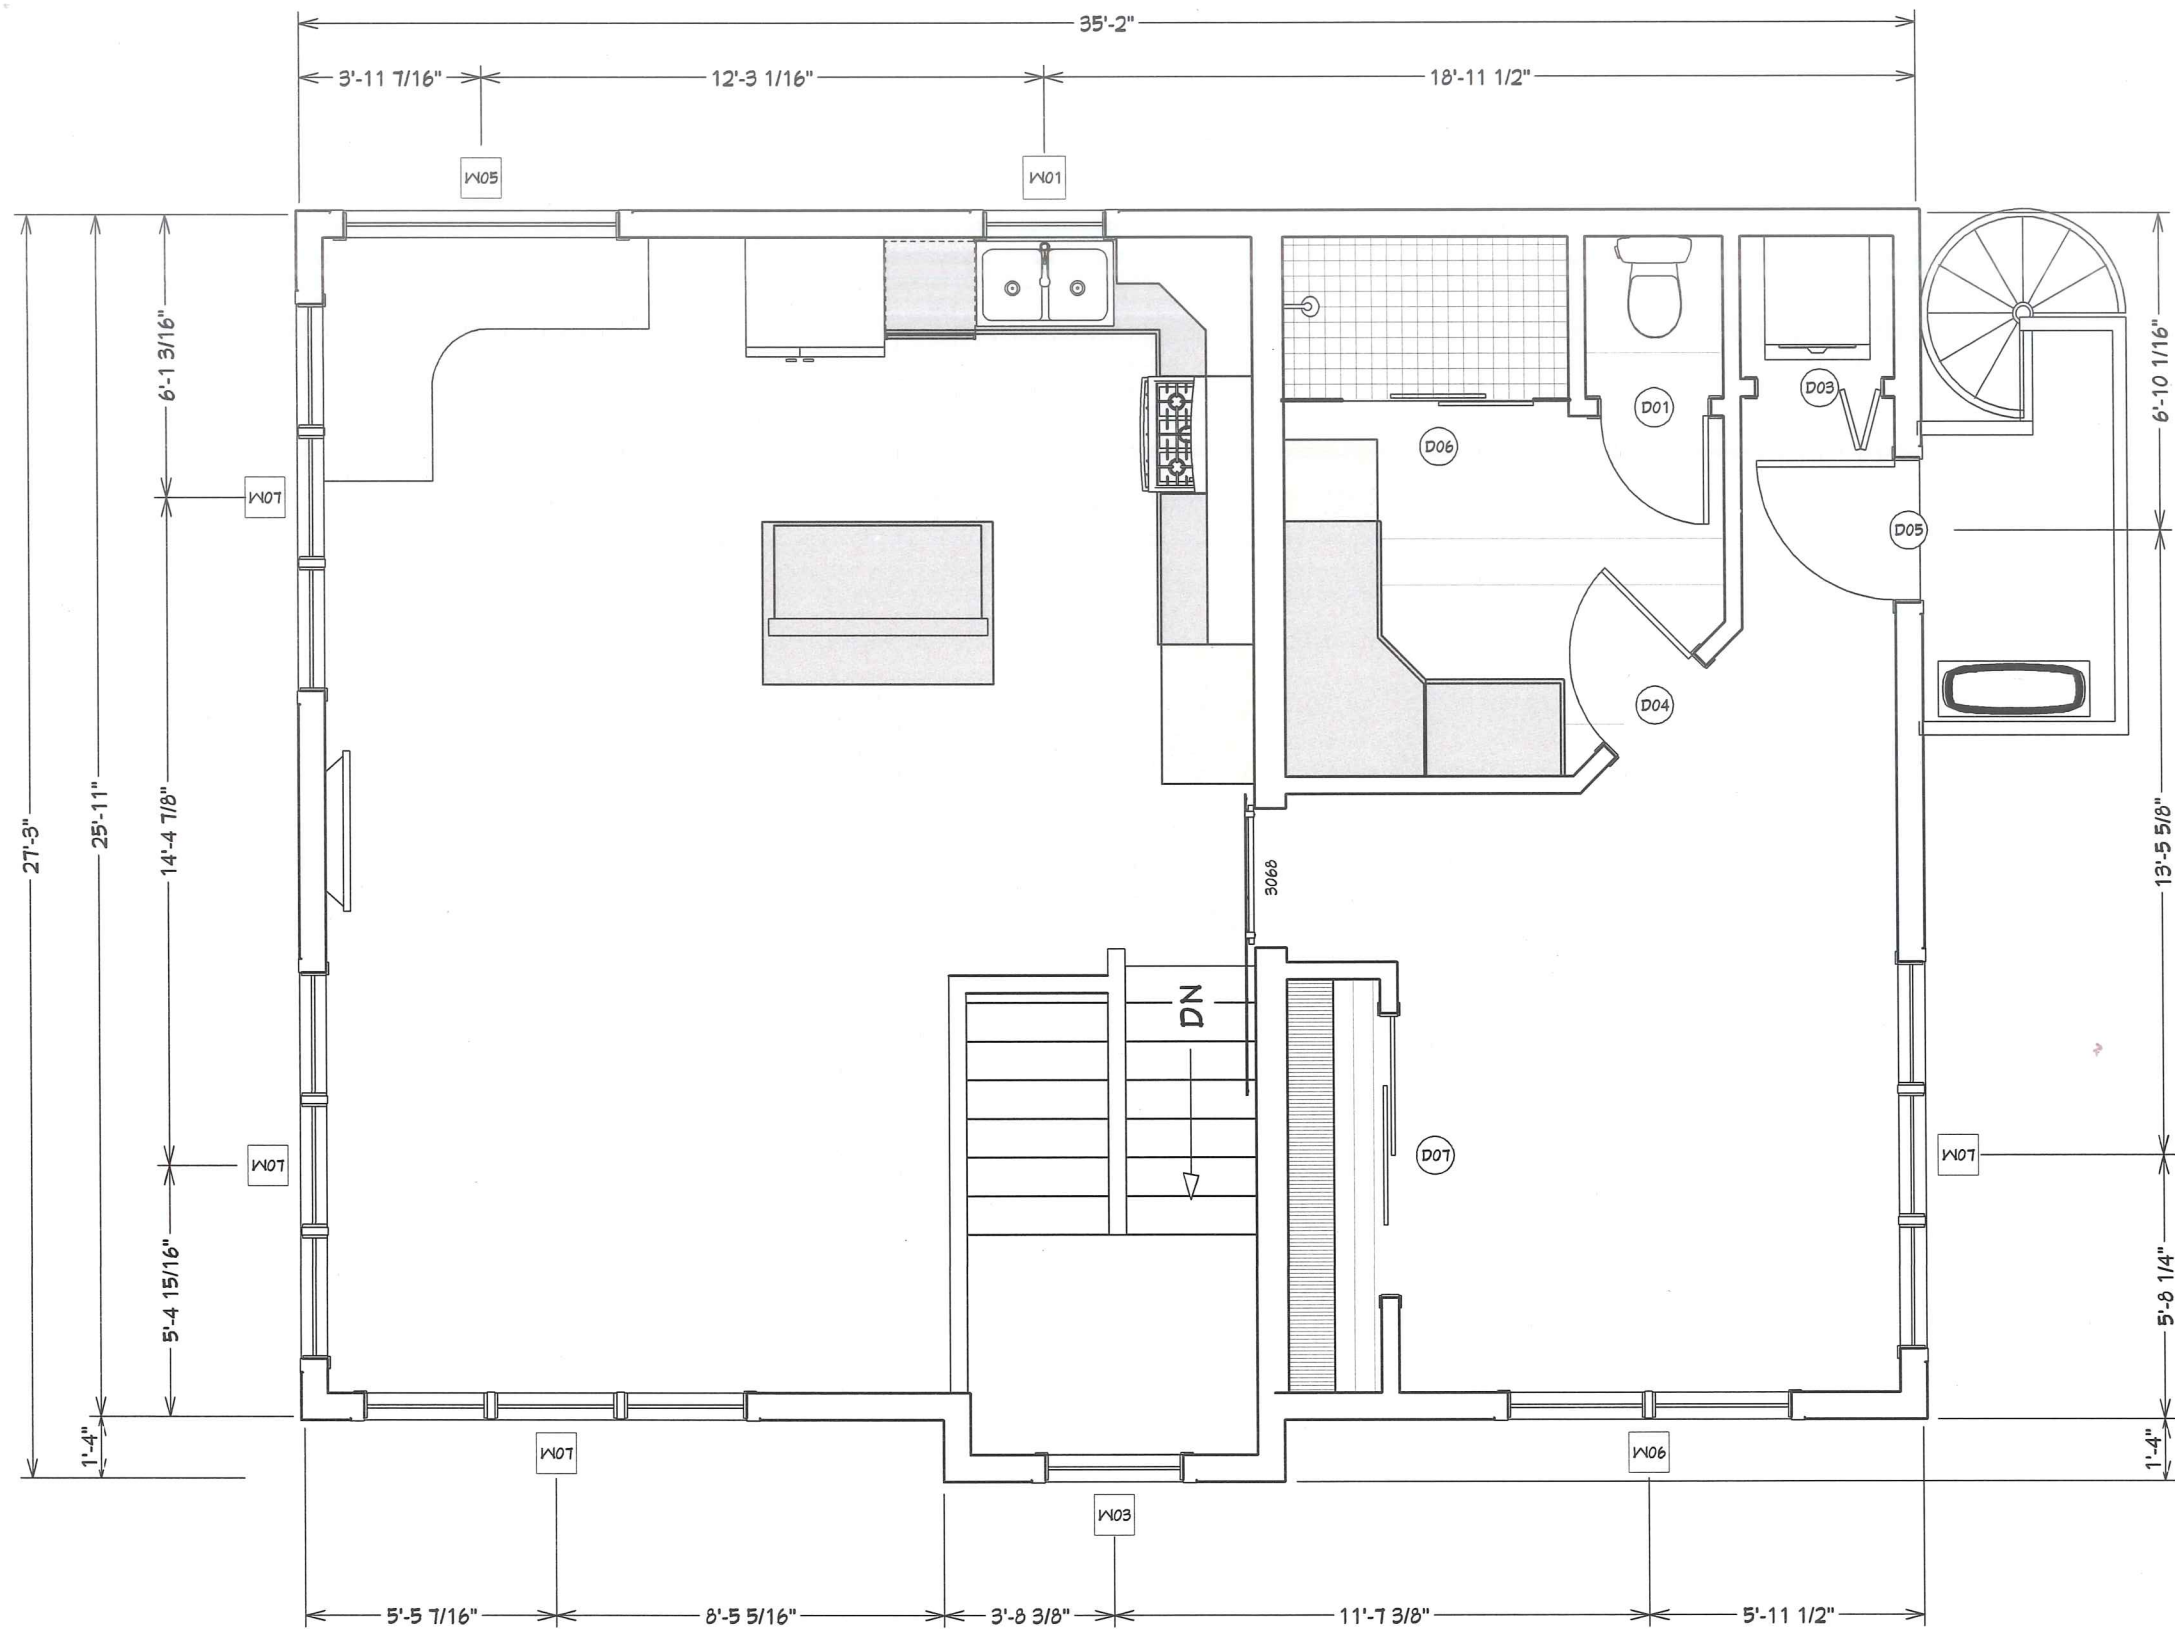

| DOOR SCHEDULE | | | WINDOW SCHEDULE | | | | | | | | |
|---------------|-------|-----|-----------------|----------------|---------|-------------|-------------|----------------------|-----------|------|-----------------------|
| NUMBER | LABEL | QTY | FLOOR SIZE | WIDTH | HEIGHT | R/O | DESCRIPTION | HEADER | THICKNESS | CODE | MANUFACTURER COMMENTS |
| D01 | 2465 | 1 | 3 | 2465 L IN 126" | 77 1/8" | 30"x92 5/8" | NO | HINGED-DOOR F04 | 2X6X93" | (2) | 1 3/8" |
| D02 | 3065 | 1 | 1 | 3065 R EX 136" | 80" | 38"x65" | YES | EXT. HINGED-DOOR E01 | 2X6X41" | (2) | 1 3/8" |
| D03 | 2865 | 1 | 3 | 2865 L 132" | 80" | 34"x62 1/2" | 2 | DR. BIFOLD-LOWVERED | 2X6X91" | (2) | 1 3/8" |
| D04 | 2865 | 1 | 3 | 2865 R IN 132" | 80" | 34"x62 1/2" | NO | HINGED-DOOR F04 | 2X6X91" | (2) | 1 3/8" |
| D05 | 3065 | 1 | 3 | 3065 R EX 136" | 80" | 38"x65" | YES | EXT. HINGED-DOOR E23 | 2X6X41" | (2) | 1 3/8" |
| D06 | 4265 | 1 | 3 | 4265 R IN 150" | 77 1/8" | 57"x19 5/8" | NO | SLIDER-SLAB | 2X6X95" | (2) | 1 3/8" |
| D07 | 6065 | 1 | 3 | 6065 R IN 172" | 80" | 74"x92 1/2" | NO | SLIDER-DOOR F04 | 2X10X11" | (2) | 1 3/8" |

| WINDOW SCHEDULE | | | WINDOW SCHEDULE | | | | | | | | |
|-----------------|--------|-----|-----------------|------------|--------|----------|-------------|-------------|-----------|------|-----------------------|
| NUMBER | LABEL | QTY | FLOOR SIZE | WIDTH | HEIGHT | R/O | DESCRIPTION | HEADER | THICKNESS | CODE | MANUFACTURER COMMENTS |
| W01 | 2840DH | 1 | 3 | 2840DH 52" | 48" | 33"x49" | NO | DOUBLE HUNG | 2X6X40" | (2) | |
| W02 | 3040DH | 1 | 3 | 3040DH 56" | 48" | 37"x49" | YES | DOUBLE HUNG | 2X6X40" | (2) | |
| W03 | 6014FX | 1 | 3 | 6014FX 72" | 16" | 15"x11" | NO | FIXED GLASS | 2X10X16" | (2) | |
| W04 | 6210MD | 1 | 3 | 6210 74" | 12" | 15"x13" | NO | MULLED UNIT | 2X10X18" | (2) | |
| W07 | 8440MD | 4 | 3 | 8440 100" | 48" | 101"x49" | YES | MULLED UNIT | 2X12X104" | (2) | |

VERTICAL WORKS INC
 modular innovations
 3834 E. PIETZ RD.
 OAK CREEK, WI. 53154
 (414) 762-0950 FAX (414) 762-0855
 www.verticalworksinc.com

THIS DOCUMENT CONTAINS CONFIDENTIAL OR PROPRIETARY INFORMATION OF VERTICAL WORKS, INC. NEITHER THIS DOCUMENT NOR THE INFORMATION HEREIN IS TO BE REPRODUCED, COPIED, EITHER IN WHOLE OR IN PART EXCEPT AS SPECIFICALLY AUTHORIZED BY VERTICAL WORKS, INC. CONTACT MANUFACTURE FOR FURTHER INSTRUCTION.

CUSTOMER: JOE MARTINO
 DEALER: VERTICAL WORKS, INC.
 MODEL: CUSTOM THIRD STORY ADDITION
 QUOTE: 0096-M SERIAL:
 DRAWN BY: JLK

CUSTOMER PACKAGE

DATES

| | |
|---------------|--------|
| ORIGINAL PLAN | 3-3-17 |
| 3-26-17 | |
| 4-25-17 | |
| 5-21-17 | |
| 5-27-17 | |
| 6-11-17 | |
| 6-17-17 | |
| 7-3-17 | |


12
 SCALE: 1/4" = 1'

DATE: _____ CUSTOMER SIGNATURE: _____ CUSTOMER SIGNATURE: _____ DEALER SIGNATURE: _____

DOOR & WINDOW SCHEDULE - 3RD FLOOR

ELECTRICAL KEY

| FIXTURE | MODEL |
|-----------------------------|---|
| SINGLE POLE SWITCH | STD WHITE |
| STACKED SWITCH | STD WHITE |
| THREE WAY SWITCH | STD WHITE |
| FOUR WAY SWITCH | STD WHITE |
| DIMMER SWITCH | STD WHITE |
| DUPLEX OUTLET | STD WHITE |
| DUPLEX OUTLET (SPLIT WIRED) | STD WHITE |
| DISHWASHER OUTLET/SWITCH | STD WHITE |
| GFI DUPLEX OUTLET | STD WHITE |
| WEATHER PROOF OUTLET | STD EXTERIOR OUTLET |
| FLOOR OUTLET | STD WHITE |
| 220 OUTLET | STD WHITE |
| FLUSH MOUNT HALL LIGHT | SEAGULL T1063-962 |
| FLUSH MOUNT BEDROOM LIGHT | SEAGULL T1064-962 |
| RECESSED LIGHT | ELITE B261C-AT W/ELITE B630 |
| | WHITE BAFFLE TRIM RING |
| LIGHT FOR DAMP CONDITIONS | STD WHITE |
| SCONCE LIGHT | SEAGULL 4148-15 |
| VANITY LIGHT | SEAGULL 44062-962 |
| HANGING LIGHT | BY OWNER |
| EXTERIOR LIGHT | (F) SEAGULL 8458-12 (R) SEAGULL 8457-12 |
| 100 FAN / LIGHT COMBO | BROAN 676 |
| CEILING FAN BOX ONLY | STD HIGH STRENGTH CEILING BOX |
| CEILING FAN INSTALLED | STD HIGH STRENGTH CEILING BOX |
| SMOKE DETECTOR | STD WHITE |
| SMOKE/CARBON | STD WHITE |
| CABLE / TV / PHONE | STD WHITE |
| THERMOSTAT | STD WHITE |
| DOORBELL | STD |
| CHIME | STD |

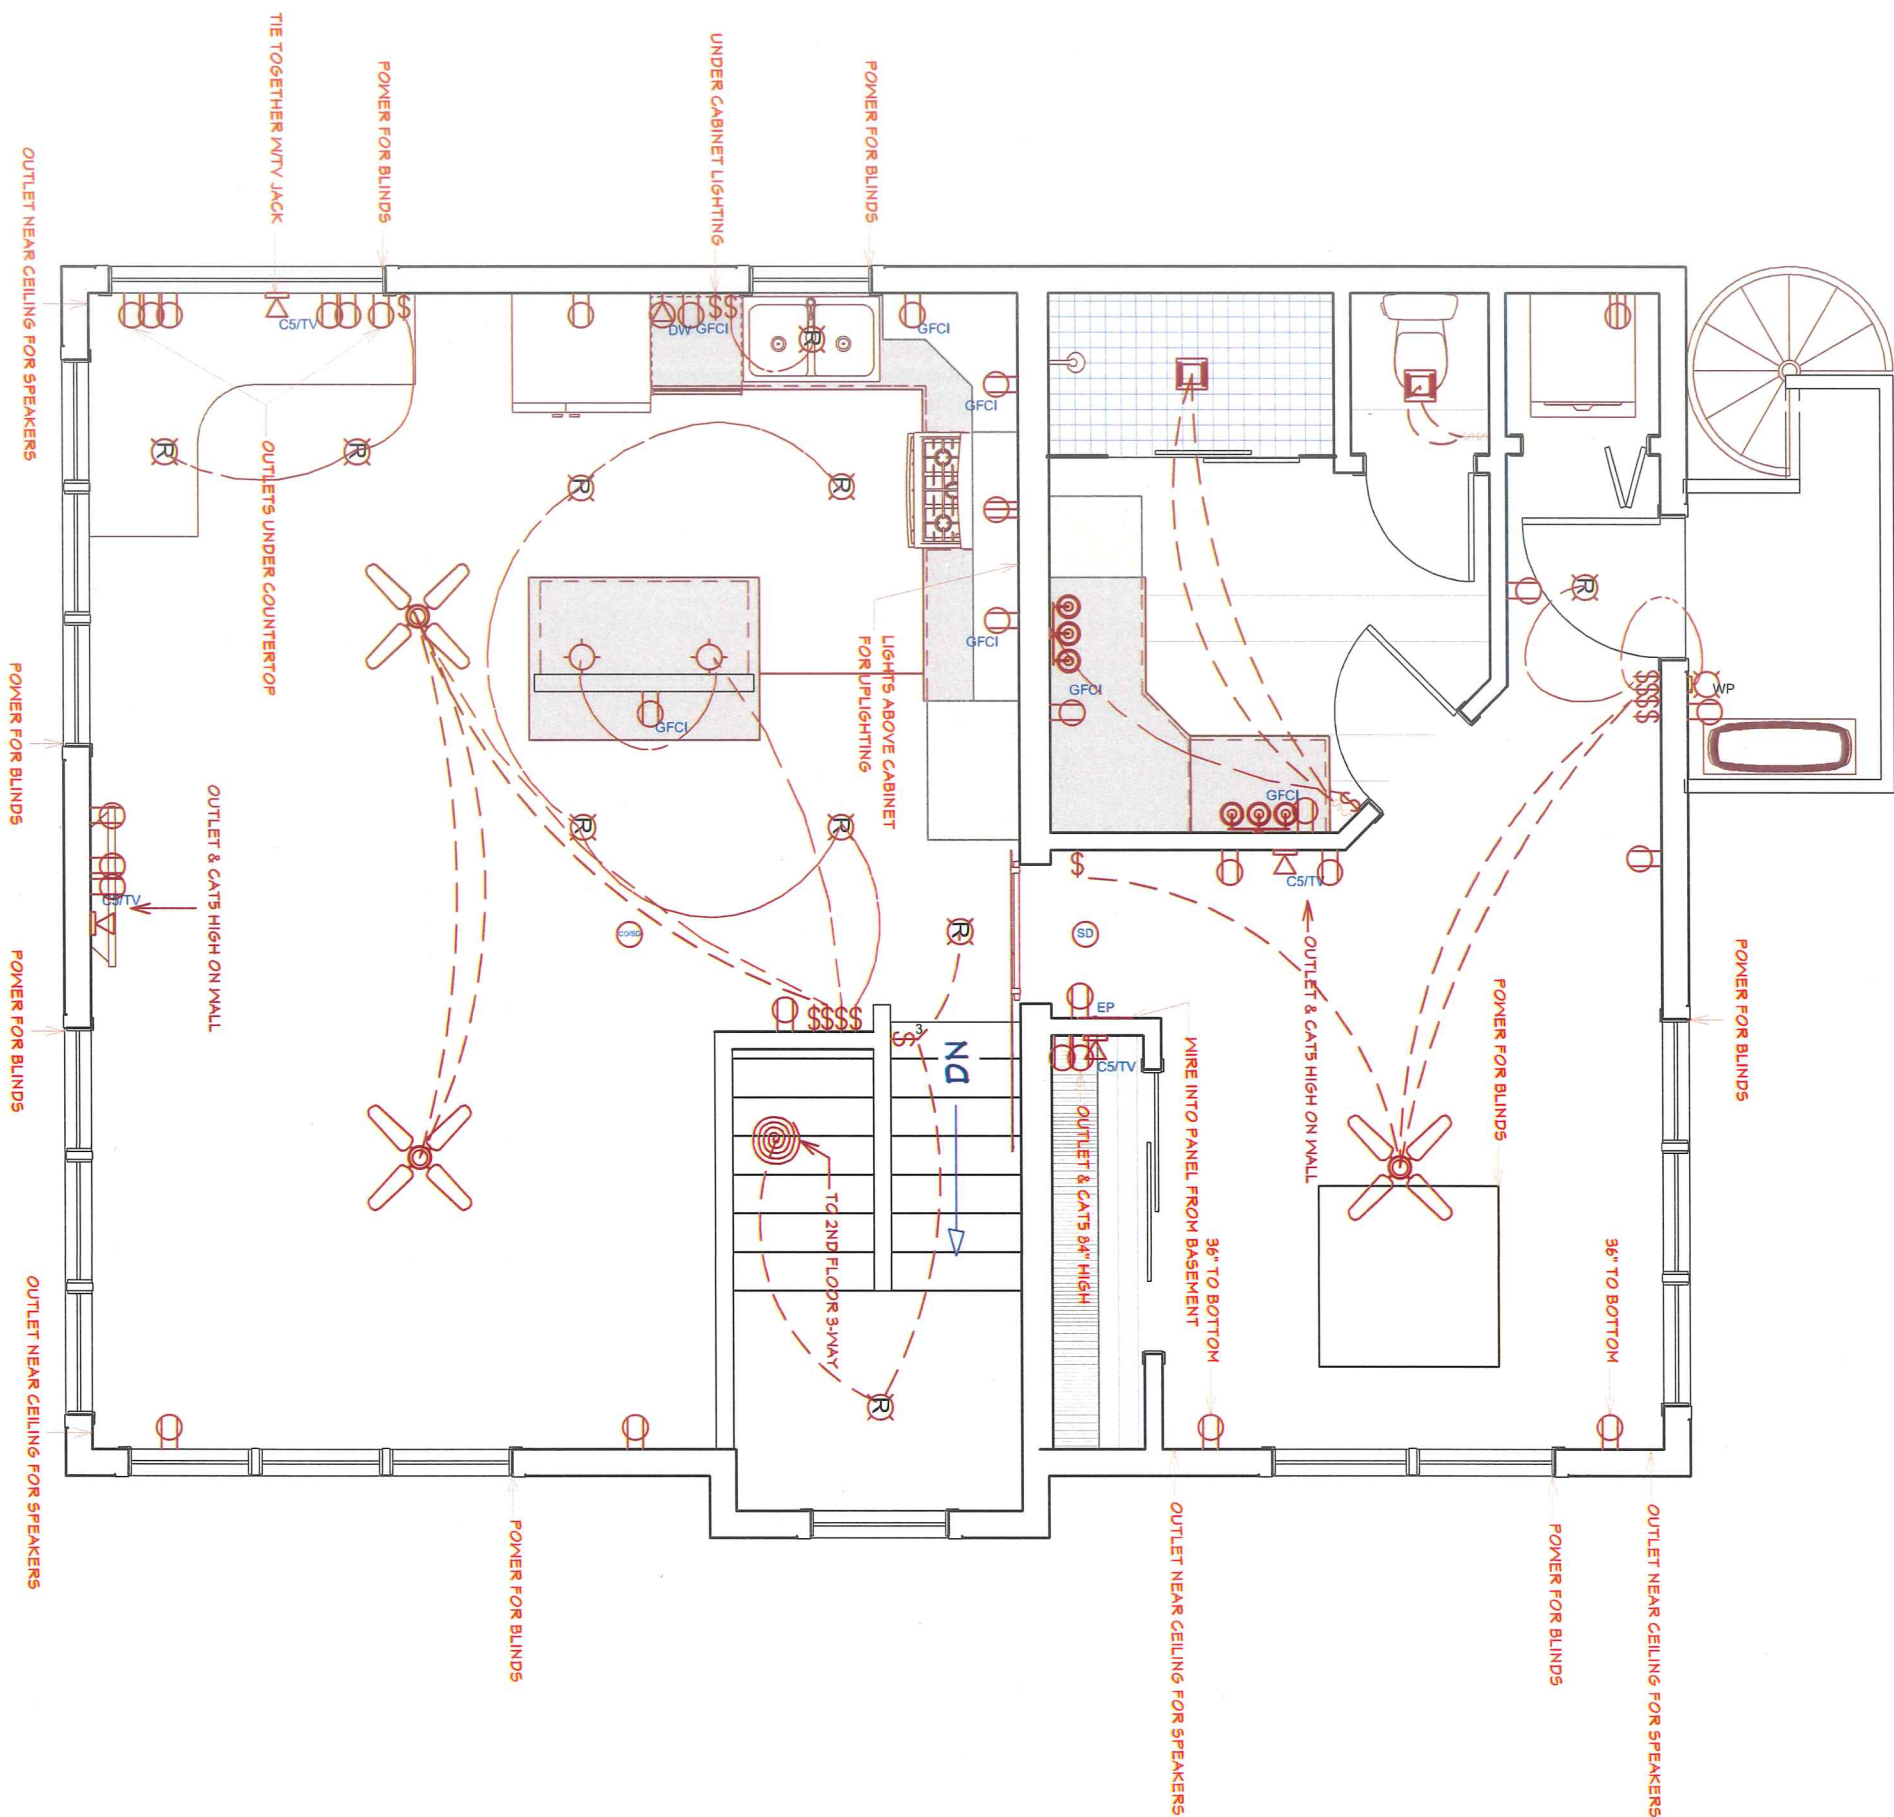

THIRD FLOOR ELECTRICAL PLAN

VERTICAL WORKS INC.
 modular innovations
 3834 E. PUETZ RD.
 OAK CREEK, WI 53154
 (414) 762-0950 FAX (414) 762-0955
 www.verticalworksinc.com

THIS DOCUMENT CONTAINS CONFIDENTIAL OR PROPRIETARY INFORMATION OF VERTICAL WORKS, INC. NEITHER THIS DOCUMENT NOR THE INFORMATION HEREIN IS TO BE REPRODUCED, COPIED, DISCLOSED, OR IN ANY MANNER USED OR IN PART EXCEPT AS SPECIFICALLY AUTHORIZED BY VERTICAL WORKS, INC. CONTACT MANUFACTURE FOR FURTHER INSTRUCTION.

CUSTOMER: JOE MARTINO
 DEALER: VERTICAL WORKS, INC.
 MODEL: CUSTOM THIRD STORY ADDITION
 QUOTE: 0096-M SERIAL:
 DRAWN BY: JLK

CUSTOMER PACKAGE

DATES
 ORIGINAL PLAN
 3-3-17

| |
|---------|
| 3-26-17 |
| 4-25-17 |
| 5-21-17 |
| 5-27-17 |
| 6-11-17 |
| 6-17-17 |
| 7-3-17 |

13

SCALE: 1/4"=1'

DATE: _____ CUSTOMER SIGNATURE: _____ CUSTOMER SIGNATURE: _____ DEALER SIGNATURE: _____

KITCHEN CABINET ELEVATIONS



THIS DOCUMENT CONTAINS CONFIDENTIAL OR PROPRIETARY INFORMATION OF VERTICAL WORKS, INC. NEITHER THIS DOCUMENT NOR THE INFORMATION HEREIN IS TO BE REPRODUCED, DISTRIBUTED, USED OR IN ANY MANNER, AS SPECIFICALLY AUTHORIZED BY VERTICAL WORKS, INC. CONTACT MANUFACTURE FOR FURTHER INSTRUCTION.

CUSTOMER: JOE MARTINO
DEALER: VERTICAL WORKS, INC.
MODEL: CUSTOM THIRD STORY ADDITION
QUOTE: 00916-M SERIAL:
DRAWN BY: JLK


CUSTOMER PACKAGE

DATES
ORIGINAL PLAN
3-3-17


| | |
|---------|--|
| 3-26-17 | |
| 4-25-17 | |
| 5-21-17 | |
| 5-27-17 | |
| 6-11-17 | |
| 6-17-17 | |
| 7-3-17 | |

14

SCALE: 1/2"=1'

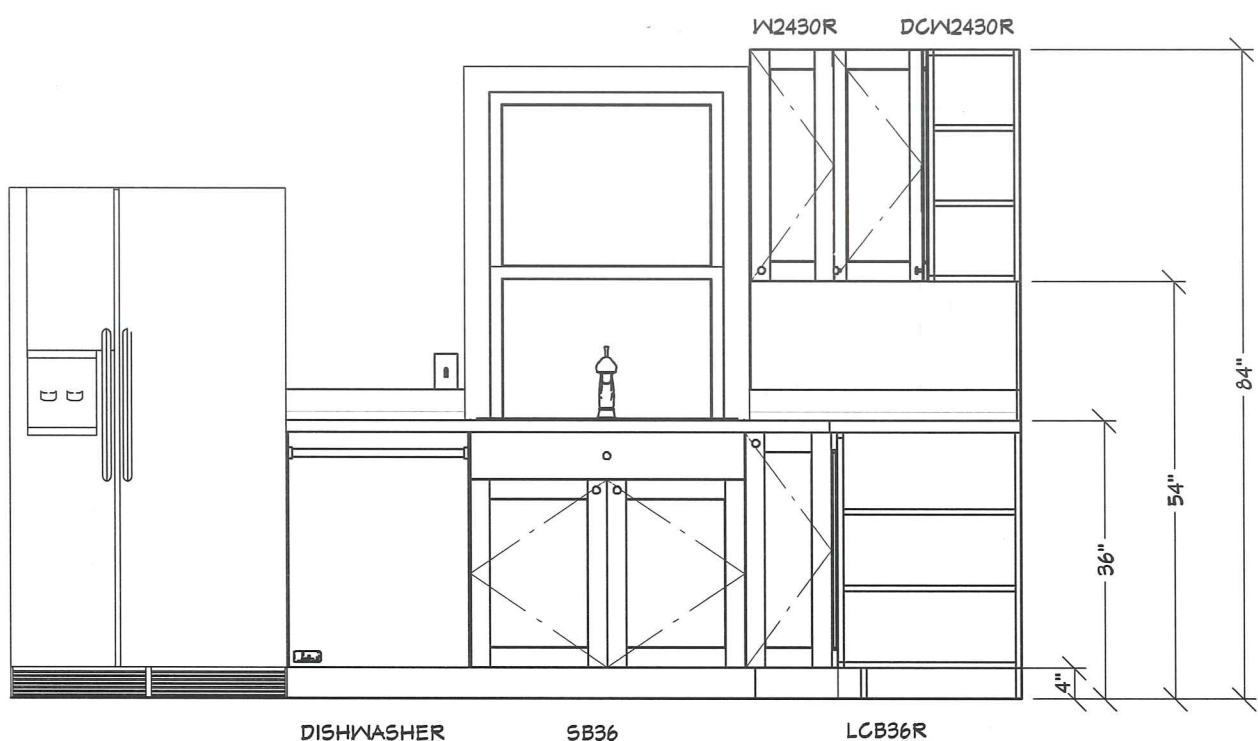

KITCHEN
(SINK ELEVATION)

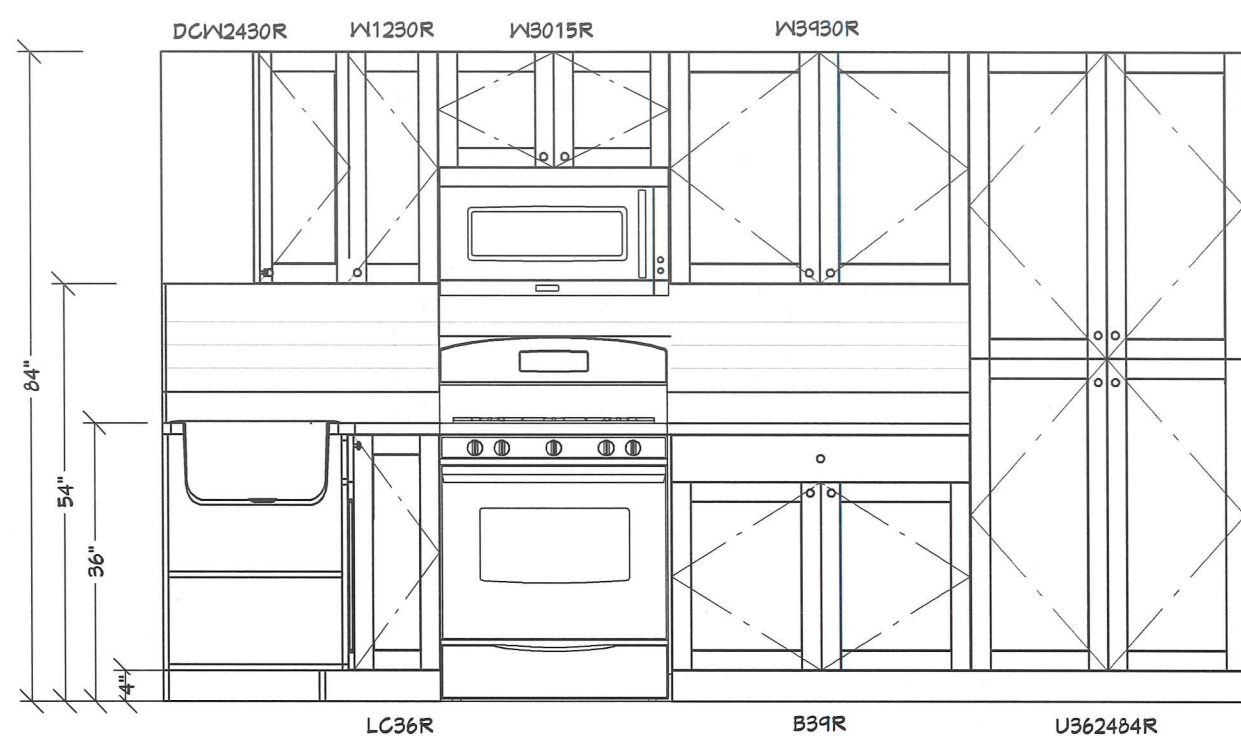


KITCHEN
(RANGE ELEVATION)

DATE: _____ CUSTOMER SIGNATURE: _____ CUSTOMER SIGNATURE: _____ DEALER SIGNATURE: _____



1DB3630

MASTER BATH
(MAKE UP TABLE ELEVATION)

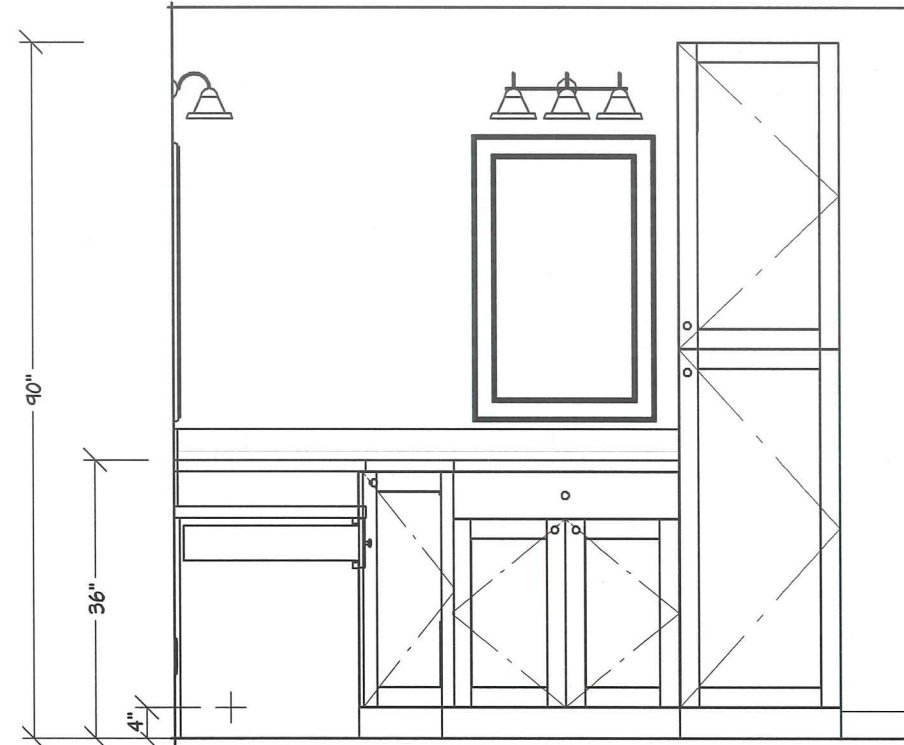


DCB36R

SB30

U212490R

MASTER BATH
(VANITY ELEVATION)

MASTER BATH CABINET ELEVATIONS

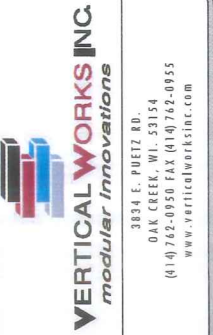

THIS DOCUMENT CONTAINS CONFIDENTIAL OR PROPRIETARY INFORMATION OF VERTICAL WORKS, INC. NEITHER THIS DOCUMENT NOR THE INFORMATION HEREIN IS TO BE REPRODUCED, COPIED, EITHER IN WHOLE OR IN PART EXCEPT AS SPECIFICALLY AUTHORIZED BY VERTICAL WORKS, INC. CONTACT MANUFACTURE FOR FURTHER INSTRUCTION.

CUSTOMER: JOE MARTINO
DEALER: VERTICAL WORKS, INC.
MODEL: CUSTOM THIRD STORY ADDITION
QUOTE: 0096-M SERIAL:
DRAWN BY: JLK

CUSTOMER PACKAGE

DATES
ORIGINAL PLAN
3-3-17

| | |
|---------|--|
| 3-26-17 | |
| 4-25-17 | |
| 5-21-17 | |
| 5-27-17 | |
| 6-11-17 | |
| 6-17-17 | |
| 7-3-17 | |


15

SCALE: 1/2"=1'

DATE: _____ CUSTOMER SIGNATURE: _____ CUSTOMER SIGNATURE: _____ DEALER SIGNATURE: _____

PREPARED FOR:

JOE MARTINO
26 N. HANCOCK ST.
MADISON, WI 53703

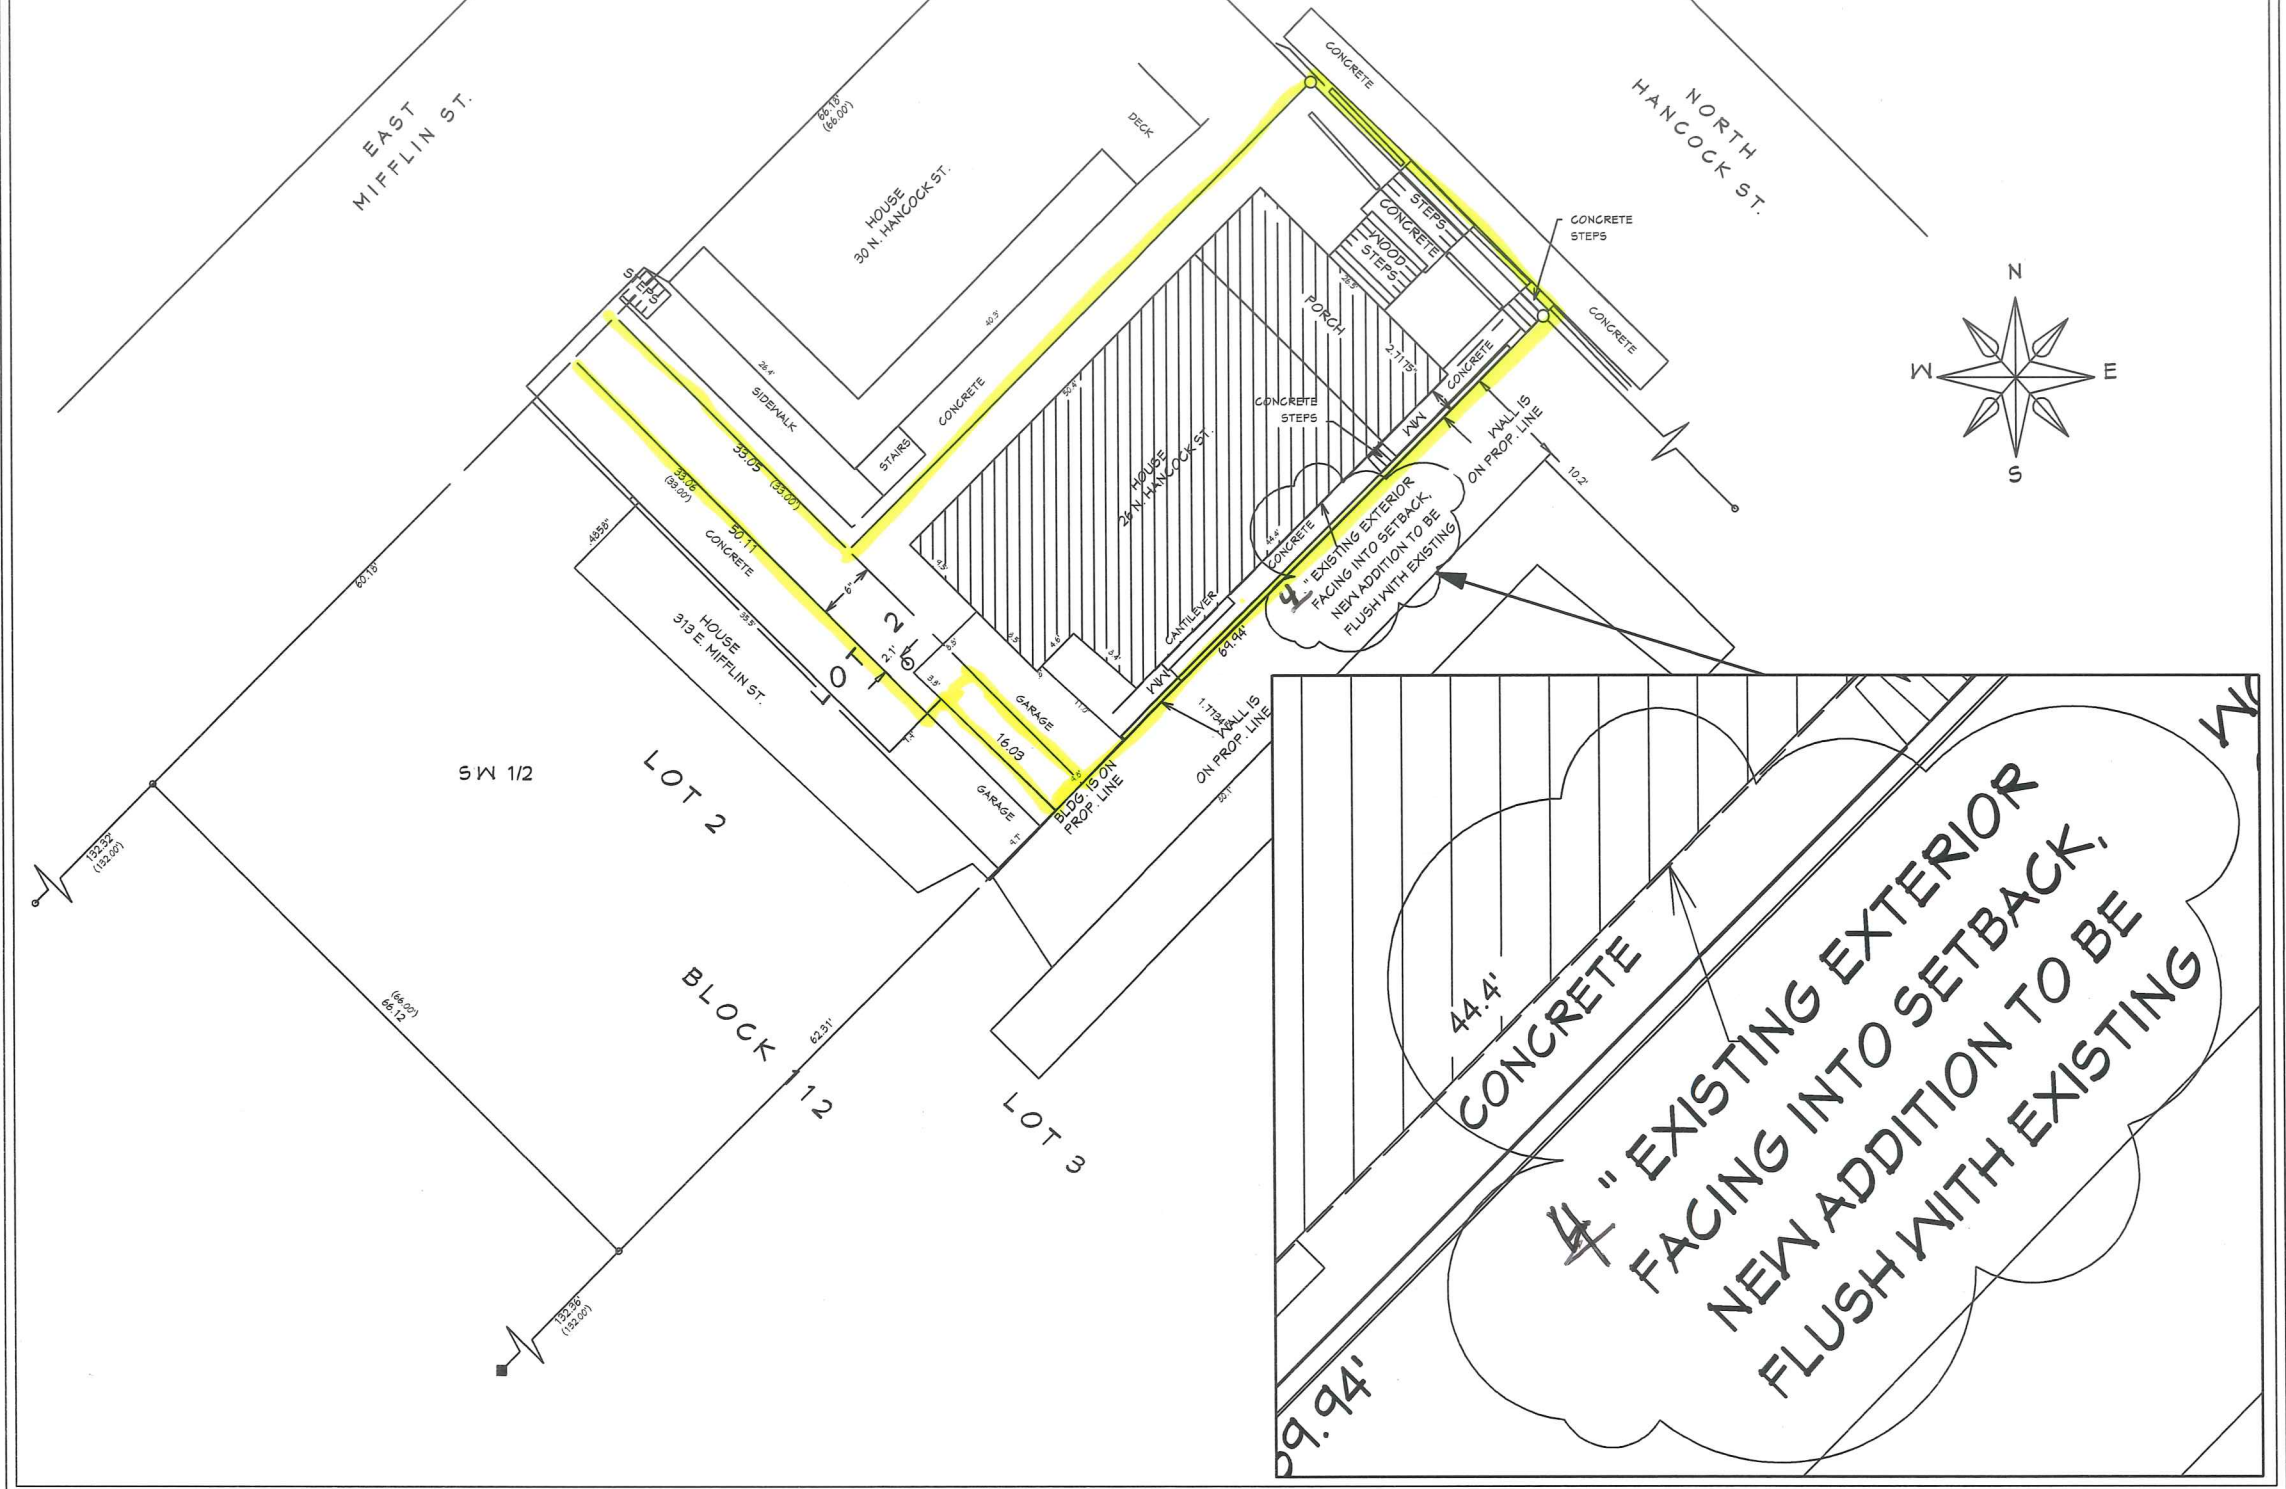

SITE PLAN