

Madison, Wisconsin

INDEX OF SHEETS

SHEET NO. 1	TITLE
SHEET NO. G#-G#	GENERAL NOTES
SHEET NO. O#-O#	OVERVIEW
SHEET NO. R#-R#	REMOVAL PLAN
SHEET NO. P#-P#	SITE PLAN
SHEET NO. G#-G#	GRADING PLAN
SHEET NO. L#-L#	LIGHTING PLAN

CITY OF MADISON

CITY ENGINEERING DIVISION

DEPARTMENT OF PUBLIC WORKS

PLAN OF PROPOSED IMPROVEMENT


EAST-WEST BUS RAPID TRANSIT EARLY WORKS

CITY PROJECT NO. 12777

CONTRACT NO. #####

MUNIS NO. #####


60% PLANS
(MARCH 31, 2022)
NOT FOR CONSTRUCTION

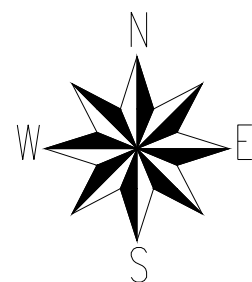

CONVENTIONAL SIGNS
 FIELD VERIFY ALL UTILITY LOCATIONS

COMBUSTIBLE FLUIDS

BURIED ELECTRIC	— E —
FIBER OPTIC	— FO —
GAS	— G —
OVERHEAD ELECTRIC	— OH —
POWER POLE	□
STORM SEWER	— SS —
SANITARY SEWER	— SAN —
COMMUNICATIONS	— TV —
WATER	— W —

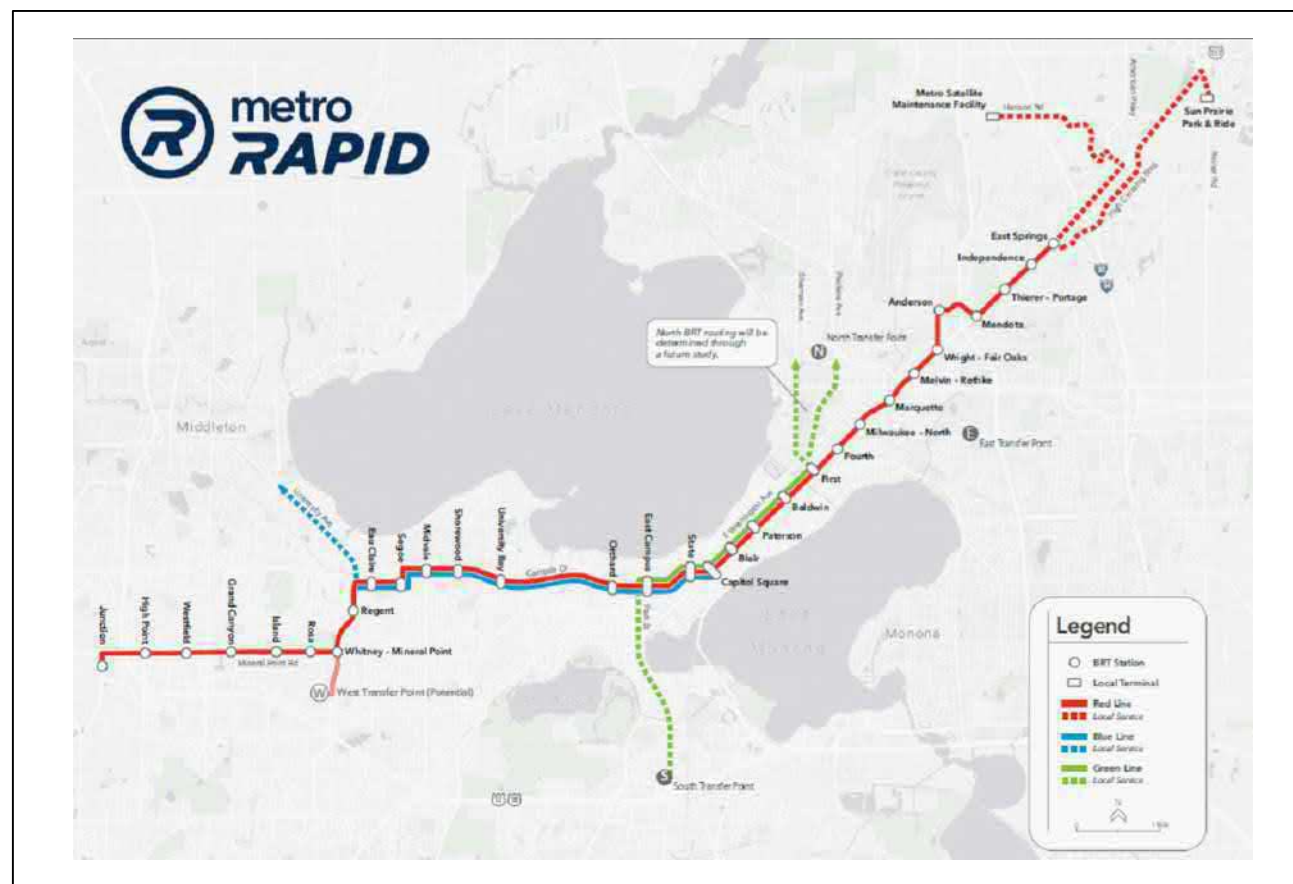

STREET GRADES AND GEOMETRICS
 DESIGNED BY: BRIAN ANDREAS

ELECTRICAL PLAN
 DESIGNED BY: TYLER TKACHUK

PUBLIC IMPROVEMENT PROJECT
 APPROVED

BY THE COMMON COUNCIL
 OF MADISON, WISCONSIN

PUBLIC IMPROVEMENT DESIGN
 APPROVED BY:

City Engineer

Date

MARKING PLAN
 DESIGNED BY: SAMANTHA HERHEIM

STORMWATER
 DESIGNED BY: STEVE PARSE

PLOT SCALE: 1:1

PLOT NAME: ---

REV. DATE: 3/18/2022 4:38 PM

ORIGINATOR: CITY_OF_MADISON



MARK	REVISION	DATE	BY

PROJECT NO: 60631225P
 CITY OF MADISON, DANE COUNTY, WI
 CONTRACT NO: 60631225C

PROJECT OVERVIEW
 BUS RAPID TRANSIT
 CITY OF MADISON



60631225P
 0-1



MARK	REVISION	DATE	BY
60631225P	Designed By: AECOM	2022-03-17	
	Date: 2022-03-17		
			Scale: 1 IN=1000 FT



60631225P
 CITY OF MADISON, DANE COUNTY, WI
 CONTRACT NO: 60631225C



PROJECT OVERVIEW
 BUS RAPID TRANSIT
 CITY OF MADISON

60631225P

0-2

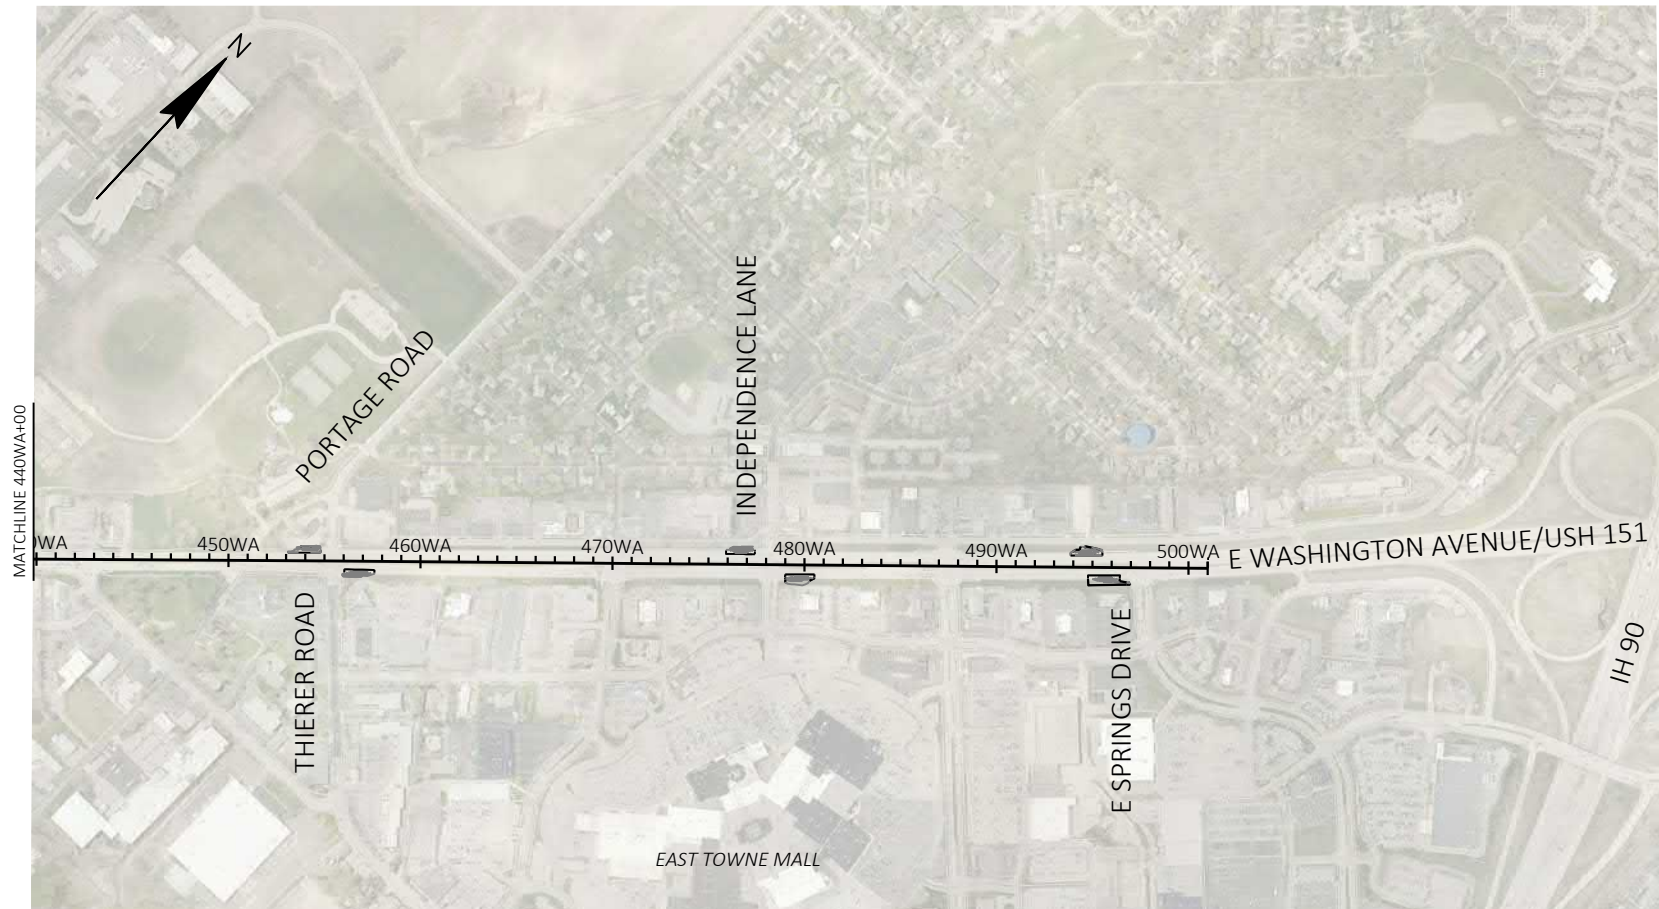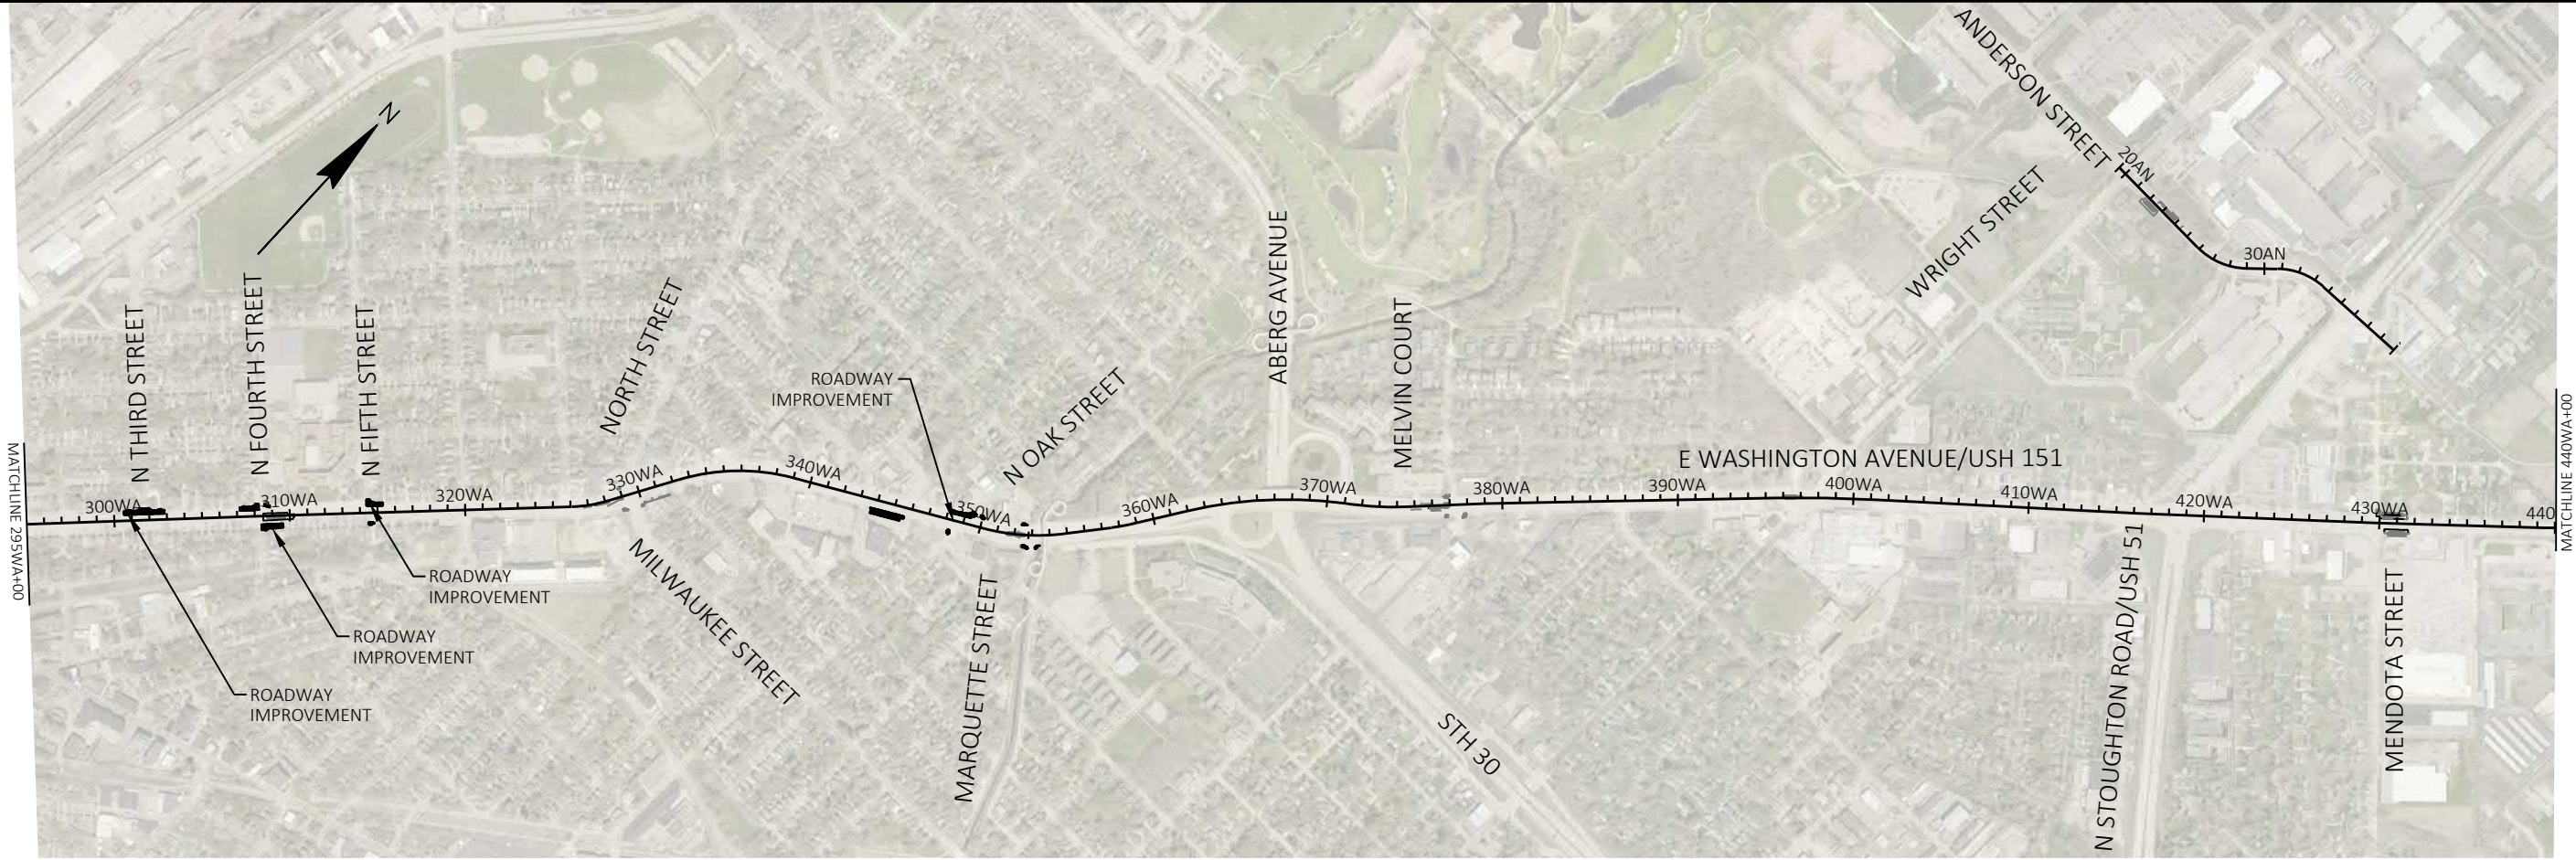

MARK	REVISION	DATE	BY

60631225P
 CITY OF MADISON, DANE COUNTY, WI
 CONTRACT NO: 60631225C

PROJECT OVERVIEW
 BUS RAPID TRANSIT
 CITY OF MADISON

60631225P
 0-3