



2014/05/21




2014/05/21




2014/05/21




2014/05/21

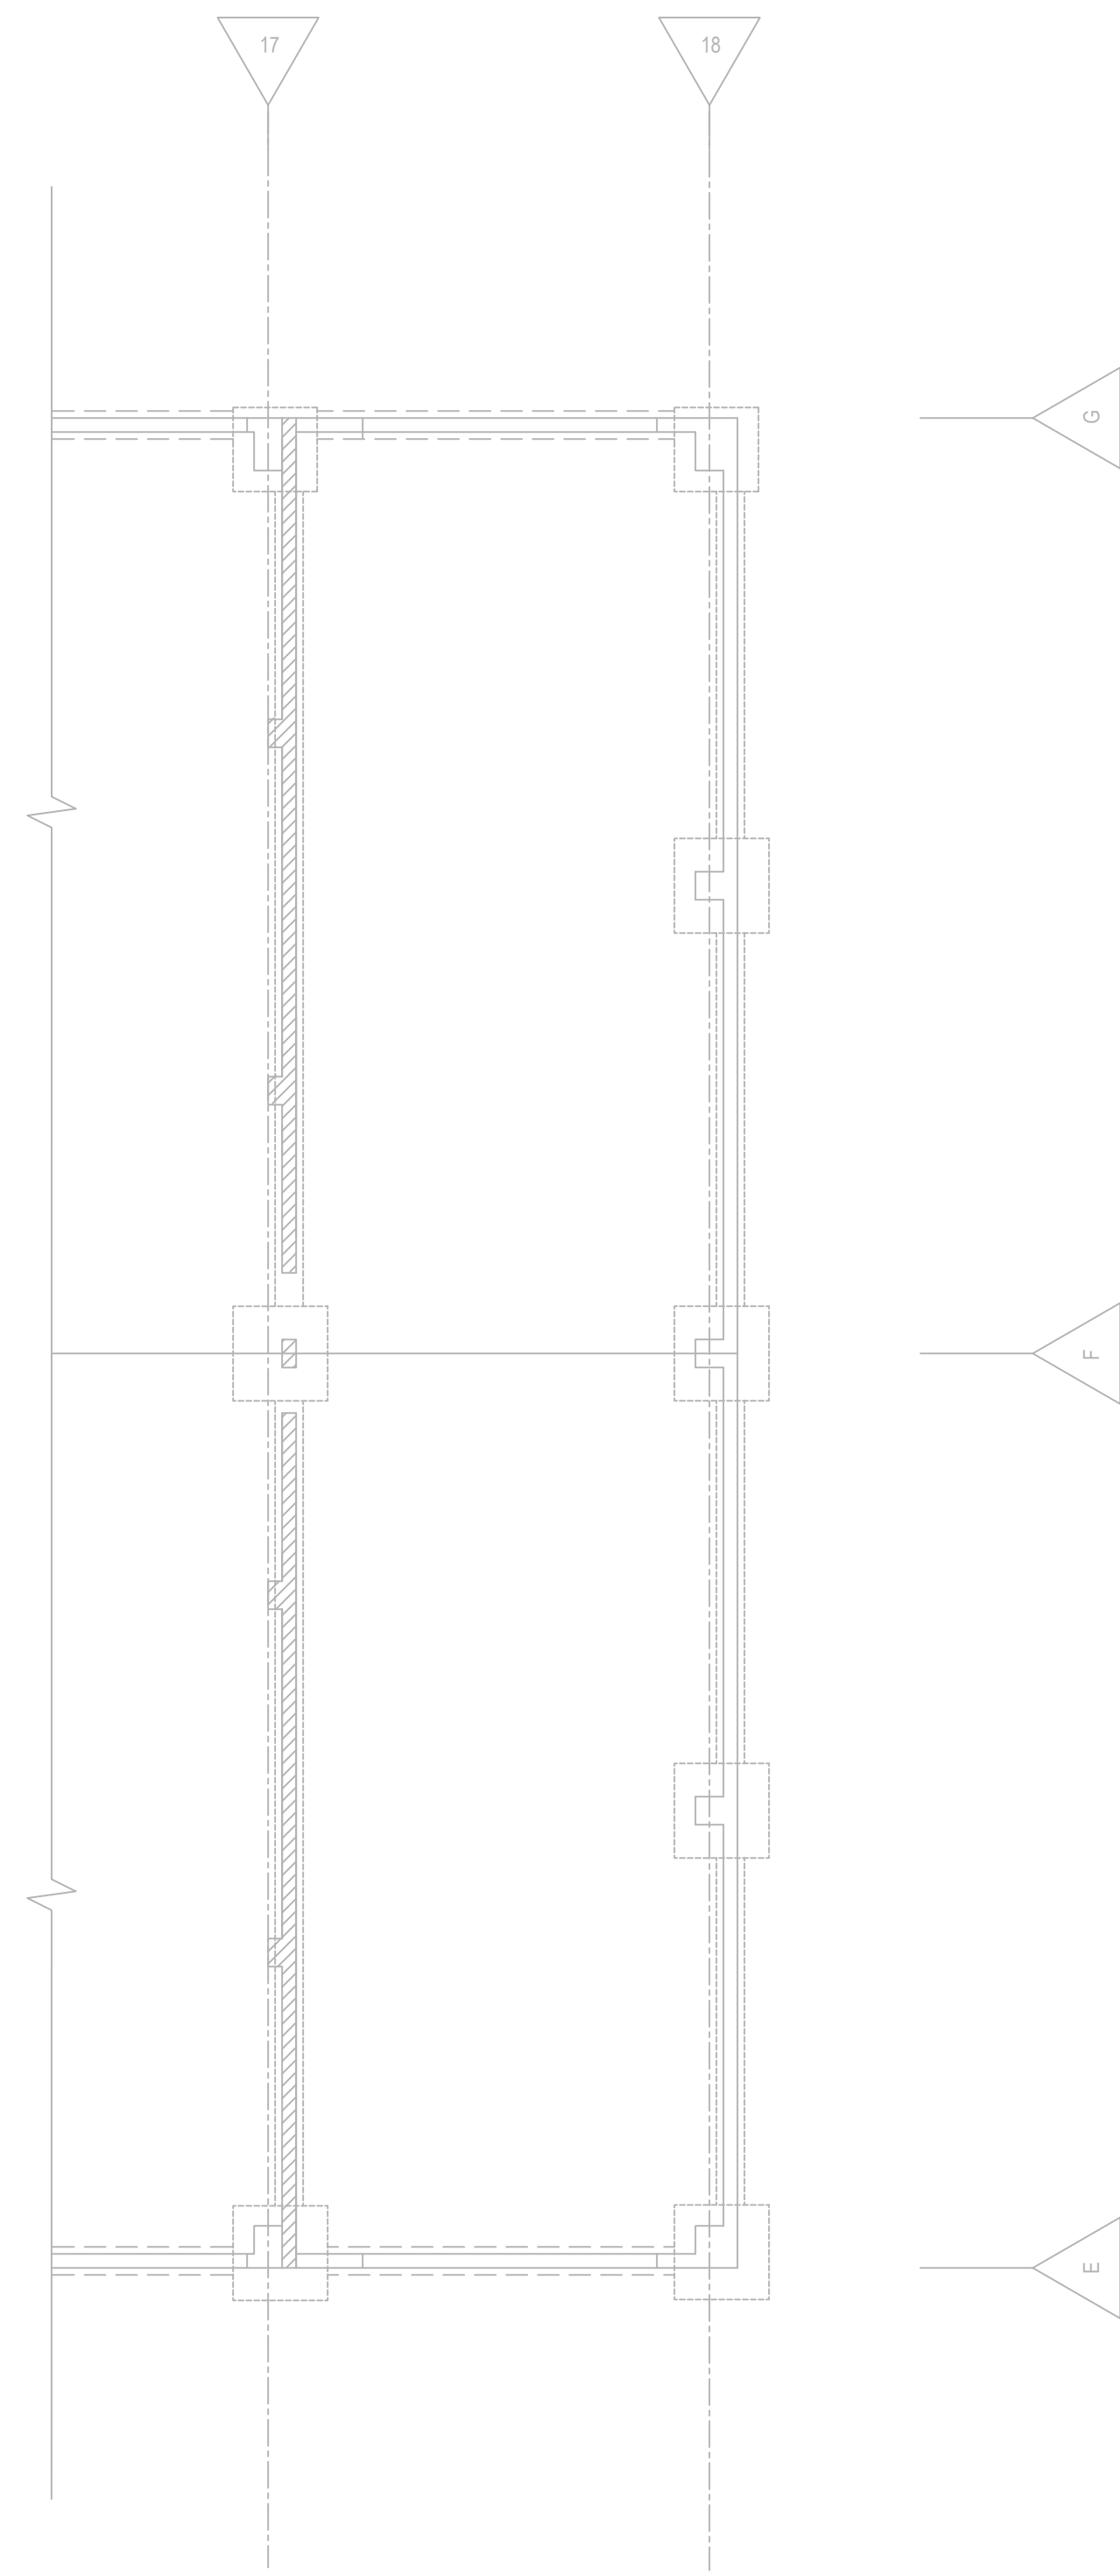

3 FLOOR PLAN - PLUMBING
 P200 SCALE: 1/8"=1'-0"

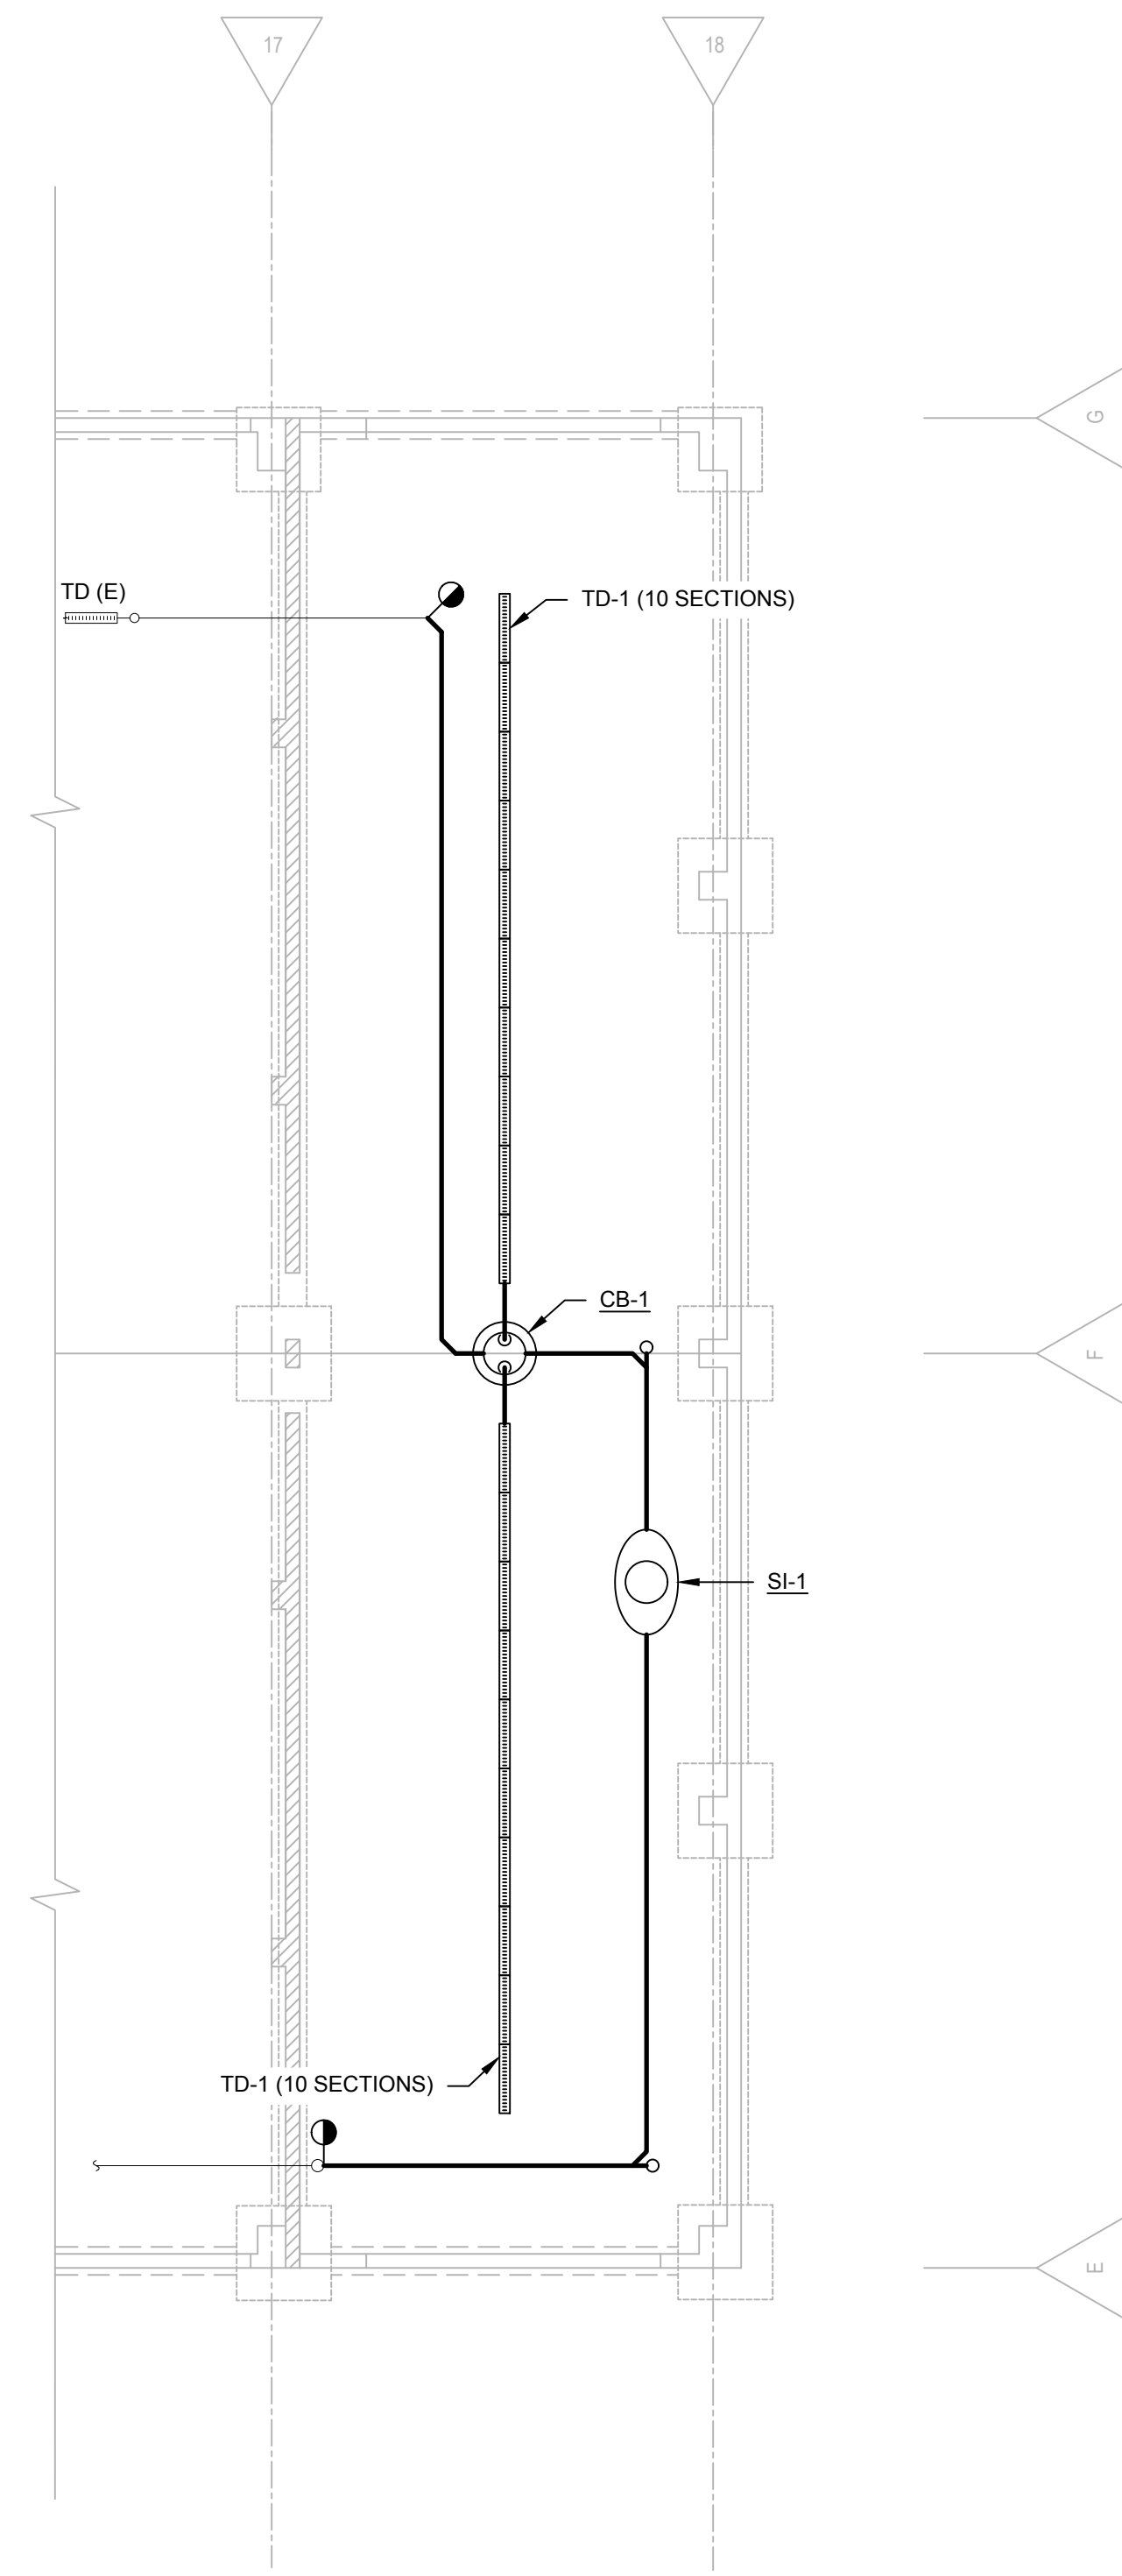

2 UNDERFLOOR PLAN - PLUMBING
 P200 SCALE: 1/8"=1'-0"

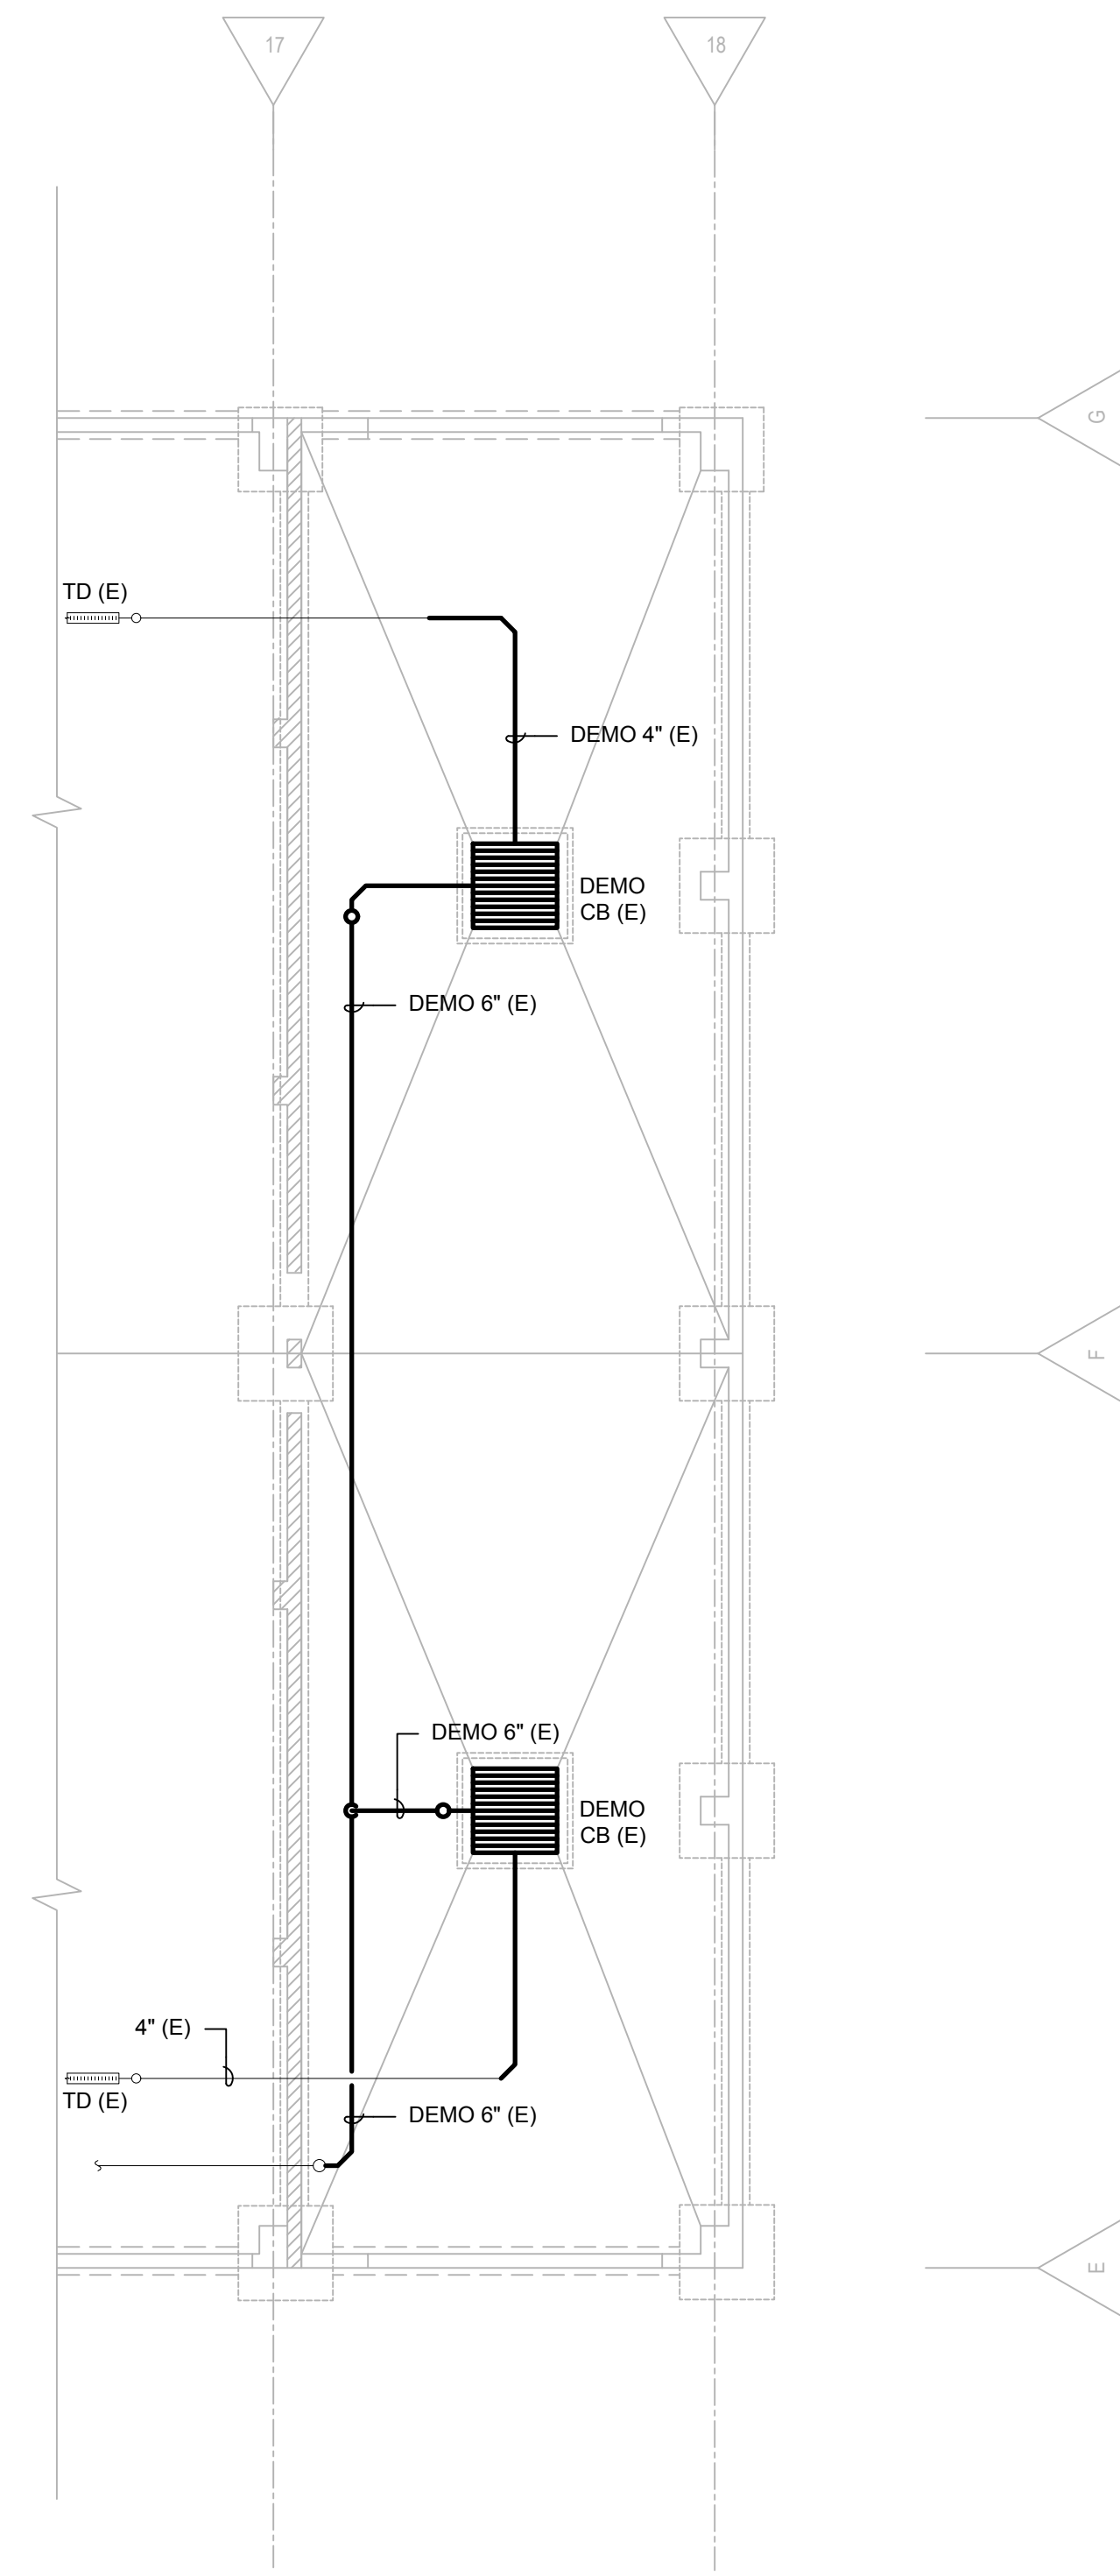

1 DEMOLITION UNDERFLOOR PLAN - PLUMBING
 P200 SCALE: 1/8"=1'-0"

ISSUED

REVISIONS / ADDENDA

PROJECT # : 160091
 DRAWN : JDR
 CHECKED : CMG
 DATE : XX/XX/XX
 PHASE : PR

PROJECT
 CITY OF MADISON -
 WASH BAY FLOOR
 REPLACEMENT AND
 REPAIRS

FLOOR PLANS -
 PLUMBING

P200