


# EXHIBIT B

(Not to scale)

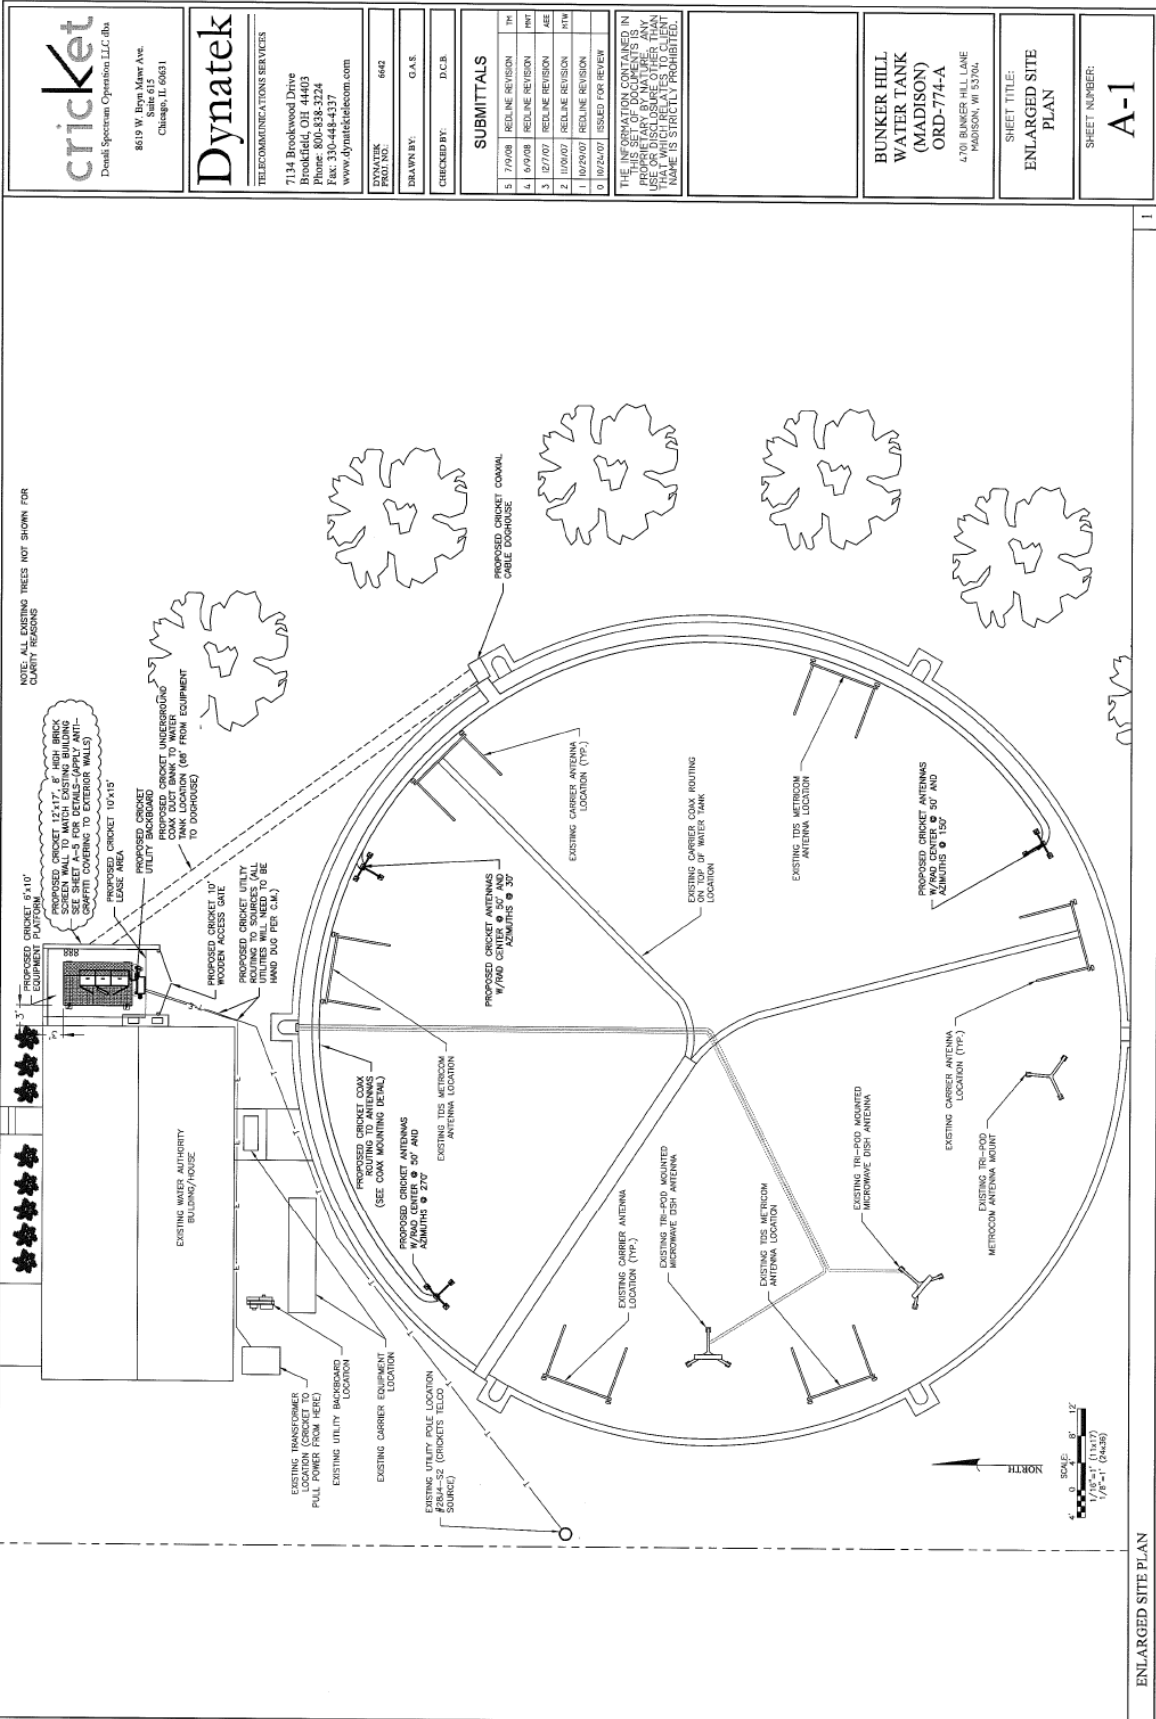

**cricket**  
Duck Spectrum Operations LLC dba

8619 W. Bryn Mawr Ave.  
Suite 610  
Chicago, IL 60631

**Dynatek**

TELECOMMUNICATIONS SERVICES  
7134 Brookwood Drive  
Brookfield, OH 44003  
Phone: 800-838-3324  
Fax: 330-448-4337  
www.dynatektelecom.com

PROJECT NO: 6642

DRAWN BY: G.A.S.

CHECKED BY: D.C.B.

SUBMITTALS	
5	7/20/08 REVISION
4	6/27/08 REVISION
3	12/7/07 REVISION
2	1/29/07 REVISION
1	10/26/07 REVISION
0	10/24/07 ISSUED FOR REVIEW

THE INFORMATION CONTAINED IN THIS SET OF DOCUMENTS IS FOR INFORMATION ONLY. IT IS NOT TO BE USED FOR ANY OTHER PURPOSE WITHOUT THE WRITTEN CONSENT OF THE ENGINEER. THE ENGINEER'S LIABILITY IS LIMITED TO THE PROFESSIONAL SERVICES PROVIDED AND IS NOT TO BE EXTENDED TO ANY OTHER PURPOSES. THE USER SHALL BE RESPONSIBLE FOR OBTAINING ALL NECESSARY PERMITS AND APPROVALS FROM THE APPROPRIATE AGENCIES. THE USER SHALL BE RESPONSIBLE FOR OBTAINING ALL NECESSARY PERMITS AND APPROVALS FROM THE APPROPRIATE AGENCIES. THE USER SHALL BE RESPONSIBLE FOR OBTAINING ALL NECESSARY PERMITS AND APPROVALS FROM THE APPROPRIATE AGENCIES.

**BUNKER HILL WATER TANK (MADISON) ORD-774-A**  
620 BUNKER HILL LANE  
MADISON, WI 53704

SHEET TITLE:  
**ENLARGED SITE PLAN**

SHEET NUMBER:  
**A-1**

ENLARGED SITE PLAN