




knothe • bruce
ARCHITECTS

Phone: 8401 Greenway Blvd., Suite 900
608.836.3690 Middleton, WI 53562


ISSUED
Land Use Submittal - June 26, 2023

PROJECT TITLE
WHPC Regent Street Development

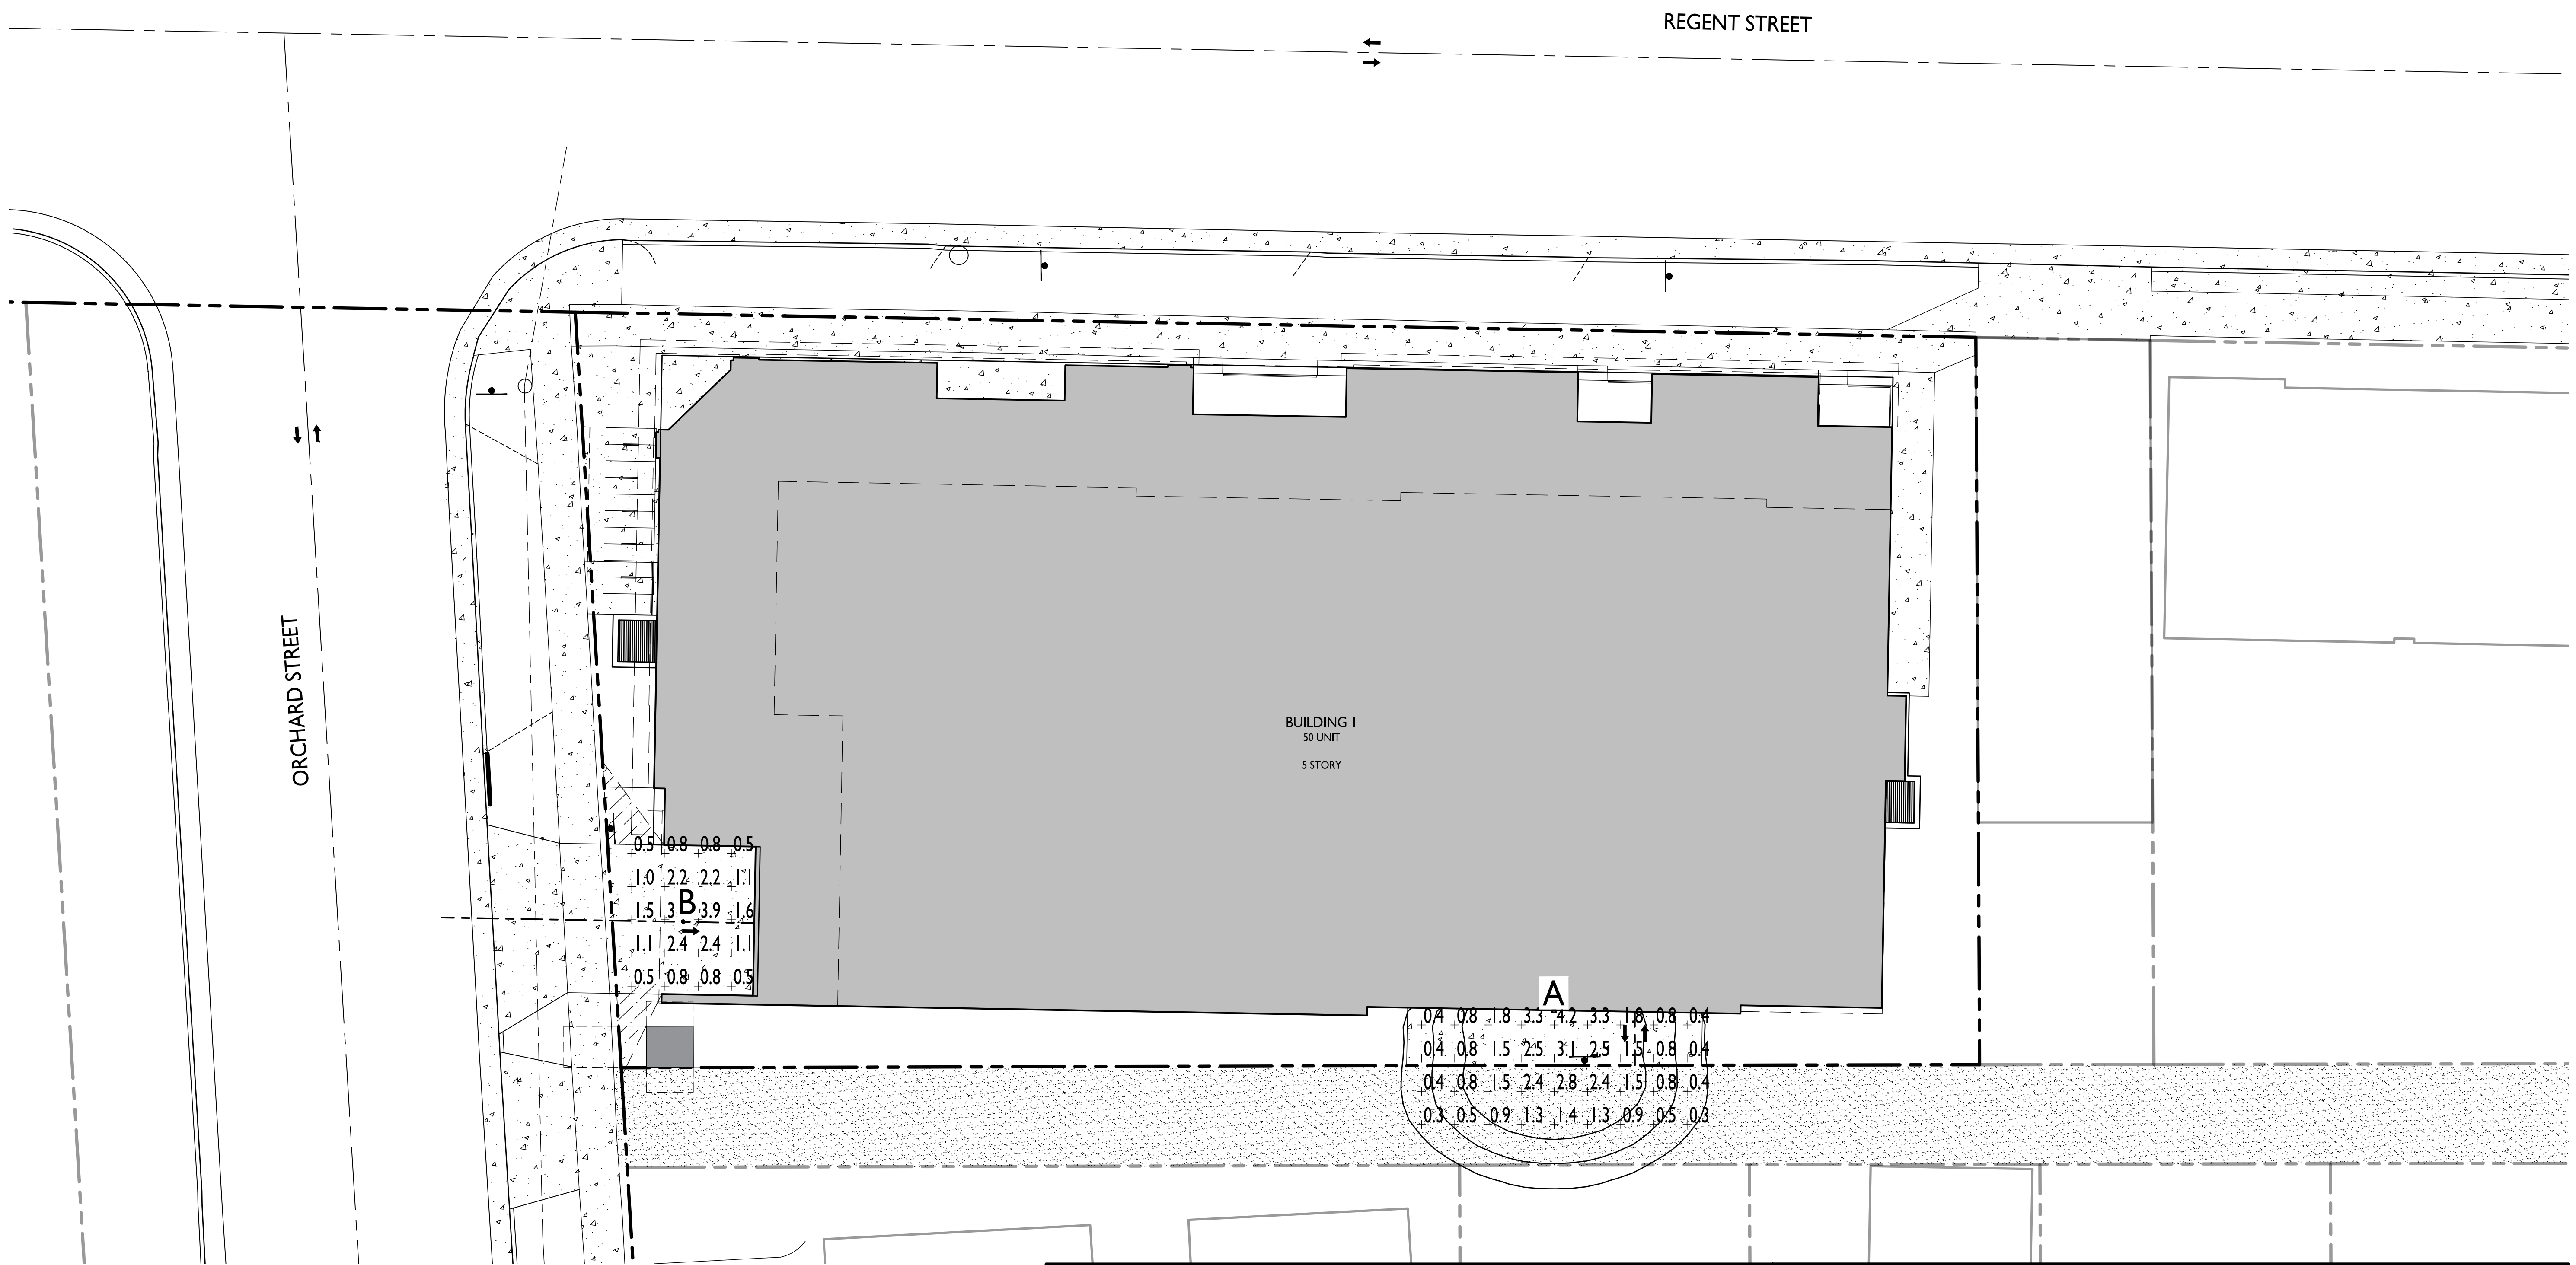


LIGHT LEVEL STATISTICS						
DESCRIPTION	SYMBOL	AVG.	MAX.	MIN.	MAX. / MIN.	AVG. / MIN.
Underground Drive Entrance	+	1.5 fc	3.9 fc	0.5 fc	7.8:1	3.0:1
Garage Entrance from Alley	+	1.4 fc	4.2 fc	0.3 fc	14.0:1	4.7:1

LUMINAIRE SCHEDULE							
SYMBOL	LABEL	QTY.	MANUF.	CATALOG	DESCRIPTION	FILE	MOUNTING
+	A	1	LITHONIA LIGHTING	WDGE1 LED PI 30K 80CRI VF	WDGE1 LED WITH PI - PERFORMANCE PACKAGE, 3000K, 80CRI, VISUAL COMFORT FORWARD OPTIC	WDGE1_LED_PI_30K_80CRI_VF.ies	11'-0" ABOVE GRADE ON BUILDING
○	B	1	LITHONIA LIGHTING	WF4 LED 30K	4" MATTE WHITE LED ULTRA-THIN WAFER DOWNLIGHT, 3000K CCT, LEXTAR 2835 LED	WF4_LED_30K.ies	CEILING MOUNTED

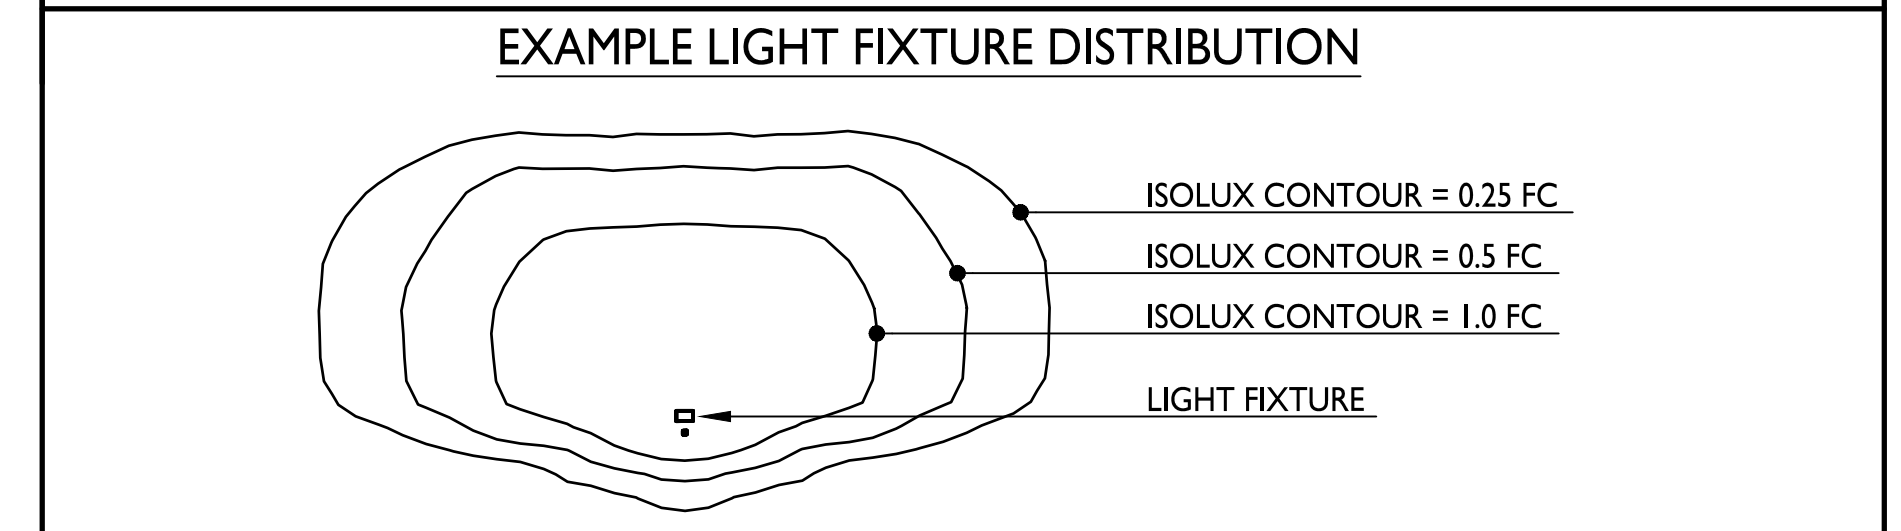

I SITE LIGHTING PLAN
C-2.1 1" = 10'-0"

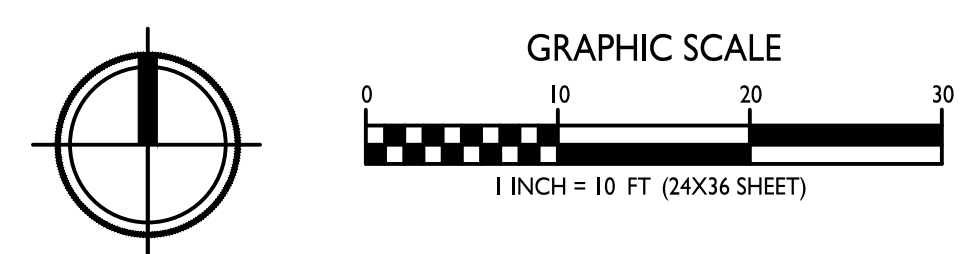

1233 Regent Street,
Madison, WI
SHEET TITLE
Site Lighting Plan

SHEET NUMBER

C-2.1

PROJECT NO. **2309**
© Knothe & Bruce Architects, LLC