



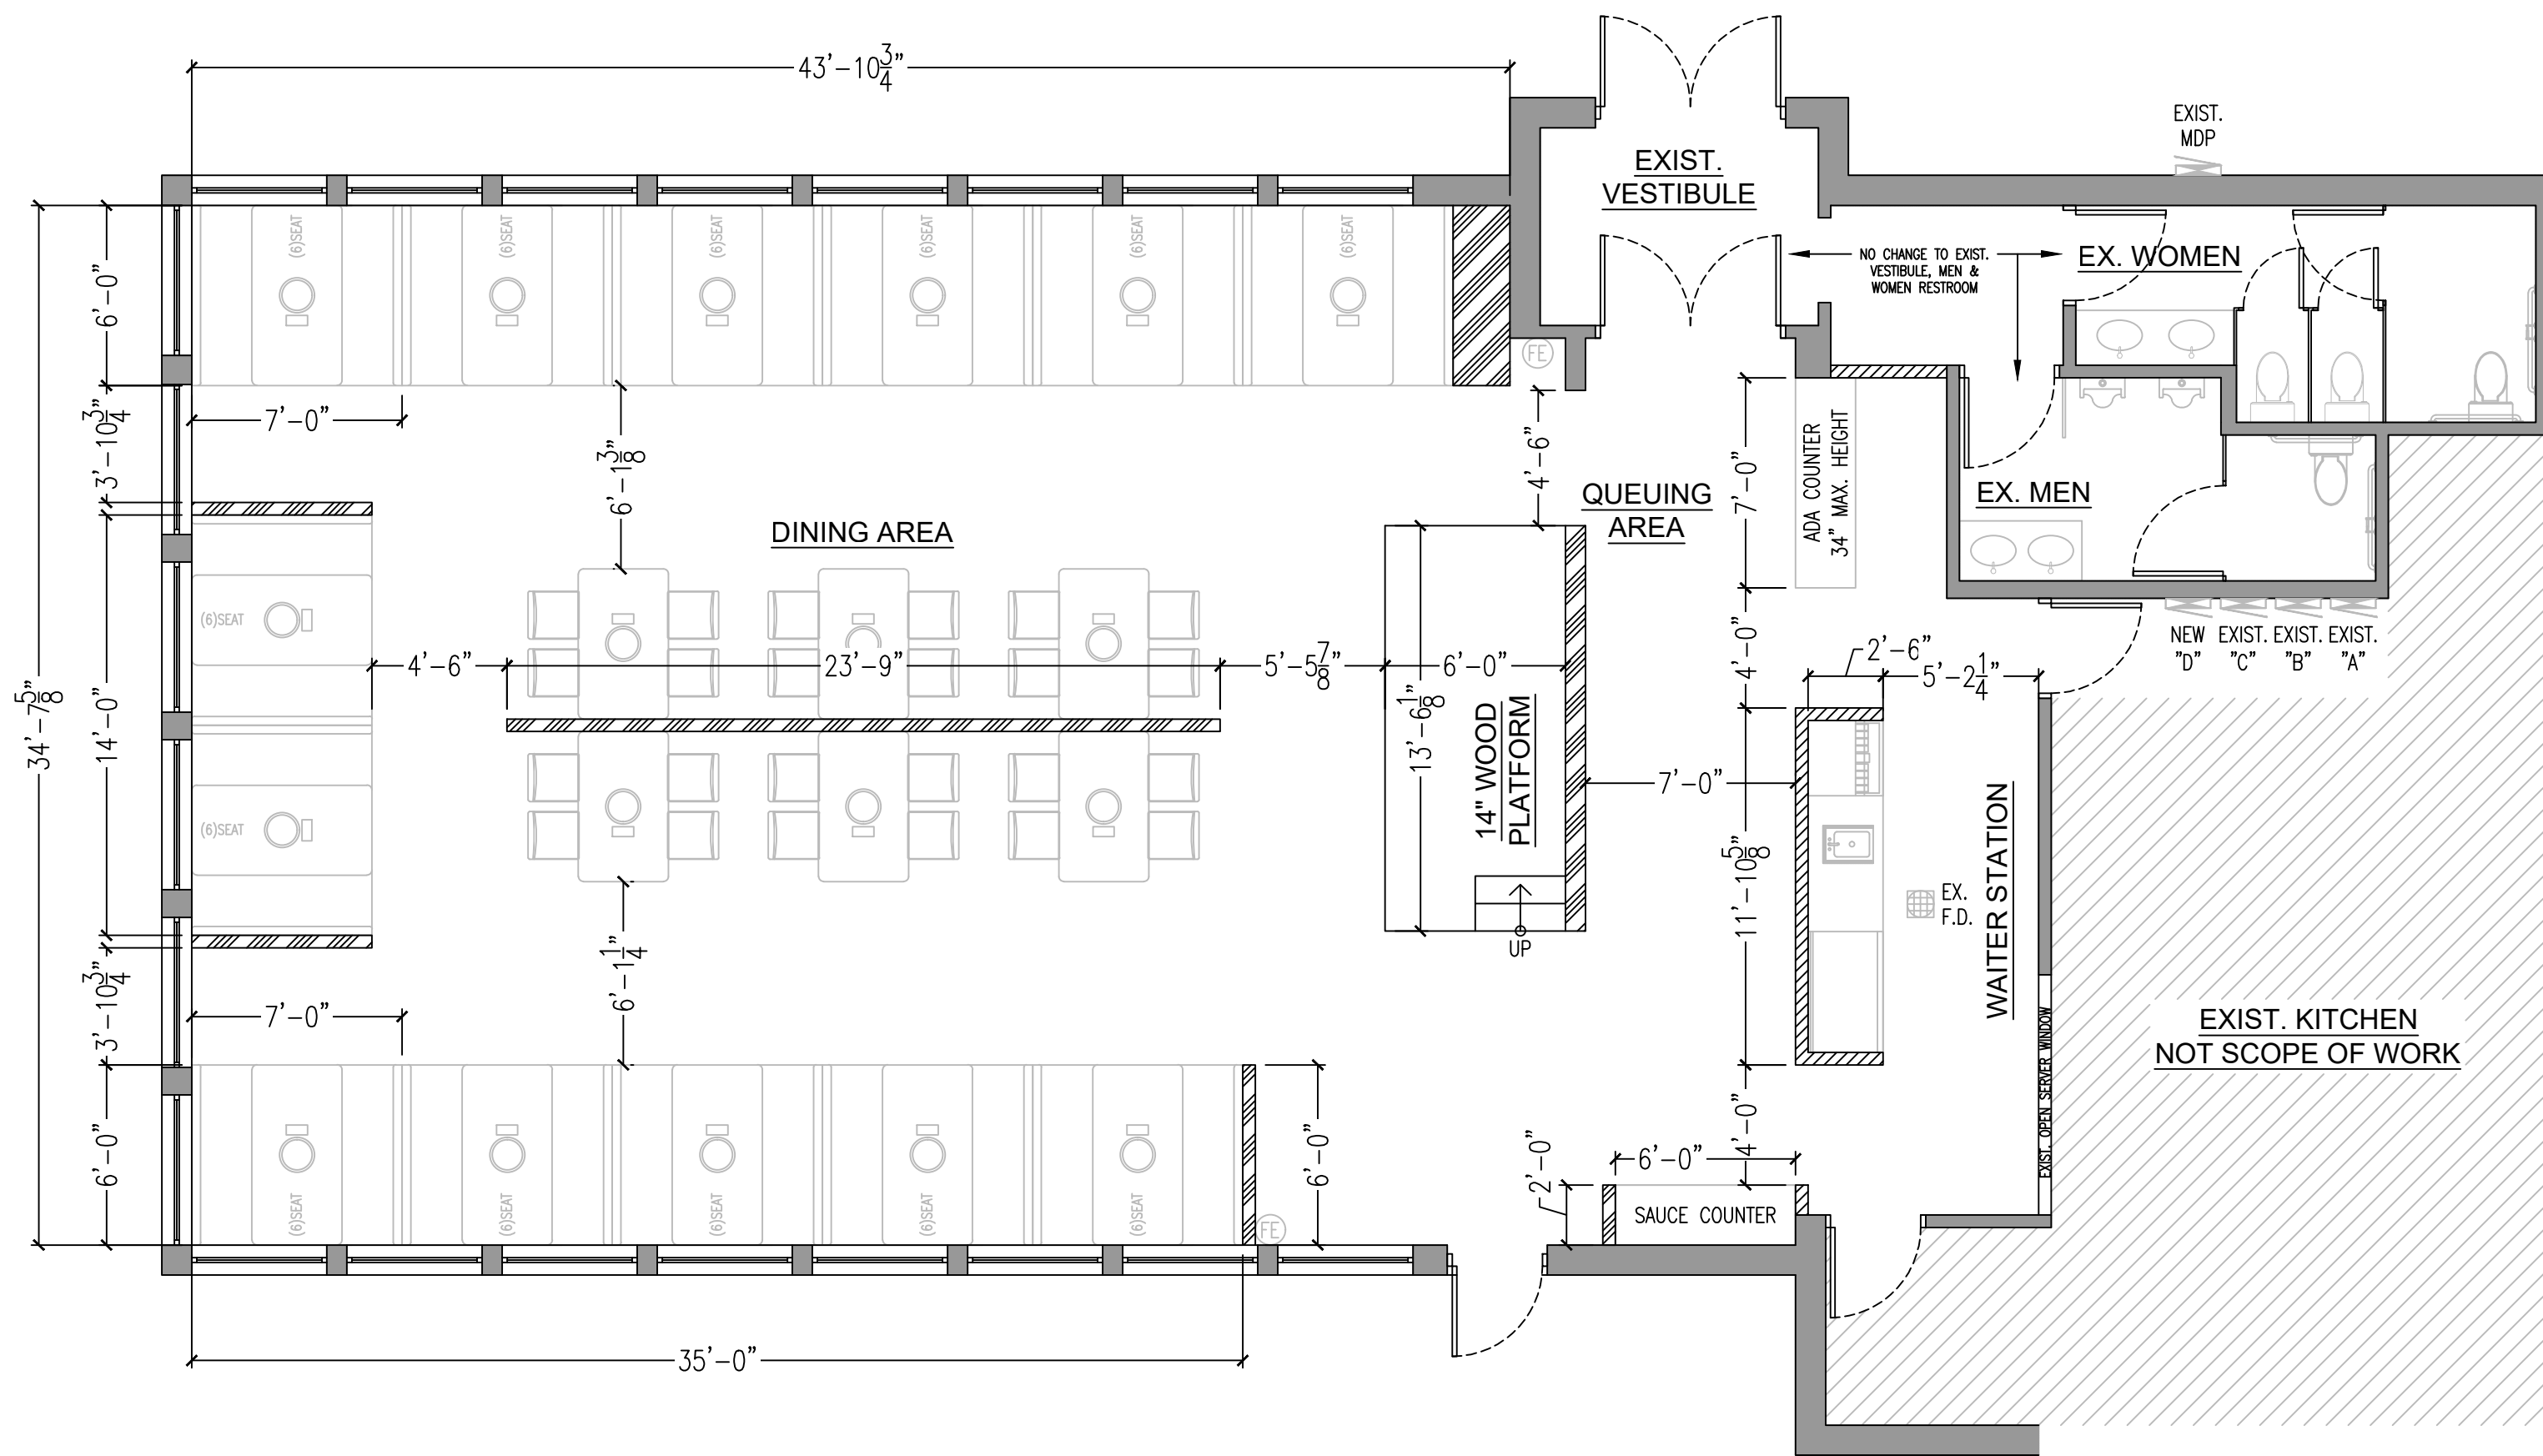

DIMENSION FLOOR PLAN

SCALE: 3/16" = 1'-0"

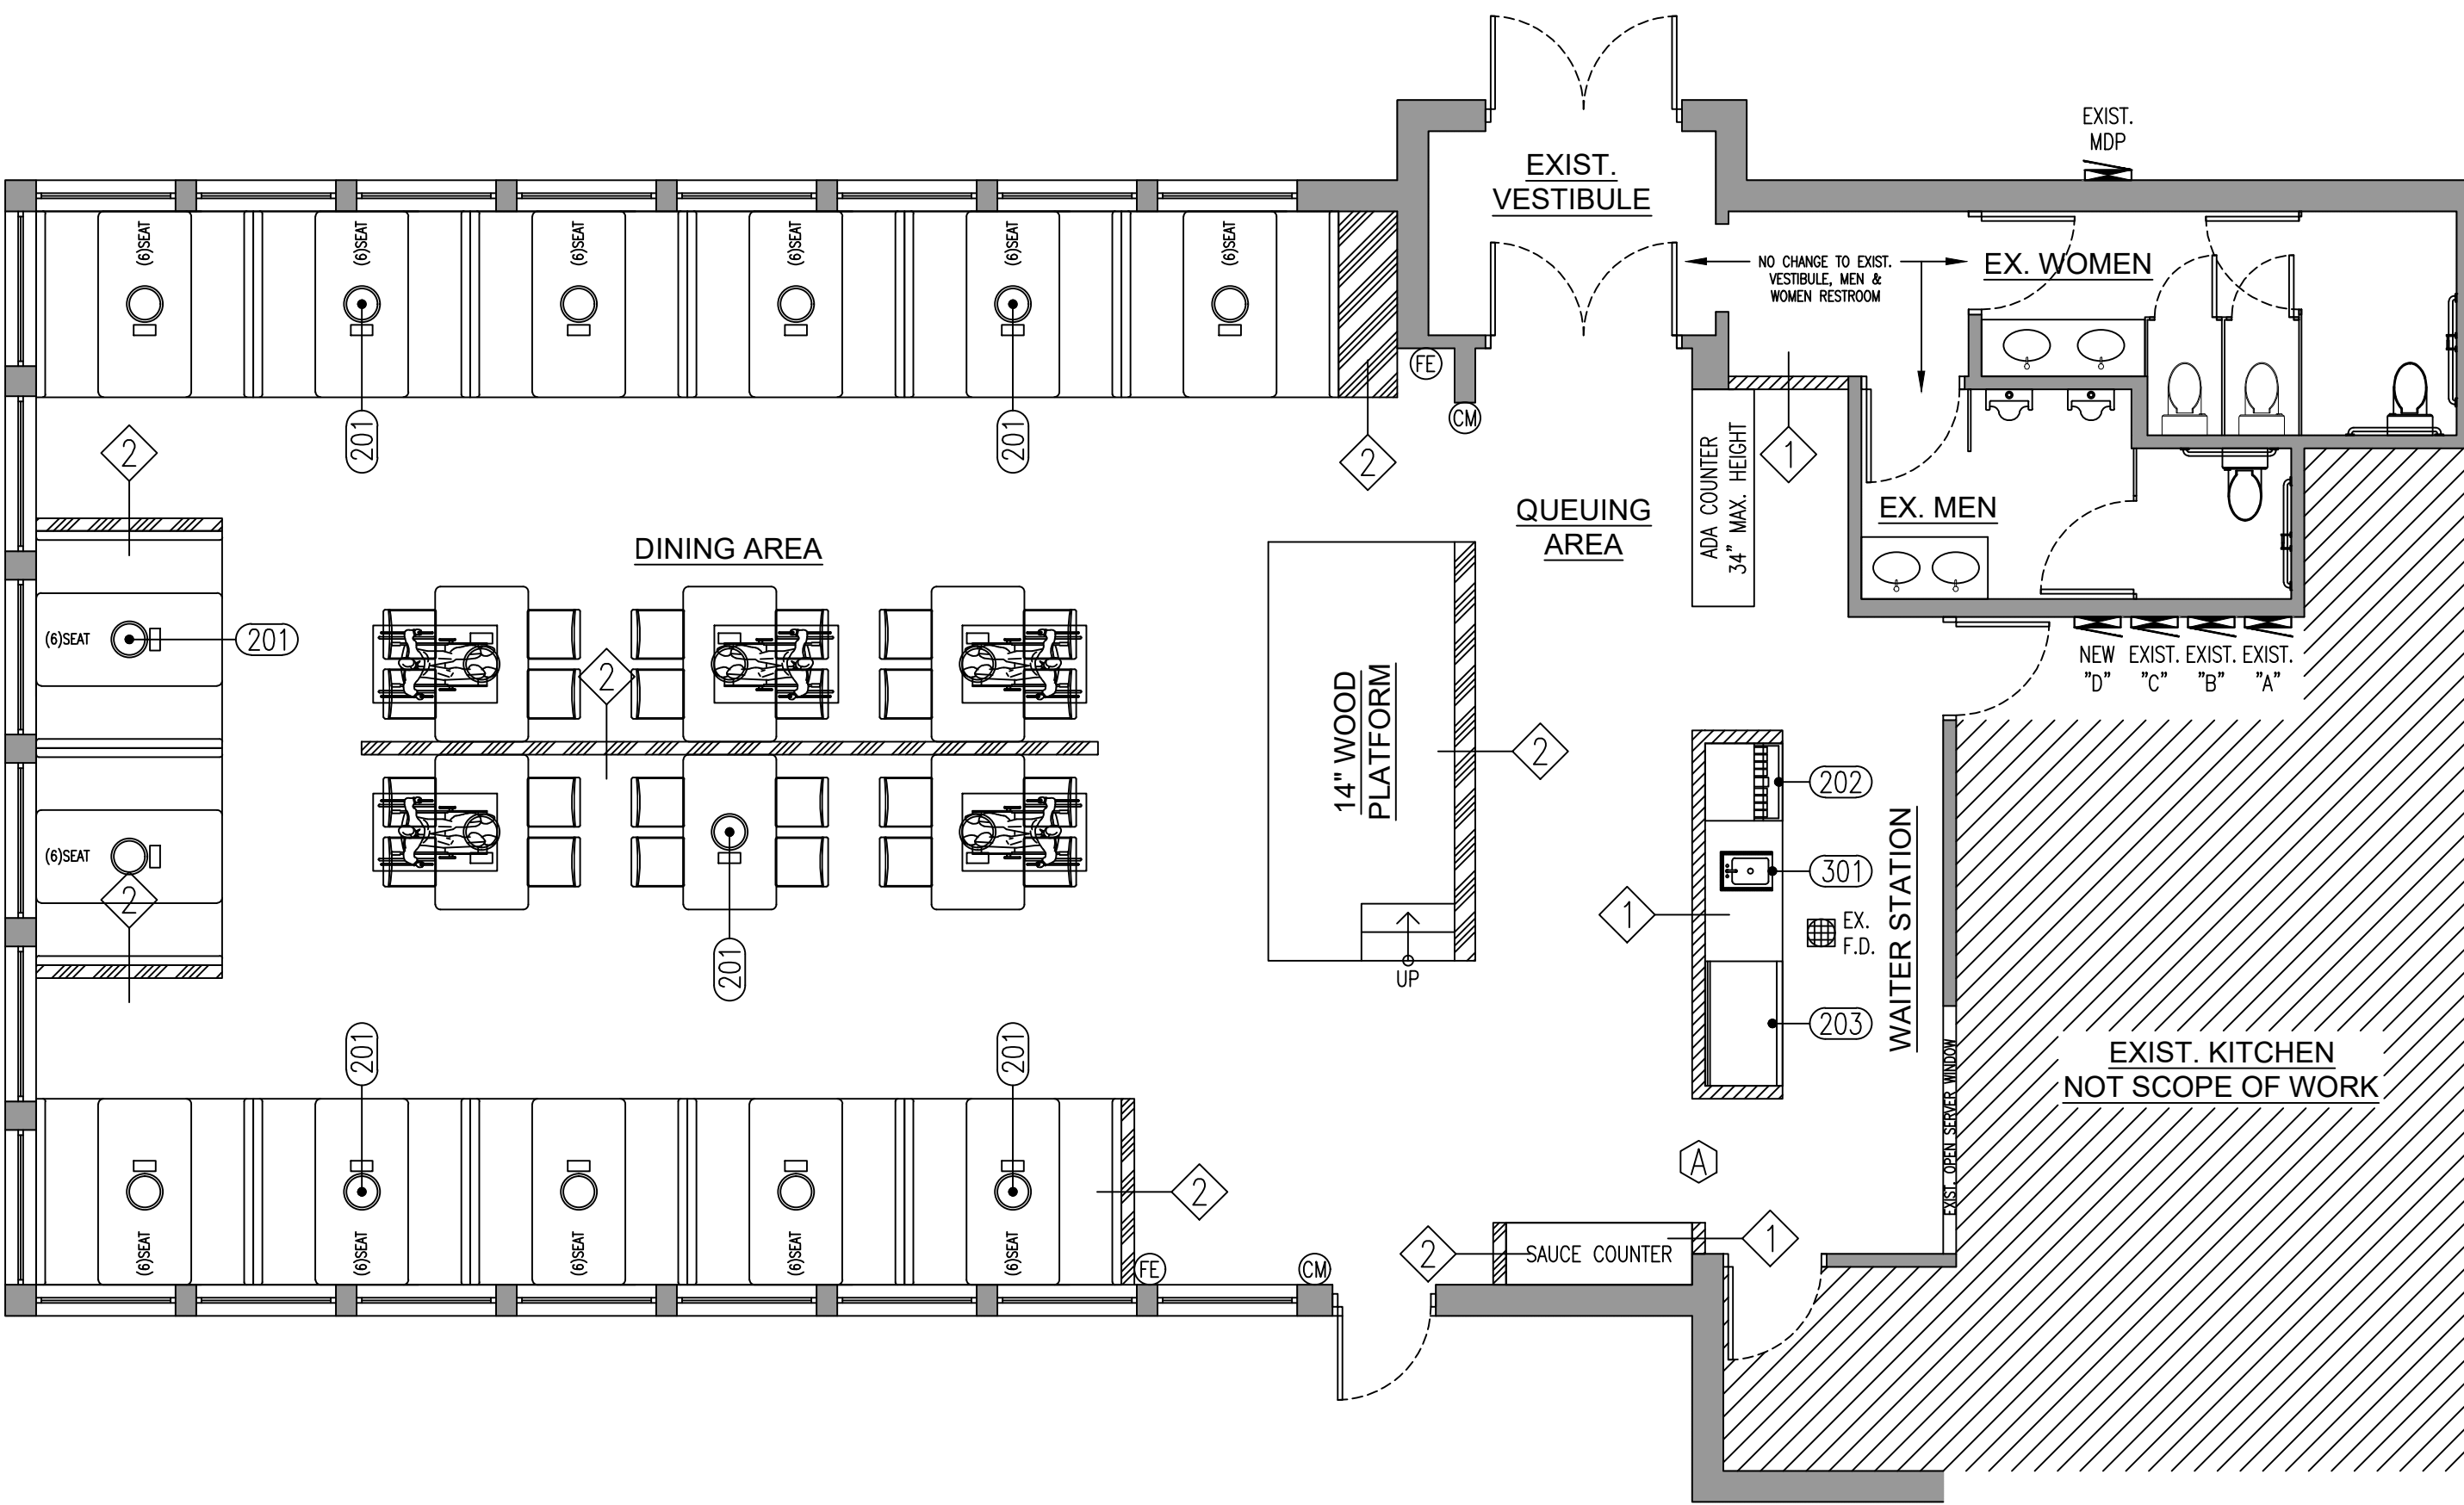

PROPOSED FLOOR PLAN

SCALE: 3/16" = 1'-0"

SYMBOL LEGEND

NOTE: NOT ALL SYMBOLS MAY BE USED ON PROJECT


	WALL TYPE (REFER SHEET A-3 FOR WALL DETAIL)		2A10 "BC" FIRE EXTINGUISHER (INSTALL MAX. 40" AFF. TO THE TOP OF THE HANDLE)
	DOOR TYPE (REFER SHEET A-3 FOR DOOR DETAIL)		CLASS "K" FIRE EXTINGUISHER (INSTALL MAX. 40" AFF. TO THE TOP OF THE HANDLE)
	FLOOR DRAIN		PROGRAMMABLE TYPE THERMOSTAT
	EQUIPMENT TAG		CARBON MONOXIDE ALARM
	NEW HIGH PARTITION (FIRE TEST RATING CLASS "B")		FIRE SUPPRESSION PULL STATION MOUNTED AT 44" AFF.
	NEW LOW PARTITION (FIRE TEST RATING CLASS "B")		

NOTES & REMARKS

- NO CHANGE TO WALL, CEILING, FLOORING, AND FINISHES OF EXISTING KITCHEN, VESTIBULE, RESTROOM, STORAGE, OFFICE, AND MECHANICAL ROOM.
- NO CHANGE TO EXISTING DOORS.

EQUIPMENT SCHEDULE

NO.	QTY.	EQUIPMENT	MANUFACTURE	MODEL	CERT.	ELETRICAL				WATER		WASTE	
						VOLT	PHS.	HP.	KW.	C.W.	H.W.	DIR.	IND.
201	19	HOT POT INDUCTION COOKER	SUNPENTOWN	SR-184R	E.T.L.	120	1		1.80				
202	1	SODA DISP.	LANCER	IDB 30	N.S.F.	220	1		0.80	1/2"			3"
203	1	WORKTOP REF.	ATOSA	MGF8409GR	E.T.L.	115	1	1/7	0.27				
301	1	DROP IN HAND SINK	REGENCY	600D11014S	N.S.F.					1/2"	1/2"	2"	

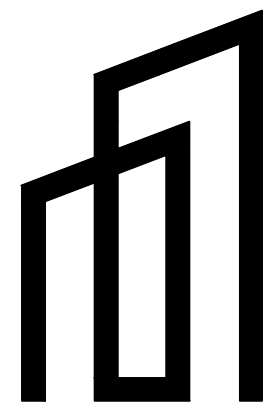

T.C. DESIGN INC.
ARCHITECTURAL - CONSTRUCTION - PLUMBING
ELECTRICAL - MECHANICAL
38-08 UNION ST STE 2H-B FLUSHING, NY 11354
TEL: (917) 873-3553
EMAIL: HELLO@TCDESIGNUS.COM

PROFESSIONAL'S CERTIFICATION

FUKI HOT POT
2143 ZEIER RD
MADISON, WI 53704

REVISIONS

NO.	DATE
1	
2	
3	
4	
5	
DATE: 08/04/2022	
DRAWN BY: A.C.	
PROJECT NO. 2022-2143	

A-2