


3/25/2015 1:17:19 PM

P:\KOW\Madwa\1290835-final-dsgn\51-drawings\Central Models (Do Not Modify)\Well_31.rvt

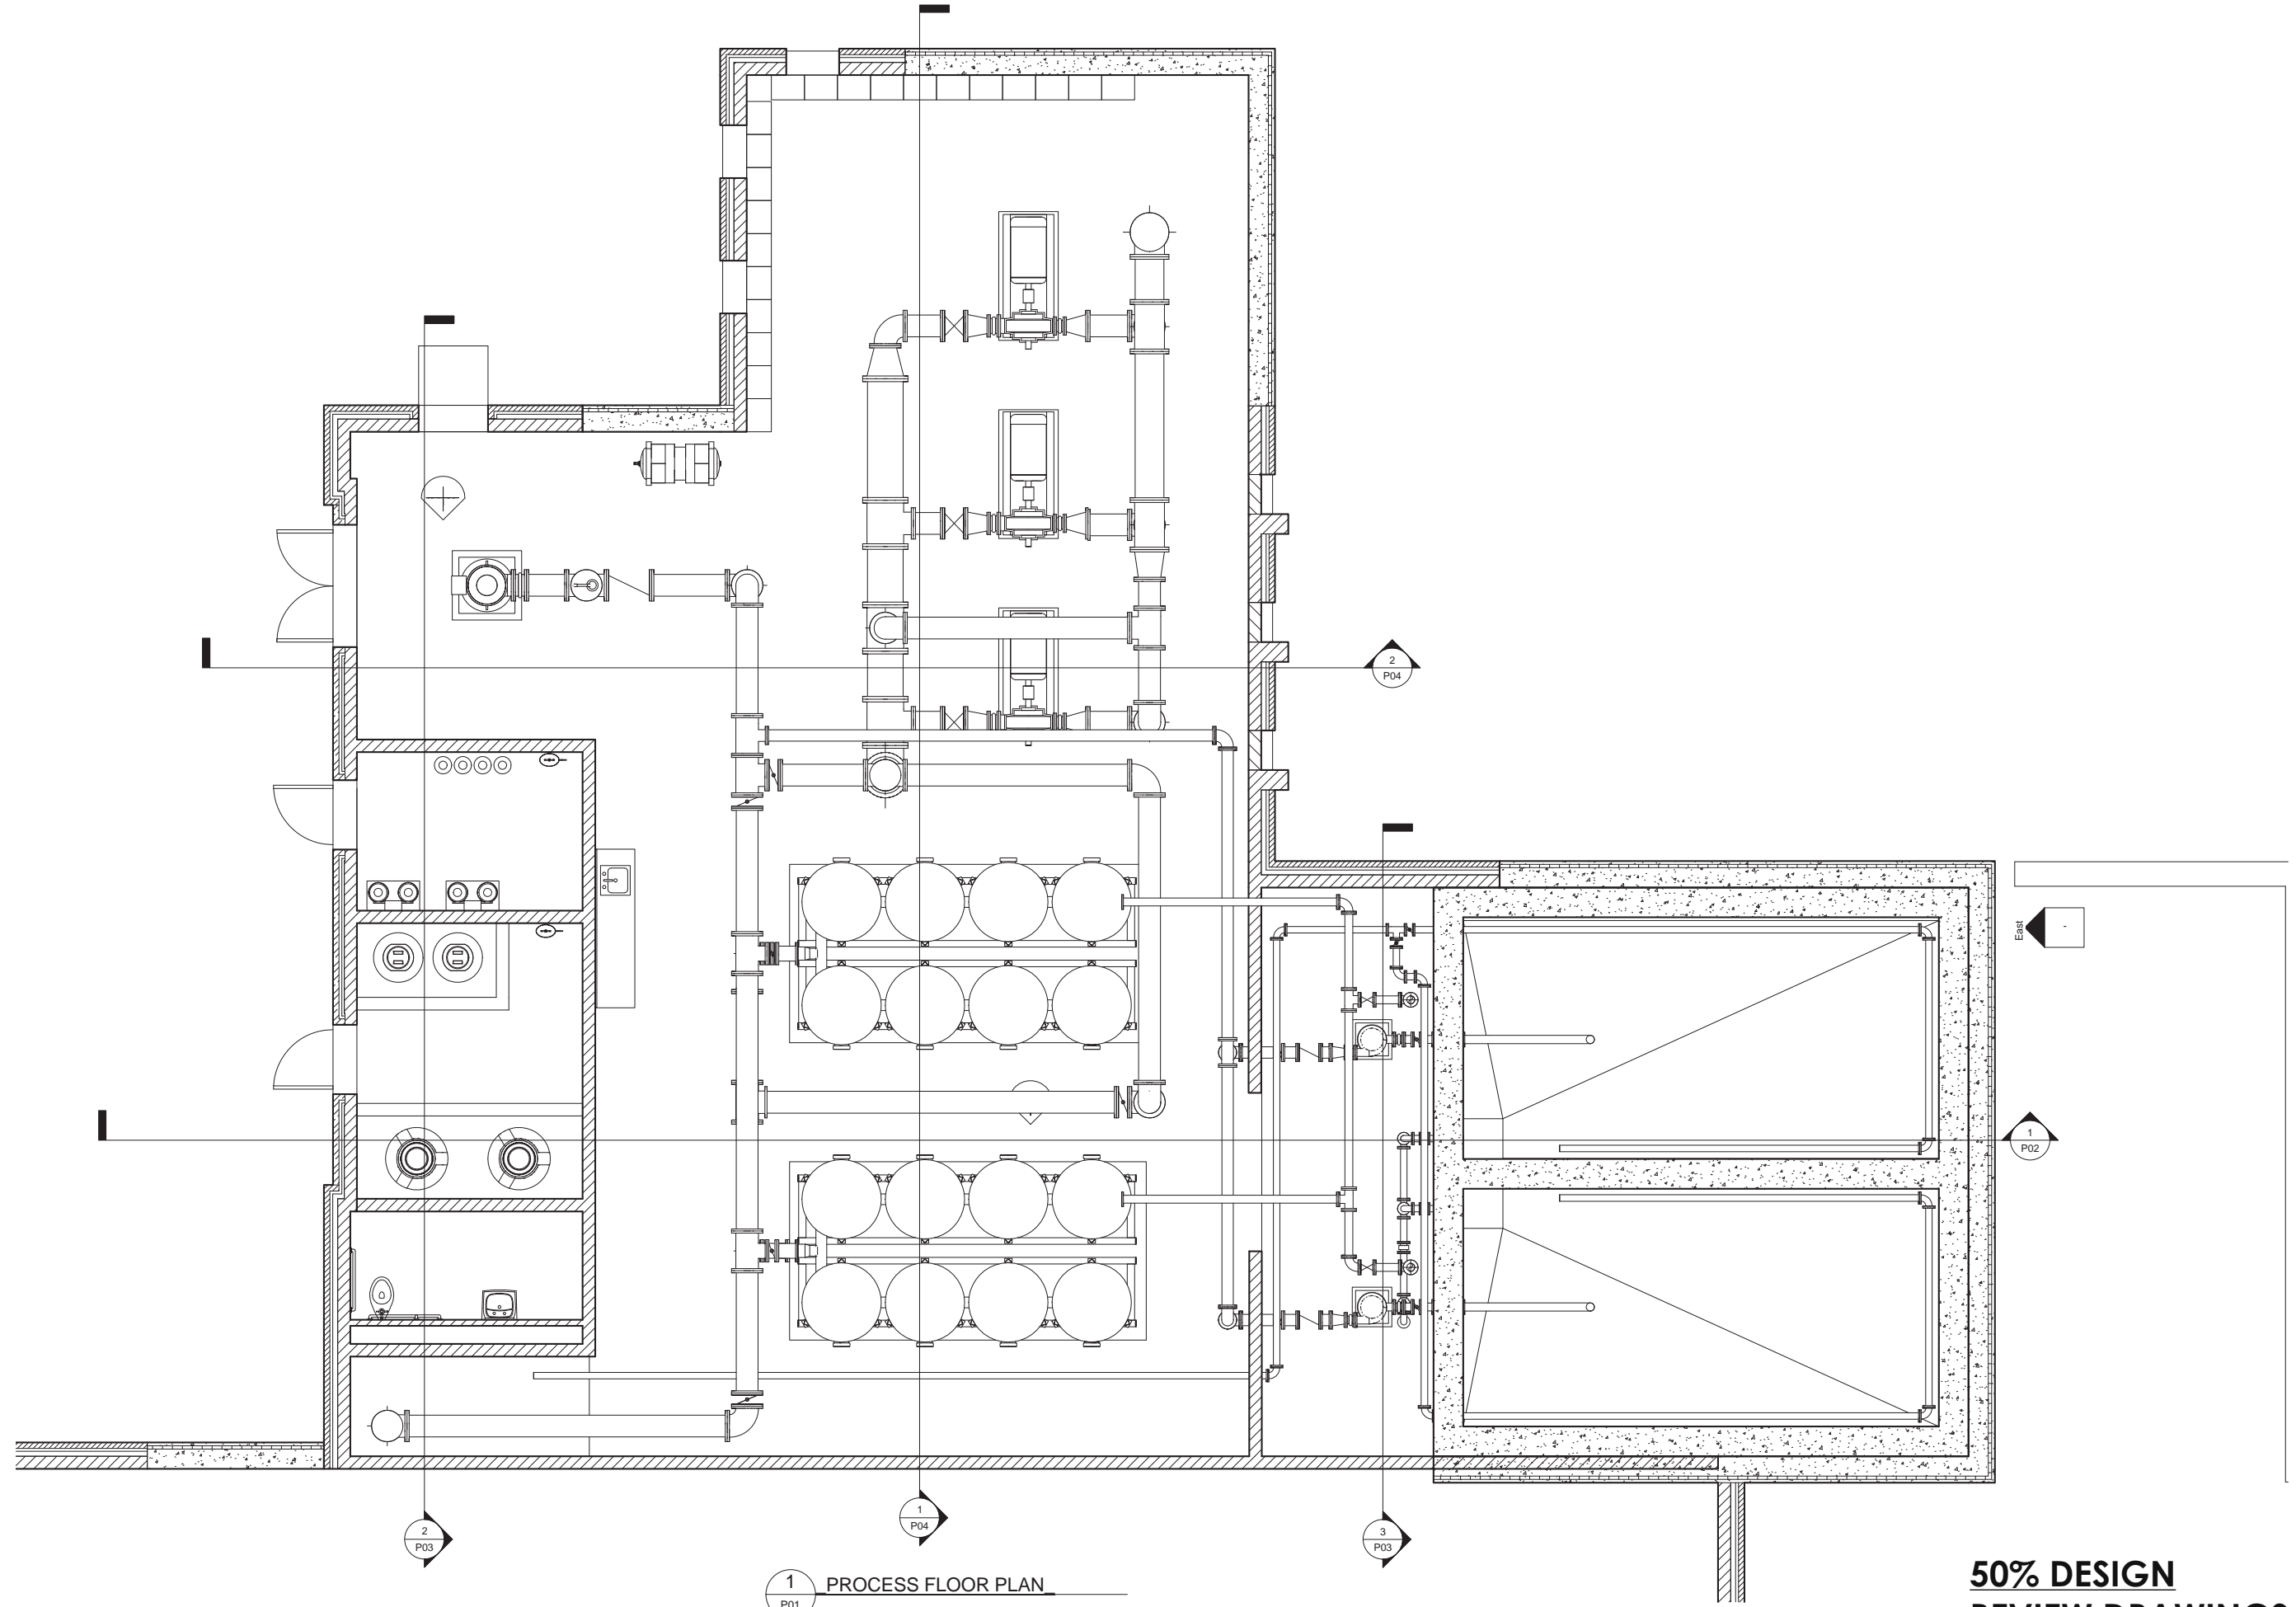

1 P01 PROCESS FLOOR PLAN

**50% DESIGN
REVIEW DRAWINGS**



2015 UNIT WELL 31 WTP AND STORAGE FACILITY
MADISON WATER UTILITY

PRELIMINARY

MARK	DATE	DESCRIPTION

120083
FILE NO.
CITY PROJECT NO.
APRIL, 2015
ISSUE DATE
RS
DESIGNED BY
LP
DRAWN BY

SHEET TITLE
**PROCESS
FIRST FLOOR PLAN**

SHEET
P01

Short Elliott Hennrichson, Inc. © (SEH)