


# EXHIBIT B

(Not to scale)

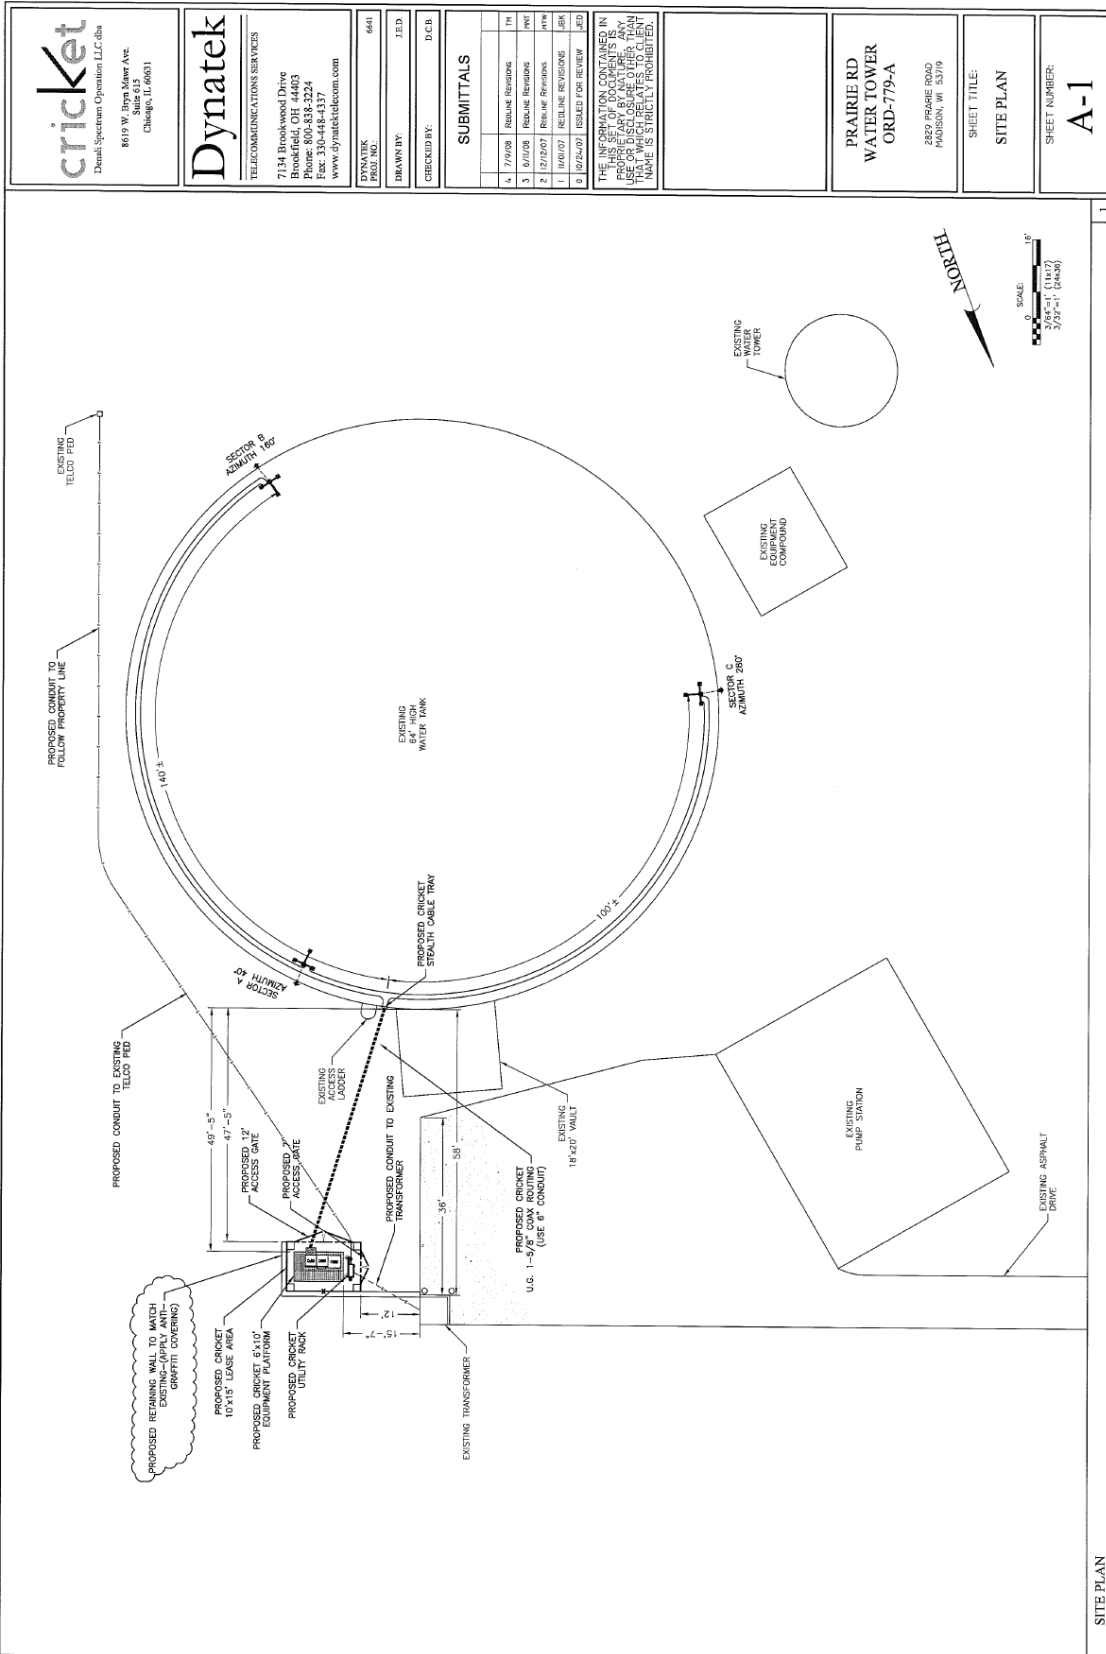

**cricket**  
 Data/Spectrum Operation LLC dba  
 8619 W. 119th Street Ave.  
 Suite 615  
 Chicago, IL 60651

**Dynatek**  
 TELECOMMUNICATIONS SERVICES  
 7134 Brookwood Drive  
 Brookfield, OH 44803  
 Phone: 800-838-3224  
 Fax: 330-448-1337  
 www.dynatekinc.com

DYNATEK  
 PROJ. NO. 6411  
 DRAWN BY: J.E.D.  
 CHECKED BY: D.C.B.

**SUBMITTALS**

NO.	DATE	REVISIONS	BY
4	7/9/08	Revised Revisions	JED
3	6/10/08	Revised Revisions	JED
2	12/18/07	Revised Revisions	JED
1	10/10/07	Revised Revisions	JED
0	02/26/07	ISSUED FOR REVIEW	JED

THE INFORMATION CONTAINED IN THIS SET OF DOCUMENTS IS PREPARED BY OR FOR THE USE OF THE CLIENT AND IS NOT TO BE USED FOR ANY OTHER PURPOSE WITHOUT THE WRITTEN CONSENT OF DYNATEK. NAME IS STRICTLY PROHIBITED.

**PRAIRIE RD  
 WATER TOWER  
 ORD-779-A**

2639 PRAIRIE ROAD  
 MADISON, WI 53719

SHEET TITLE:  
**SITE PLAN**

SHEET NUMBER:  
**A-1**

SITE PLAN