

EXHIBIT A

VILLAGER MALL STORM RELIEF
PROJECT NO. 11491


SHEET NO.
U-1

PLAN AND PROFILE

VILLAGE AT PARK CITY OF MADISON



SCALE:
1"=40'
(11"X17")

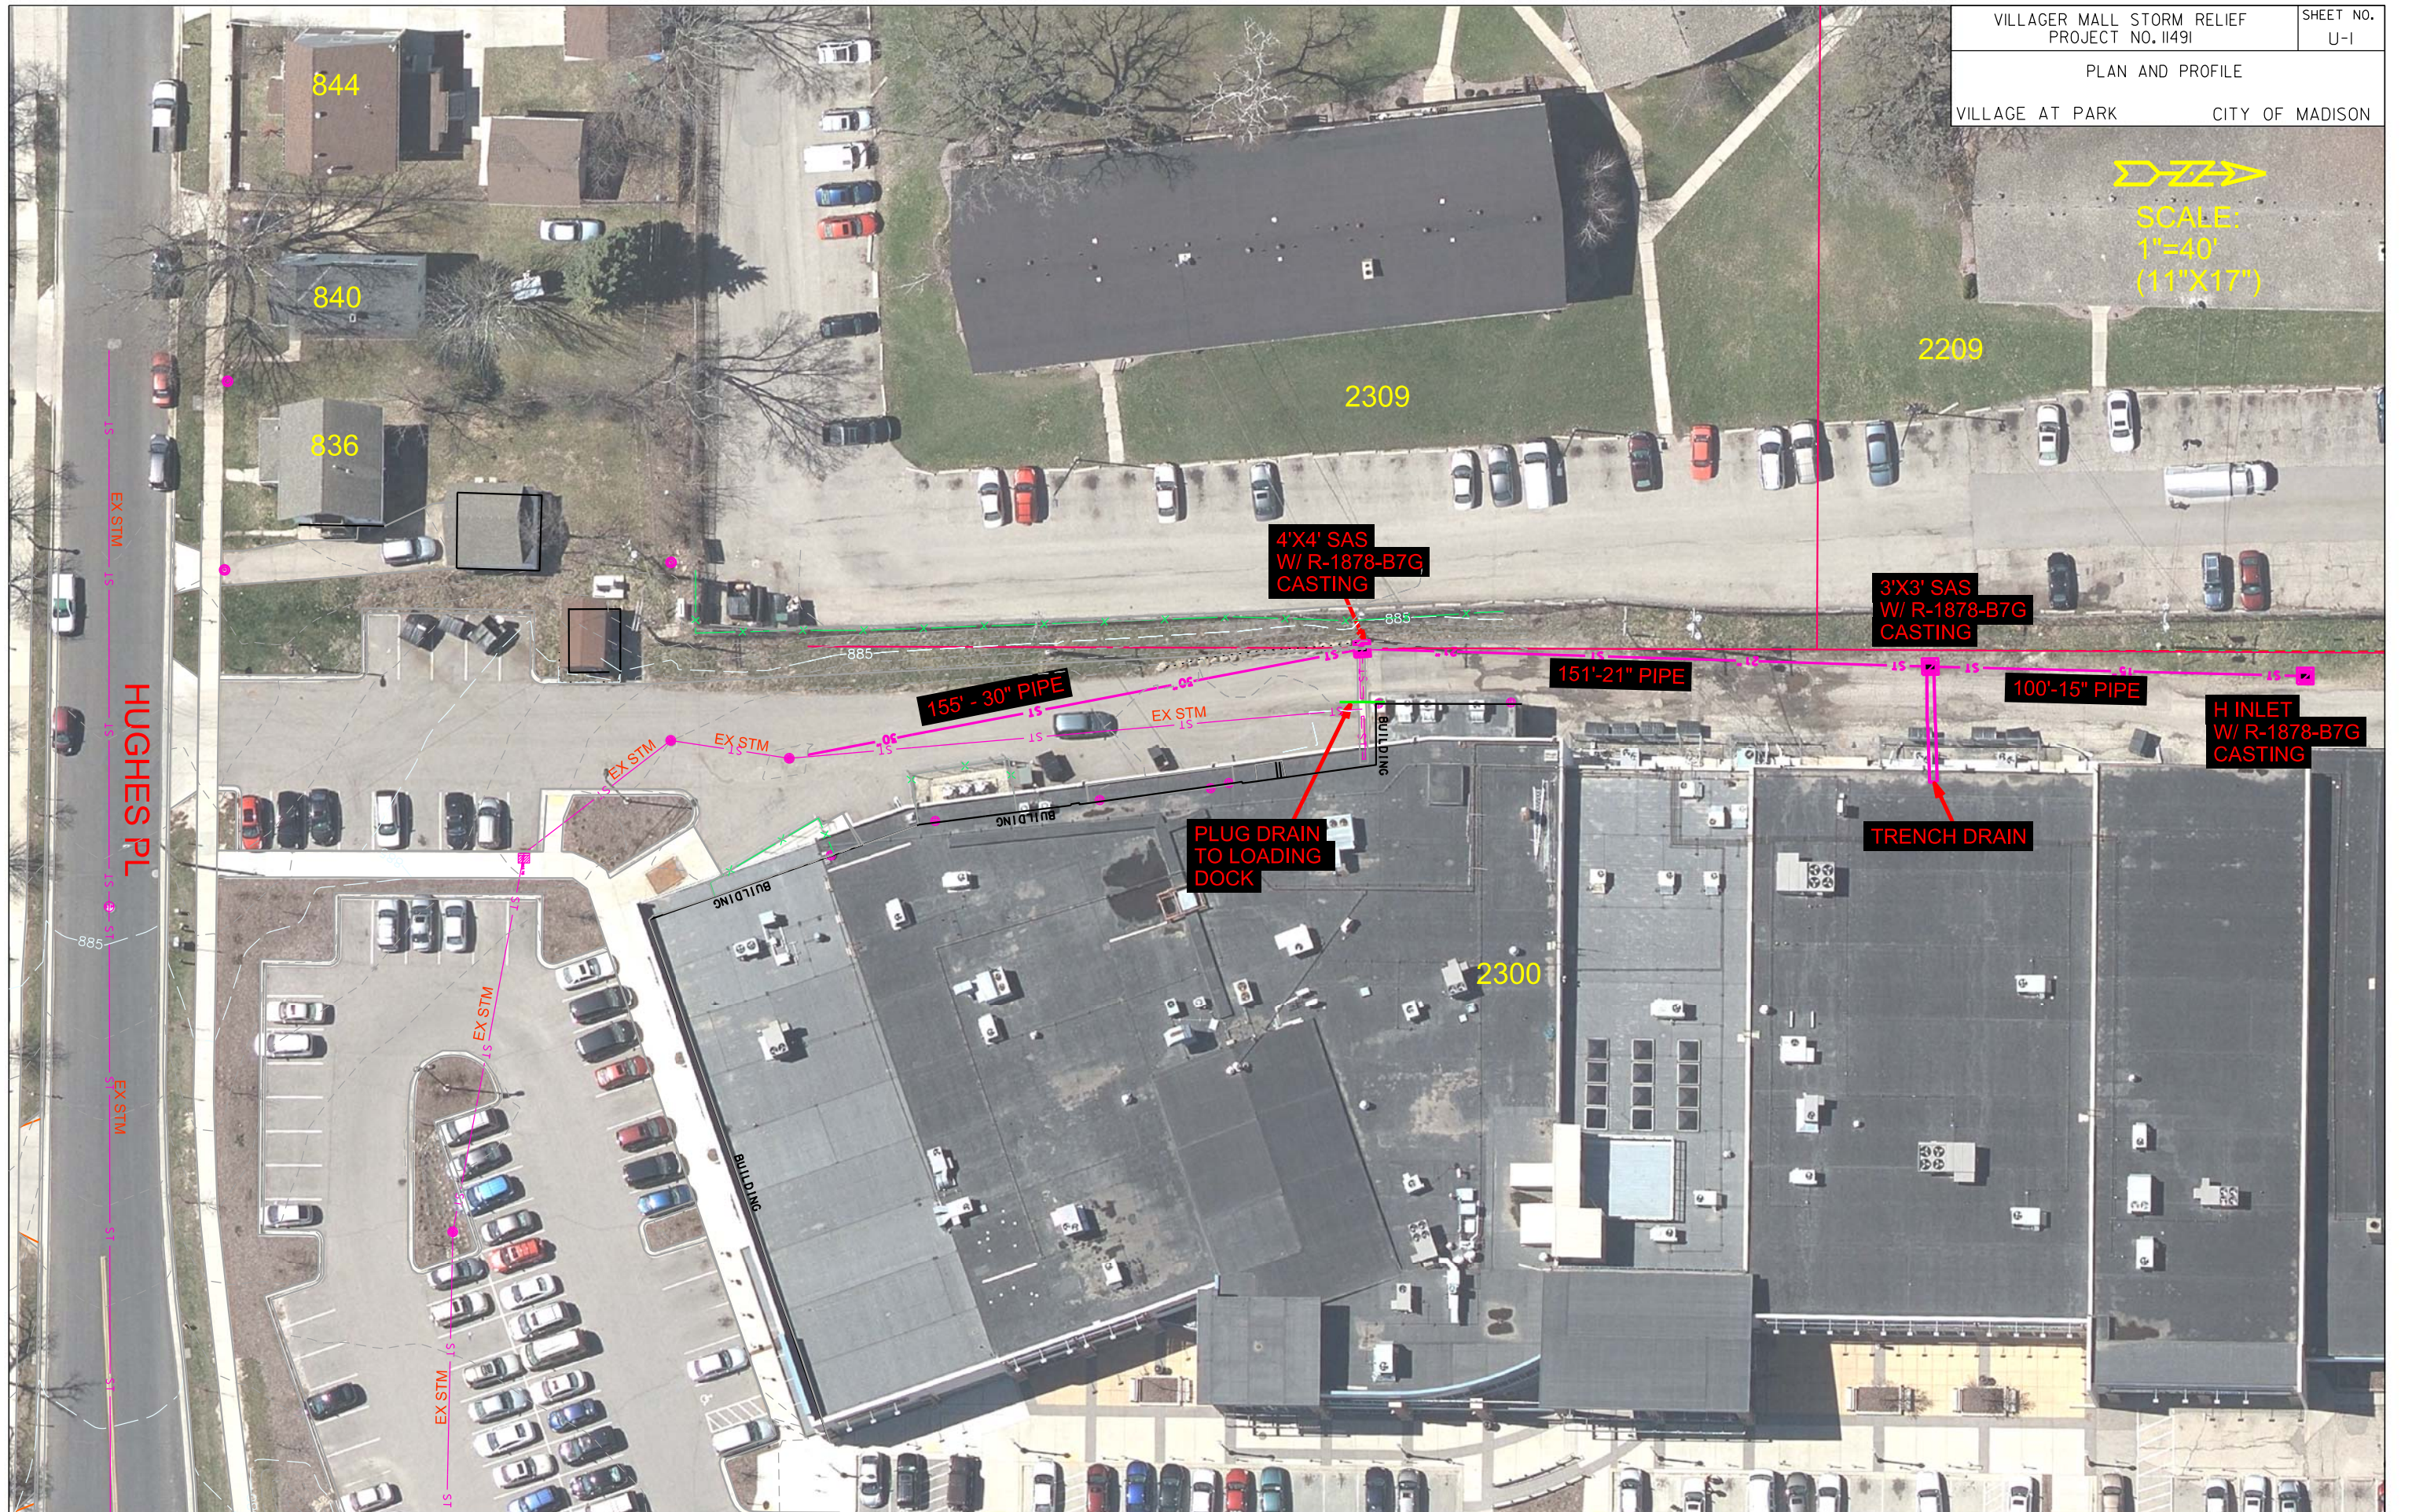

844

840

836

2309

2209

2300

HUGHES PL

4'X4' SAS
W/ R-1878-B7G
CASTING

3'X3' SAS
W/ R-1878-B7G
CASTING

H INLET
W/ R-1878-B7G
CASTING

155'-30" PIPE

151'-21" PIPE

100'-15" PIPE

PLUG DRAIN
TO LOADING
DOCK

TRENCH DRAIN

EX STM

EX STM

EX STM

EX STM

EX STM

EX STM

BUILDING

BUILDING

BUILDING

BUILDING

885

885

LS

LS

