

# WARNER PARK COMMUNITY RECREATION CENTER EXPANSION

CITY OF MADISON PARKS DIVISION

1625 NORTHPORT DRIVE  
MADISON, WI 53704



MILWAUKEE | MADISON | CHICAGO

PROJECT

SEAL

WARNER PARK  
COMMUNITY RECREATION  
CENTER EXPANSION

1625 NORTHPORT DRIVE  
MADISON, WI 53704  
CITY OF MADISON PARKS DIVISION  
330 EAST LAKESIDE STREET  
MADISON, WI 53715

PROJECT NUMBER 223471.00

CONSULTANTS

DRAWINGS

## CIVIL

**JSD PROFESSIONAL SERVICES, INC.**  
507 W VERONA AVE #500  
VERONA, WI 53593  
PH 608-848-5060

- T100 TITLE SHEET
- 1 OF 1 BOUNDARY, TOPOGRAPHIC AND UTILITY SURVEY
- C100 NOTES & LEGEND
- C200 DEMOLITION PLAN
- C300 OVERALL SITE PLAN
- C301 SITE PLAN
- C400 GRADING & EROSION CONTROL PLAN
- C500 DETAILS
- C501 DETAILS

## LANDSCAPE

**JSD PROFESSIONAL SERVICES, INC.**  
161 HORIZON DR #101  
VERONA, WI 53593  
PH 608-848-5060

- L100 LANDSCAPE PLAN
- L200 LANDSCAPE DETAILS & NOTES

## ARCHITECTURAL

**ENGBERG ANDERSON, INC.**  
305 W WASHINGTON AVE  
MADISON, WI 53703  
PH 608-250-0100

- D101 PARTIAL DEMOLITION PLAN
- D200 ENLARGED DEMO PLANS & DETAILS
- A100 OVERALL FLOOR PLAN
- A101 EXPANSION FLOOR PLAN
- A200 OVERALL ROOF PLAN
- A201 EXPANSION ROOF PLAN
- A300 OVERALL REFLECTED CEILING PLAN
- A310 ENLARGED REFLECTED CEILING PLANS
- A400 EXTERIOR ELEVATIONS
- A500 BUILDING SECTIONS
- A510 WALL SECTIONS
- A511 WALL SECTIONS
- A512 WALL SECTIONS
- A600 EXTERIOR DETAILS
- A601 EXTERIOR DETAILS
- A602 EXTERIOR DETAILS
- A603 EXTERIOR DETAILS
- A610 DOOR SCHEDULE & WALL TYPES
- A700 FINISH PLANS & SCHEDULE
- A800 ENLARGED PLANS & INTERIOR ELEVATIONS
- A801 INTERIOR ELEVATIONS
- A810 INTERIOR DETAILS
- A811 INTERIOR DETAILS

## STRUCTURAL

**ONEIDA TOTAL INTEGRATED ENTERPRISES**  
1033 N MAYFAIR RD #200  
MILWAUKEE, WI 53226  
PH 414-257-4200

- S001 STRUCTURAL NOTES
- S002 STRUCTURAL SCHEDULES
- S200 FOUNDATION PLAN - EXPANSION
- S201 FOUNDATION PLAN - RESTROOM/LOCKER ROOM
- S202 ROOF FRAMING PLAN - EXPANSION
- S800 STRUCTURAL DETAILS
- S801 STRUCTURAL DETAILS
- S802 STRUCTURAL DETAILS
- S803 STRUCTURAL DETAILS

## FIRE PROTECTION

**JDR ENGINEERING, INC.**  
5525 NOBEL DR #110  
MADISON, WI 53711  
PH 608-277-1728

- F000 SYMBOLS, ABBREVIATIONS, DETAILS & SCHEDULES - FIRE PROTECTION
- F101 FIRST FLOOR DEMOLITION PLAN - FIRE PROTECTION
- F201 FIRST FLOOR PLAN - FIRE PROTECTION

## PLUMBING

**JDR ENGINEERING, INC.**  
5525 NOBEL DR #110  
MADISON, WI 53711  
PH 608-277-1728

- P000 SYMBOLS & ABBREVIATIONS, DETAILS & SCHEDULES - PLUMBING
- P100 UNDERFLOOR DEMOLITION PLAN - PLUMBING
- P101 FIRST FLOOR DEMOLITION PLAN - PLUMBING
- P200 OVERALL UNDERFLOOR PLAN - PLUMBING
- P201 PARTIAL ENLARGED UNDERFLOOR PLAN - PLUMBING
- P202 OVERALL FIRST FLOOR PLAN - PLUMBING
- P203 PARTIAL ENLARGED FIRST FLOOR PLAN - PLUMBING
- P301 ENLARGED PLANS - PLUMBING
- P801 SCHEDULES - PLUMBING

## MECHANICAL

**JDR ENGINEERING, INC.**  
5525 NOBEL DR #110  
MADISON, WI 53711  
PH 608-277-1728

- M000 SYMBOLS & ABBREVIATIONS - HVAC
- M101 FIRST FLOOR PARTIAL DEMOLITION PLAN - HVAC
- M200 OVERALL FIRST FLOOR PLAN - HVAC
- M201 FIRST FLOOR EXPANSION PLAN - HVAC
- M202 FIRST FLOOR EXISTING PLAN - HVAC
- M300 ENLARGED NORTH MECHANICAL MEZZANINE PLANS - HVAC
- M301 ENLARGED SOUTH MECHANICAL MEZZANINE PLANS - HVAC
- M302 ENLARGED MECHANICAL ROOM PLAN - HVAC
- M500 FLOW DIAGRAMS DEMOLITION - HVAC
- M501 FLOW DIAGRAMS - HVAC
- M600 CONTROL SCHEMATICS - HVAC
- M601 CONTROL SCHEMATICS - HVAC
- M602 CONTROL SCHEMATICS - HVAC
- M603 CONTROL SCHEMATICS - HVAC
- M800 SCHEDULES - HVAC
- M900 DETAILS - HVAC
- M901 DETAILS - HVAC
- M902 DETAILS - HVAC
- MS200 GEOTHERMAL SITE PLAN - HVAC

## ELECTRICAL

**JDR ENGINEERING, INC.**  
5525 NOBEL DR #110  
MADISON, WI 53711  
PH 608-277-1728

- E000 SYMBOLS, ABBREVIATIONS & DETAILS - ELECTRICAL
- E100 OVERALL FIRST FLOOR DEMOLITION PLAN - POWER AND SYSTEMS
- E101 FIRST FLOOR PARTIAL DEMOLITION PLAN - POWER AND SYSTEMS
- E102 FIRST FLOOR PARTIAL DEMOLITION PLAN - LIGHTING
- E200 OVERALL FIRST FLOOR PLAN - POWER AND SYSTEMS
- E201 FIRST FLOOR PLAN - LIGHTING
- E202 FIRST FLOOR PLAN - POWER AND SYSTEMS
- E300 LARGE SCALE PLANS - ELECTRICAL
- E301 ONE-LINE DIAGRAM - MEZZANINE
- E600 ONE-LINE DIAGRAM - EXISTING/DEMOLITION
- E601 ONE-LINE DIAGRAM - EXISTING/NEW WORK
- E800 SCHEDULES - CONNECTIONS
- E801 SCHEDULES - EQUIPMENT AND LIGHTING
- E802 SCHEDULES - PANELS

ISSUED FOR:  
DD REVIEW 1/31/2024

REVISION FOR:  
NO. DESCRIPTION DATE

REVIEW SET - NOT FOR CONSTRUCTION


DRAWN BY Author

CHECKED BY Checker


## EXTERIOR RENDERING



## PROJECT LOCATION

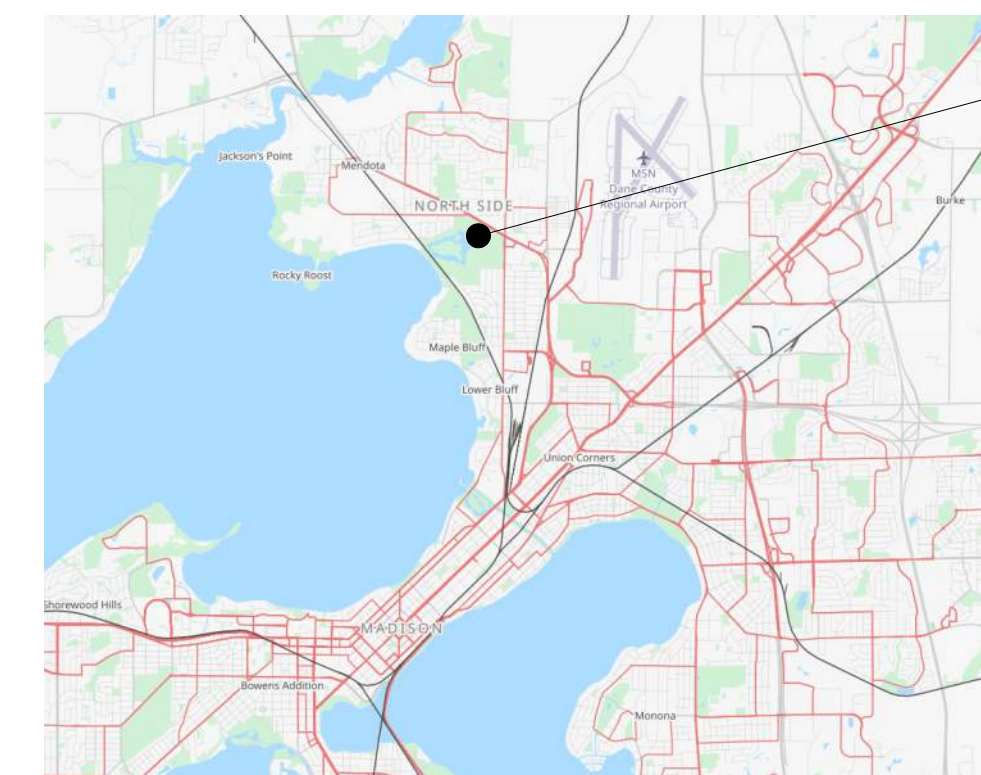

**BUILDING ADDRESS:**  
1625 NORTHPORT DRIVE  
MADISON, WI 53704

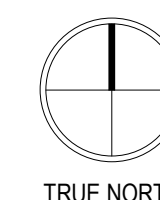

SITE LOCATION MAP

TITLE SHEET

# T100

**WARNER PARK  
COMMUNITY  
RECREATION CENTER  
EXPANSION**

1625 NORTHPORT DRIVE  
MADISON, WI 53704  
CITY OF MADISON PARKS DIVISION  
CITY-COUNTY BUILDING, ROOM 104  
210 MARTIN LUTHER KING, JR. BLVD  
MADISON, WI 53703

PROJECT NUMBER 223471.00

ISSUED FOR:

DD REVIEW 01/31/2024

REVISION FOR:

NO.	DESCRIPTION	DATE



**REVIEW SET - NOT  
FOR CONSTRUCTION**

DRAWN BY CHG/MRA

CHECKED BY KJY

SITE PLAN

**C301**

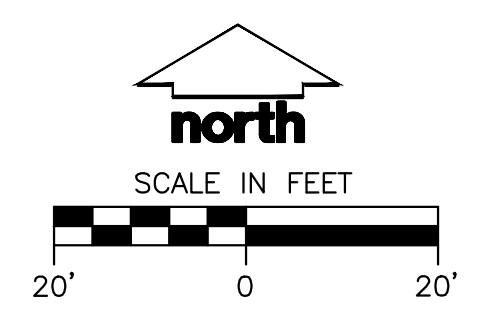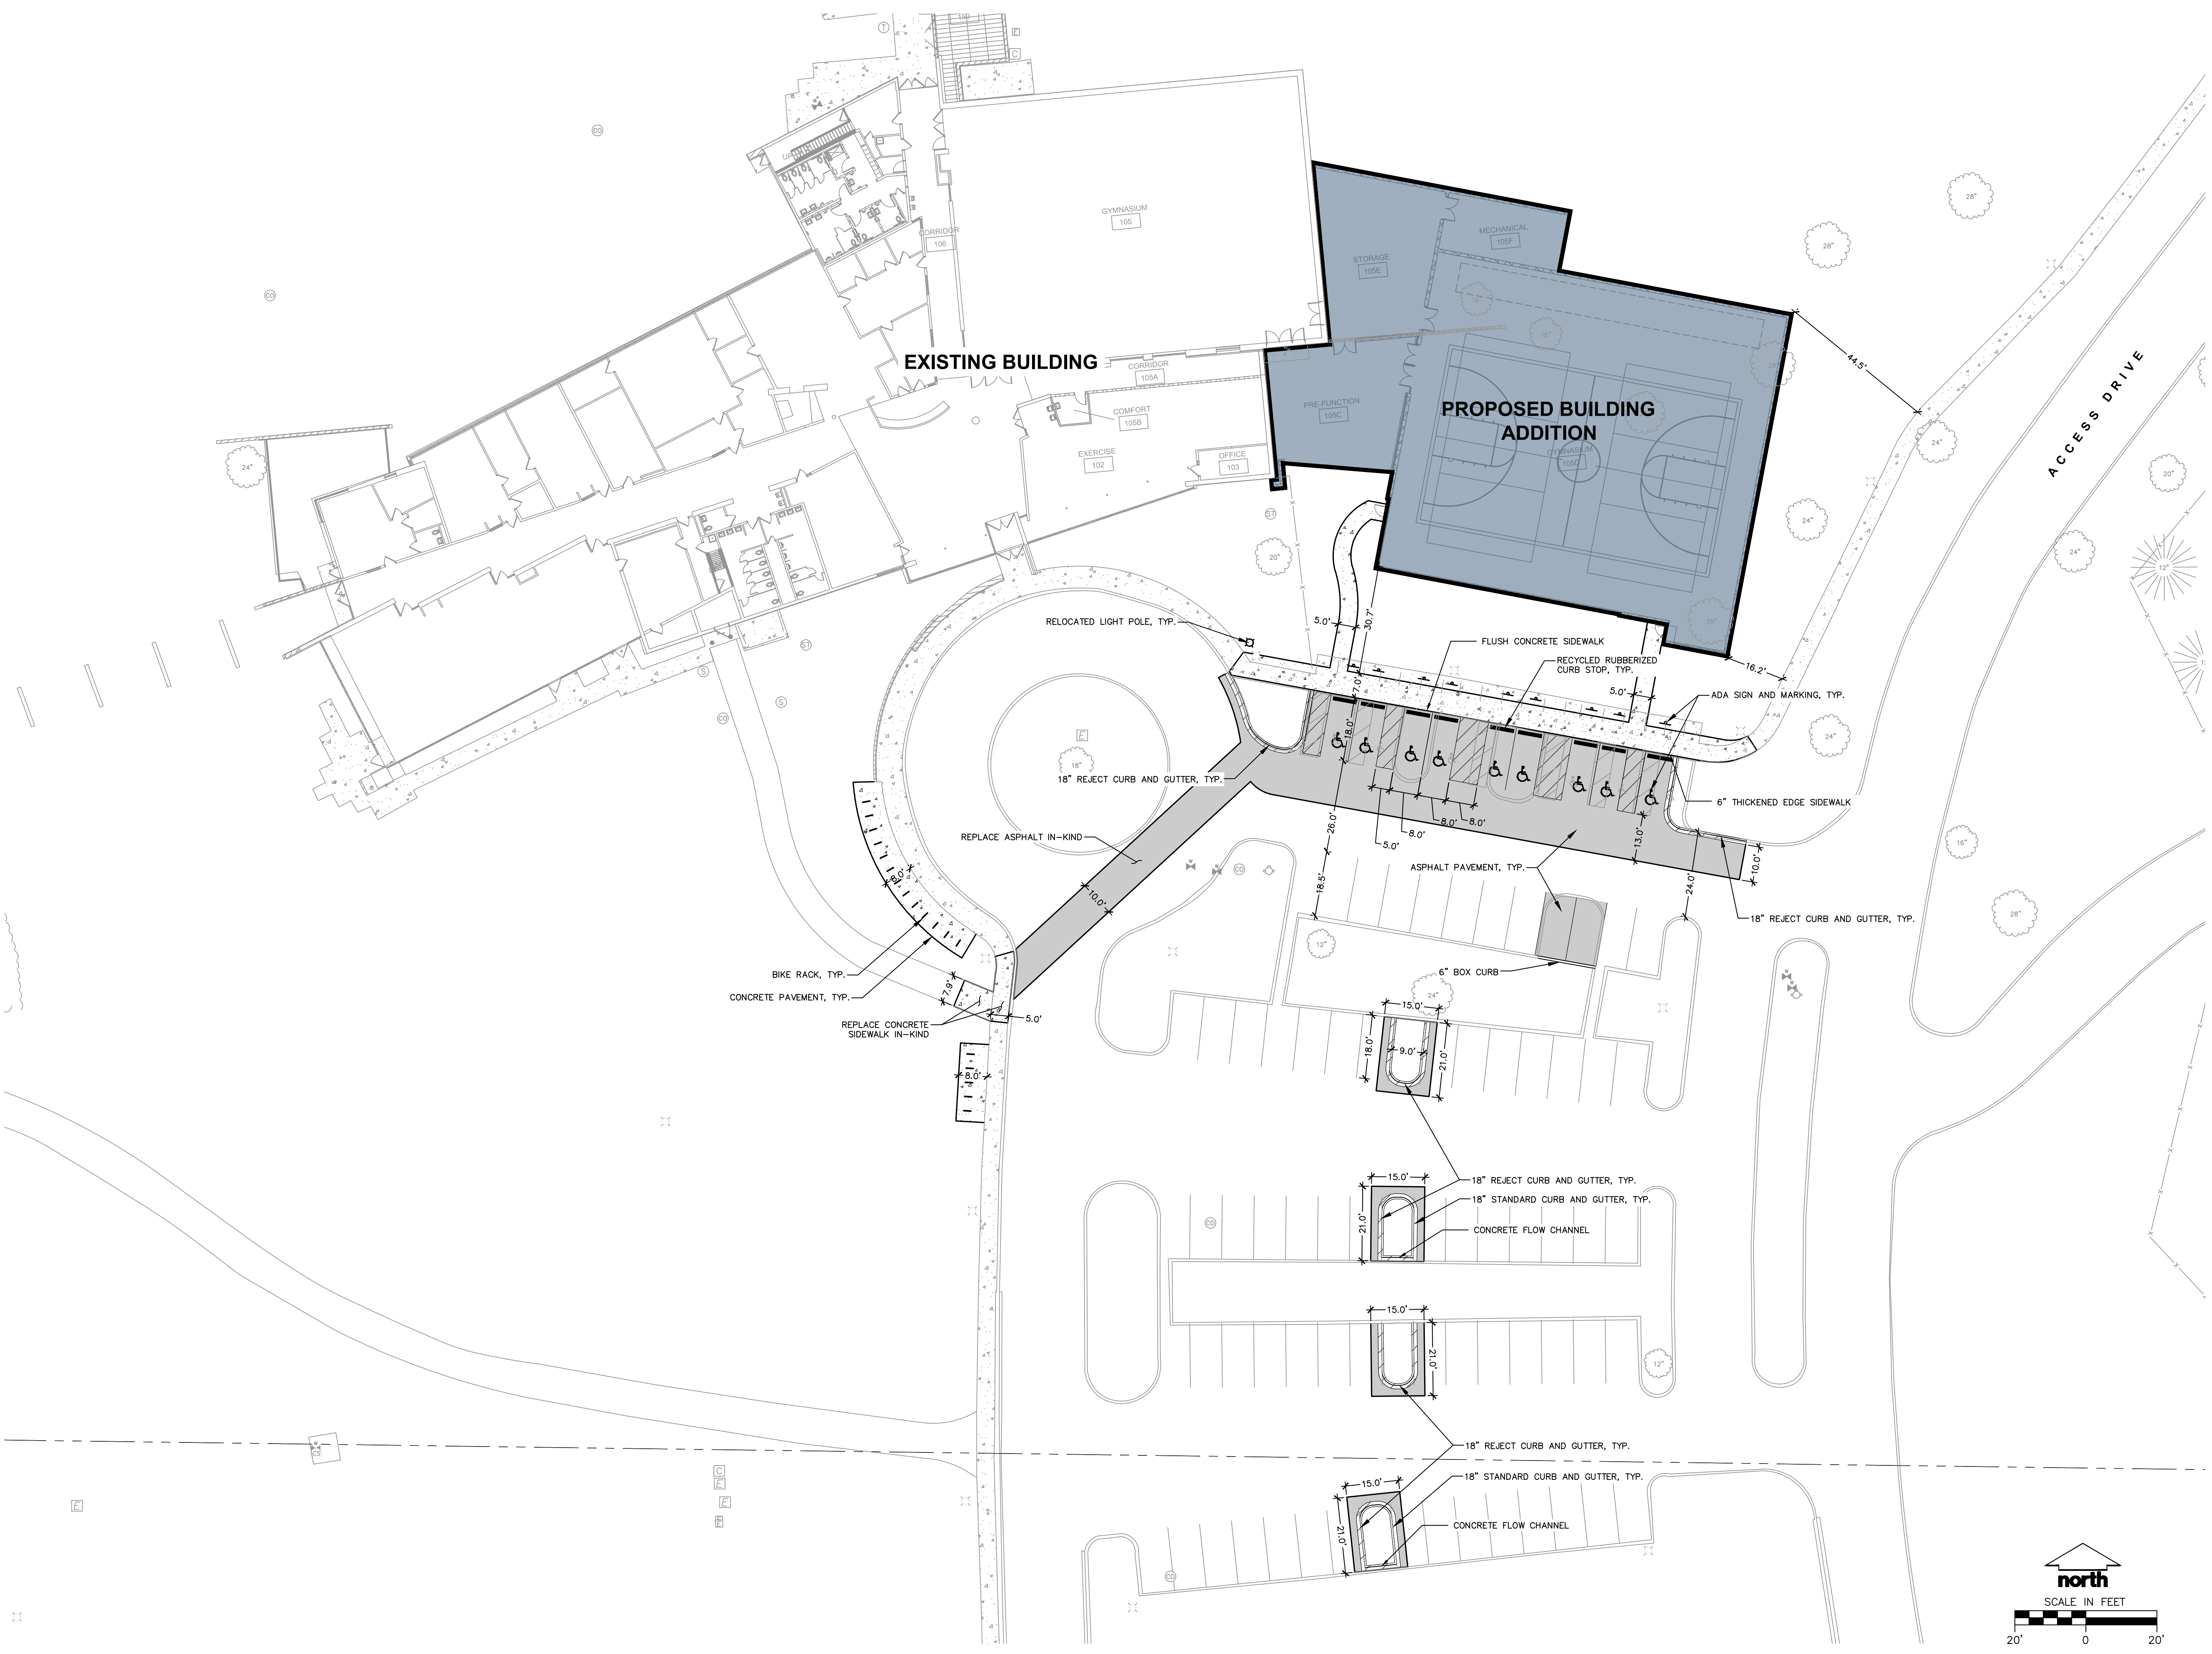

**WARNER PARK  
COMMUNITY RECREATION  
CENTER EXPANSION**

1625 NORTHPORT DRIVE  
MADISON, WI 53704  
CITY OF MADISON PARKS DIVISION  
330 EAST LAKESIDE STREET  
MADISON, WI 53715

PROJECT NUMBER 223471.00

ISSUED FOR:

DD REVIEW 1/31/2024

REVISION FOR:


NO.	DESCRIPTION	DATE

**REVIEW SET - NOT  
FOR CONSTRUCTION**


DRAWN BY Author

CHECKED BY Checker

**OVERALL FLOOR PLAN**

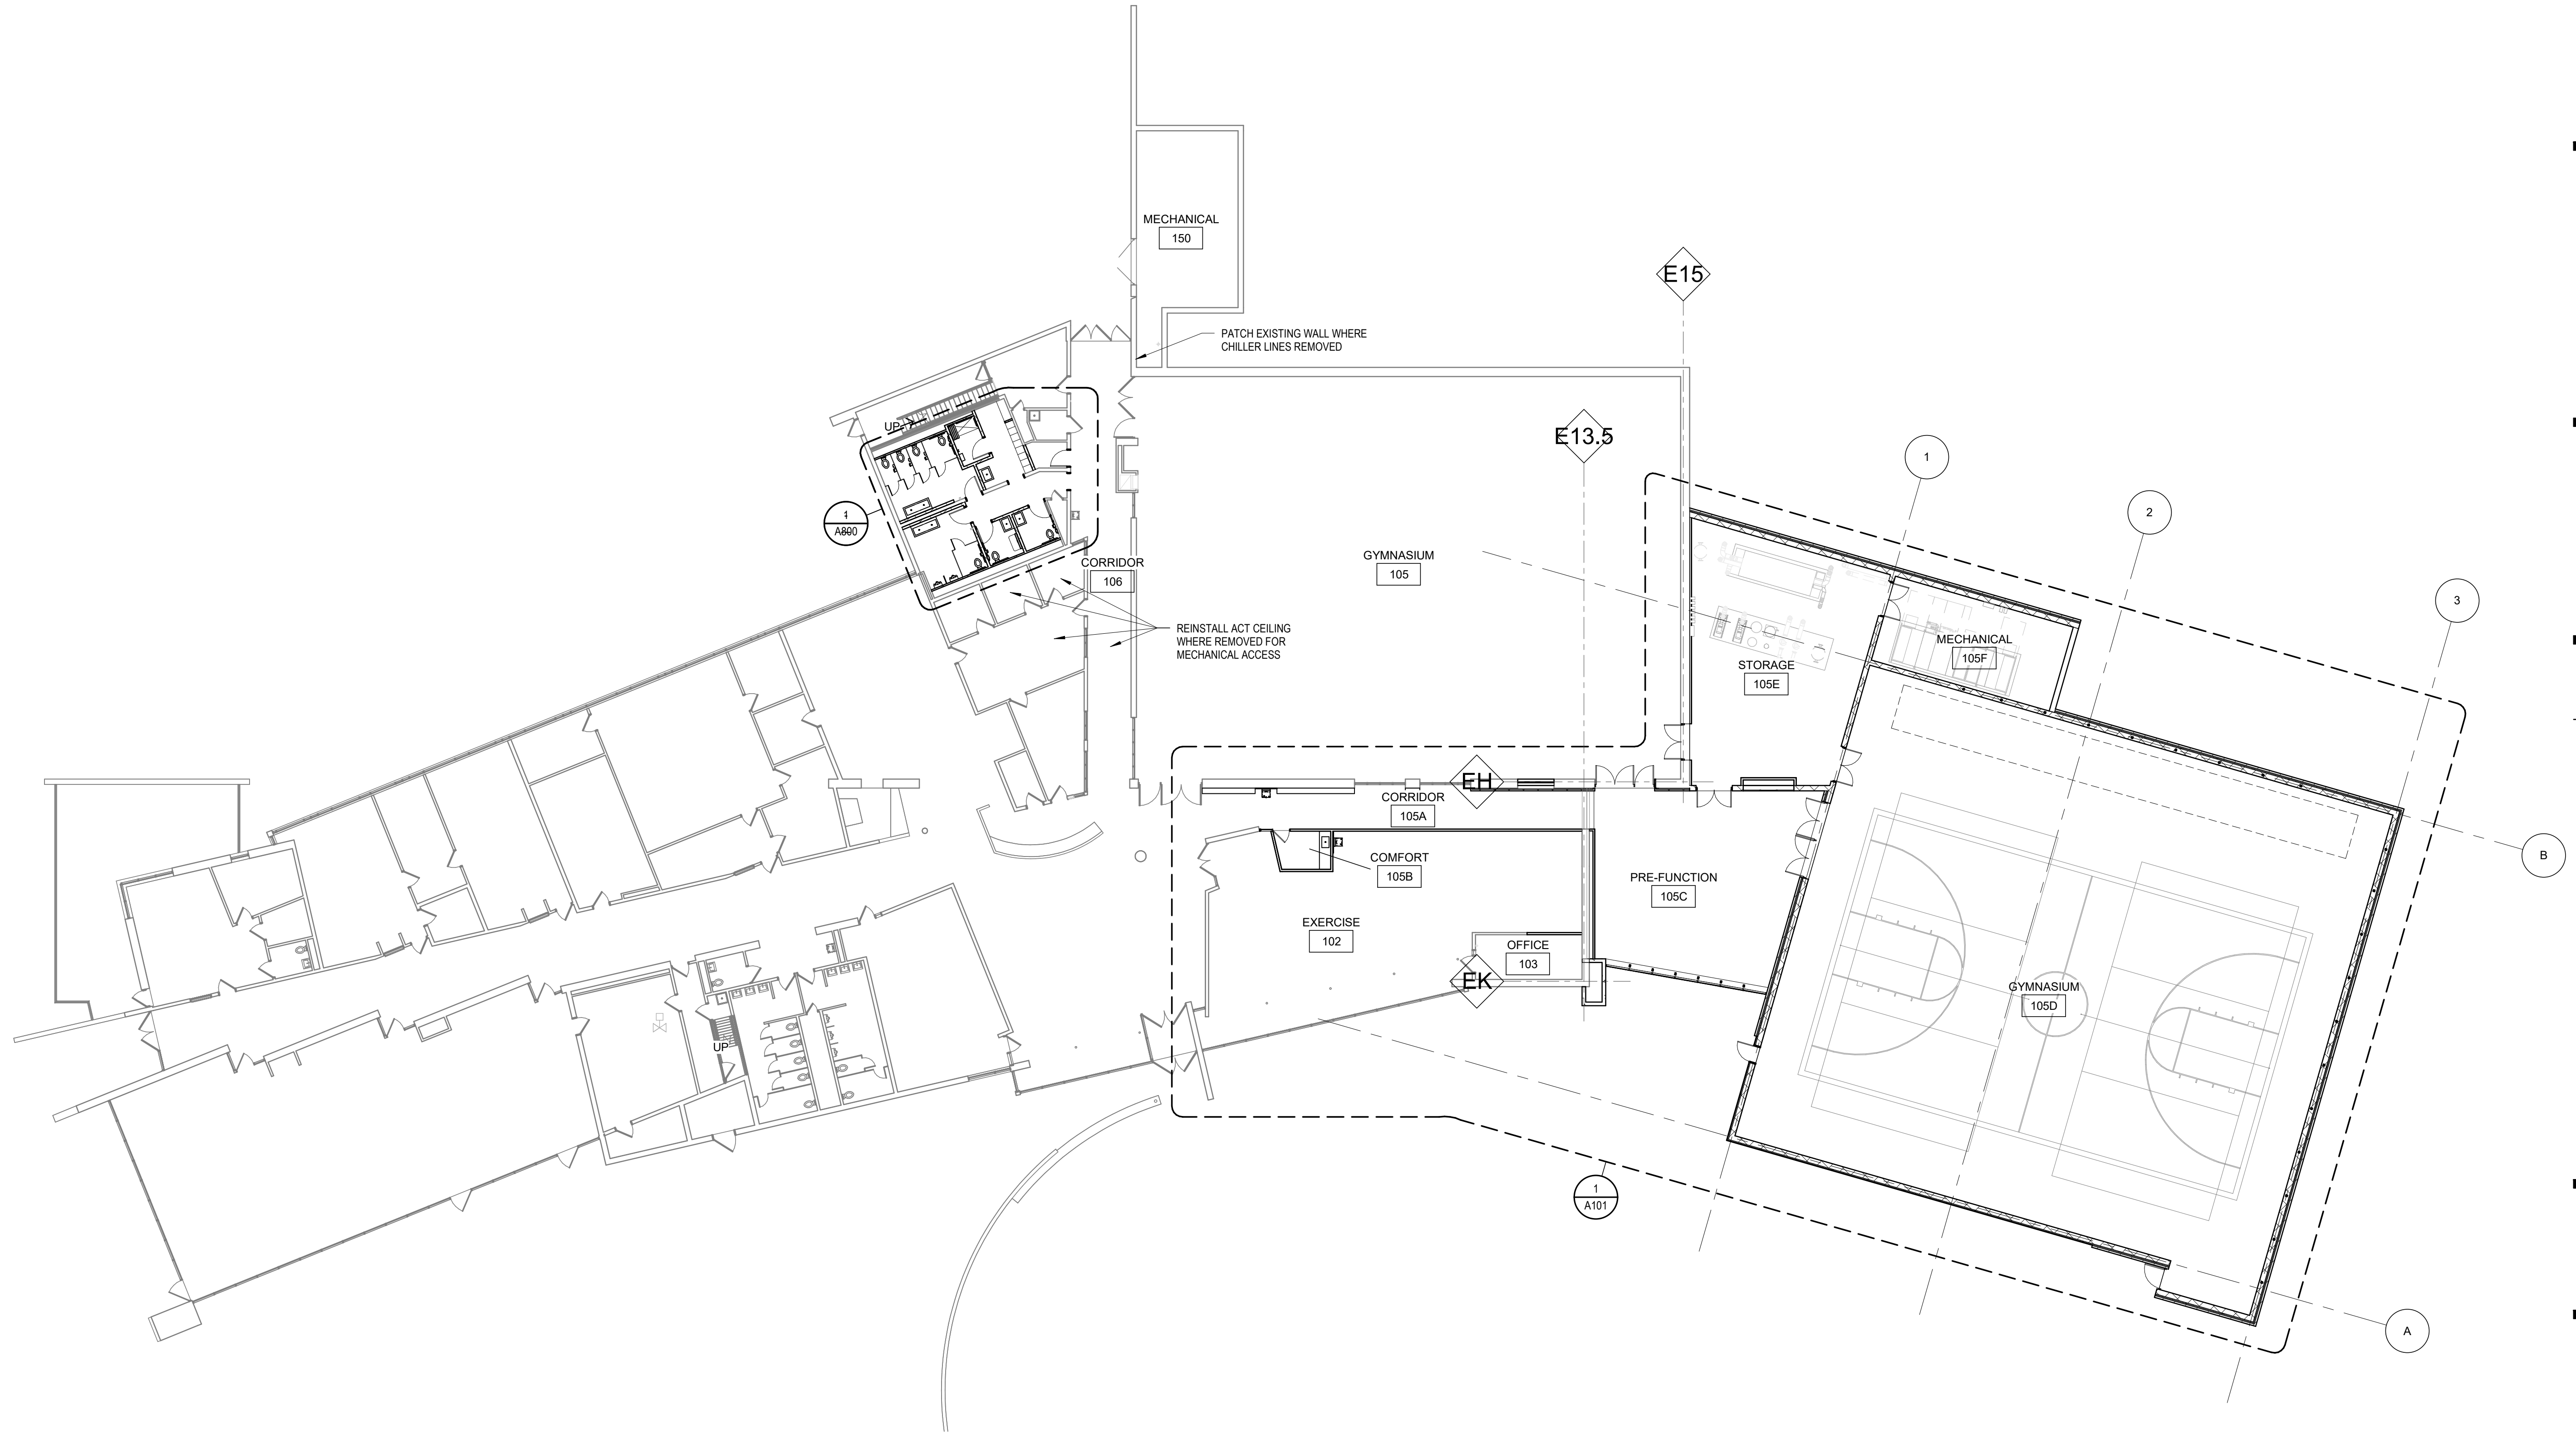

1 OVERALL FIRST FLOOR PLAN  
SCALE: 1/16" = 1'-0"  
0' 4' 8' 16'

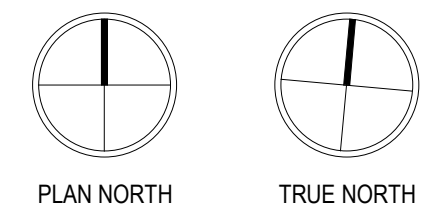

**A100**