
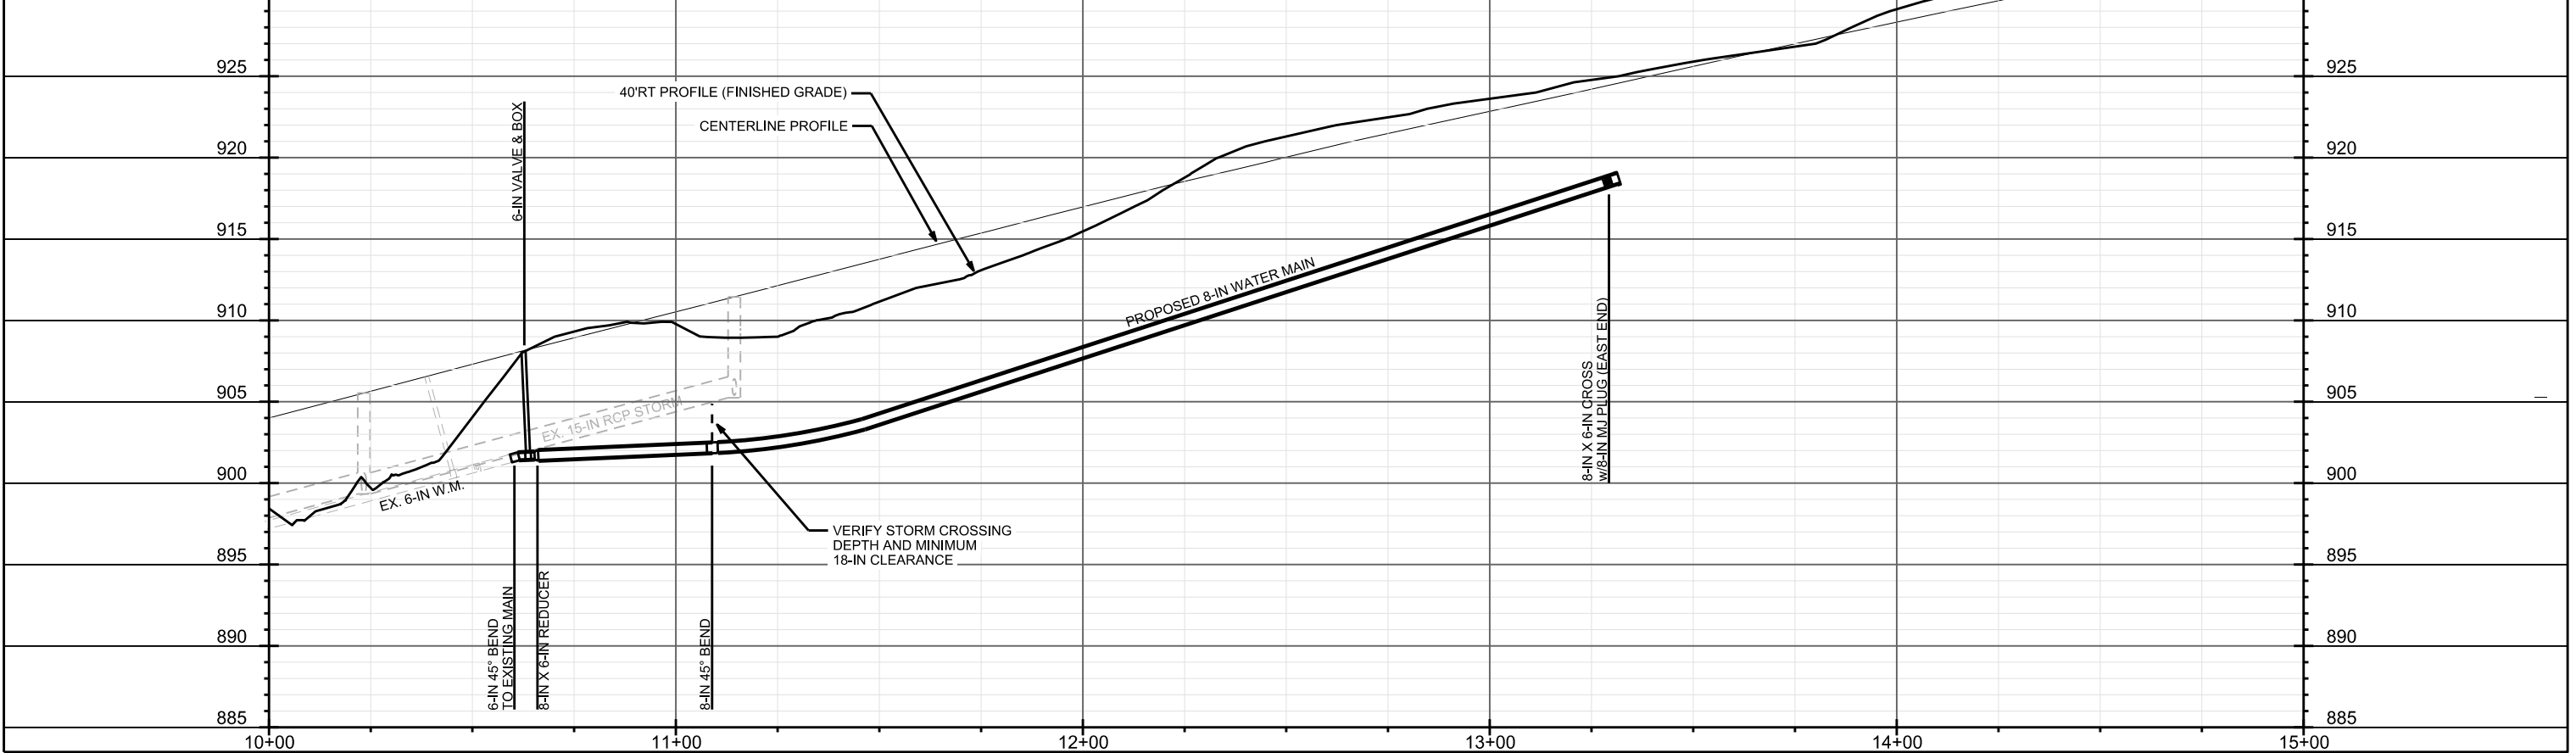


PRELIMINARY

NOT FOR CONSTRUCTION

600 BLOCK W. BADGER ROAD WATER MAIN		SHEET NO.
PROJECT NO. 53W1486 / CONTRACT NO. 6931		W-1
WATER MAIN PLAN AND PROFILE		
W. BADGER RD.		CITY OF MADISON
PM: DENNIS CAWLEY	DESIGNER: PEH	

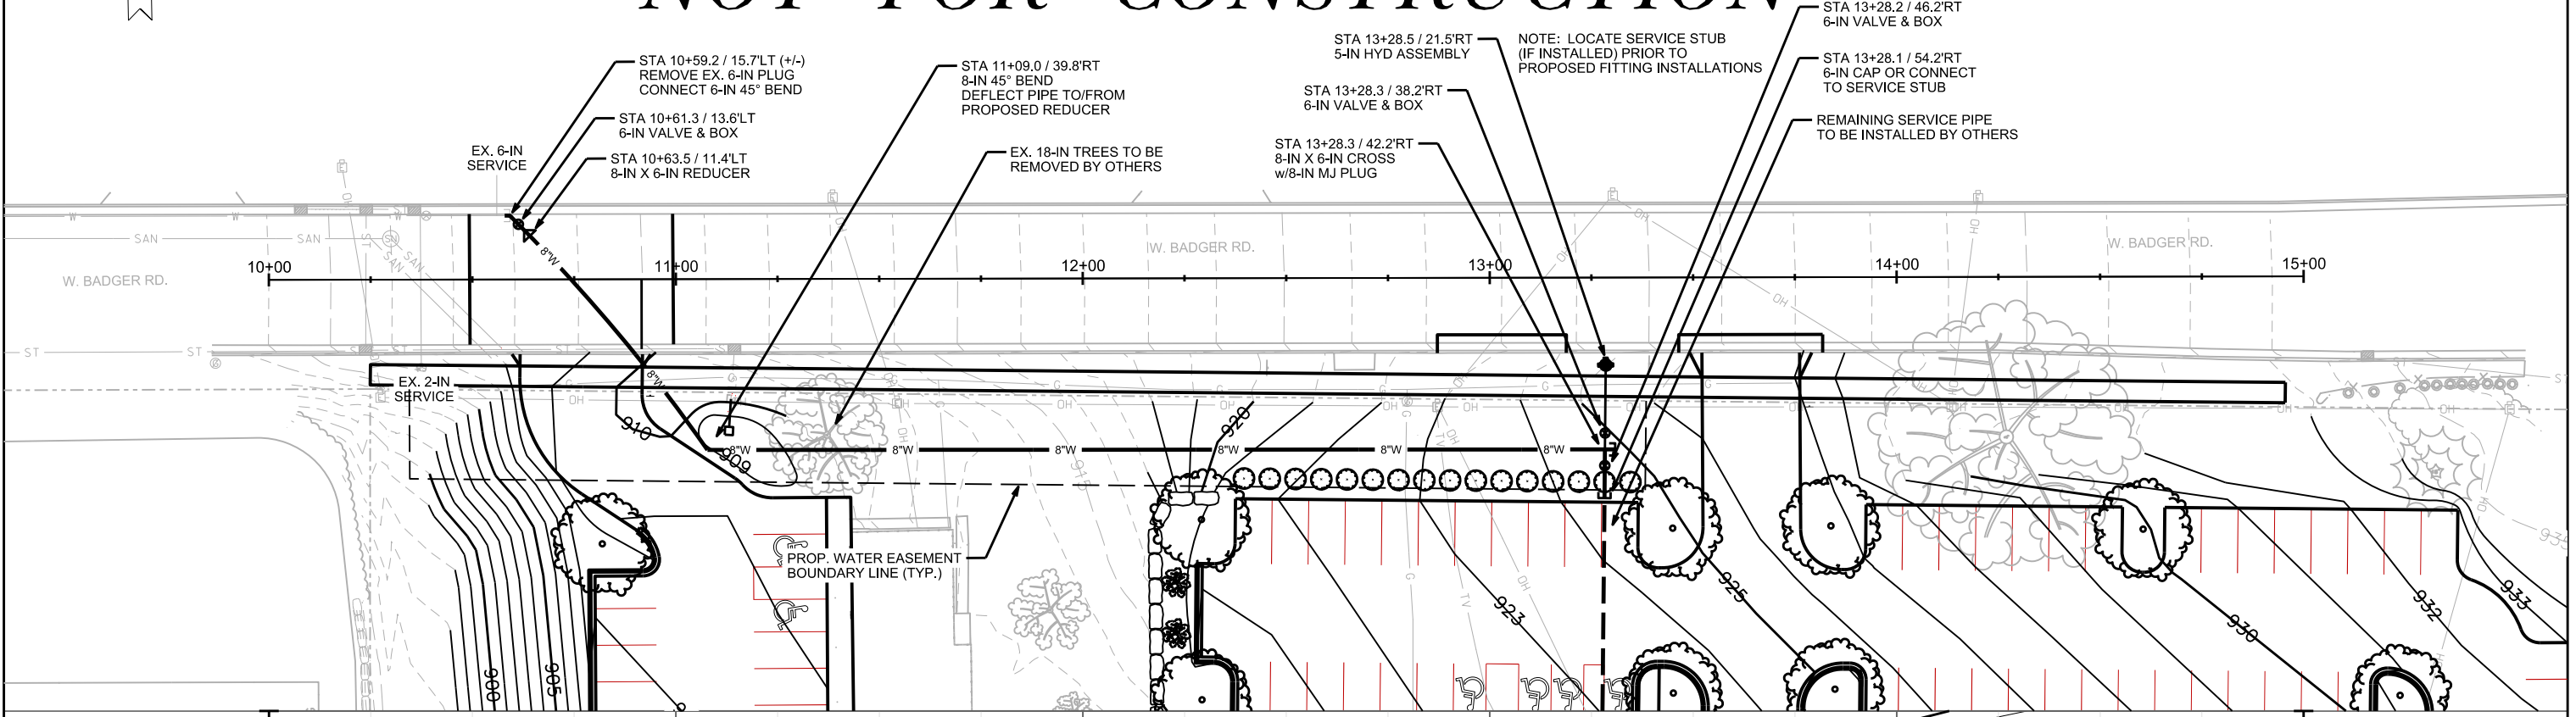

PLOT SCALE: _____
PLOT NAME: _____
REV. DATE: _____
ORIGINATOR: CITY OF MADISON, STREETS DIVISION