


# Exhibit A


(Page 1 of 2)

## Location Map

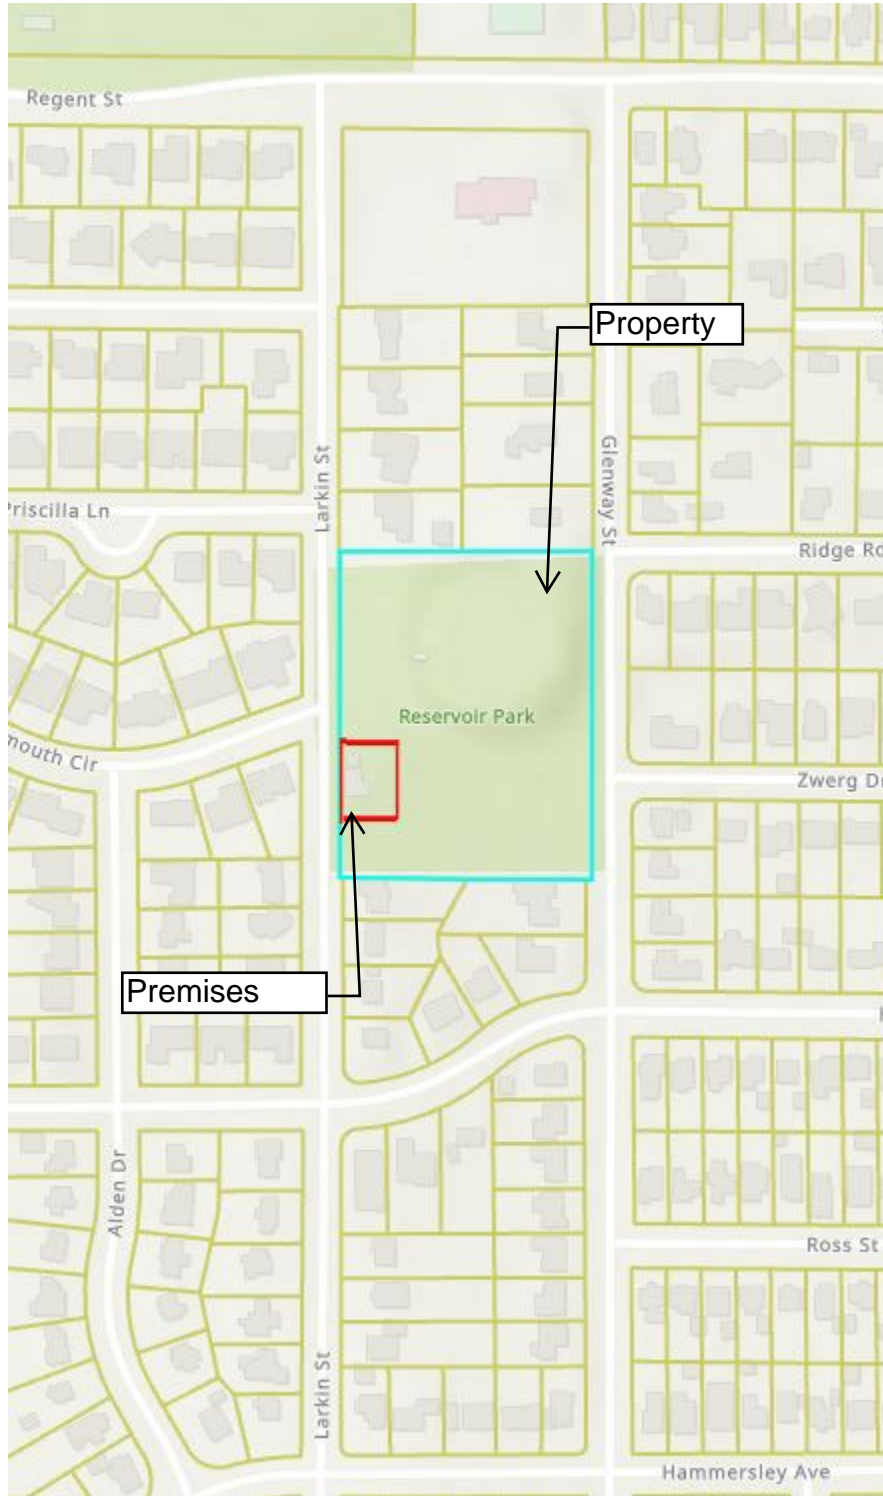


# Exhibit A

(Page 2 of 2)  
Site Plan

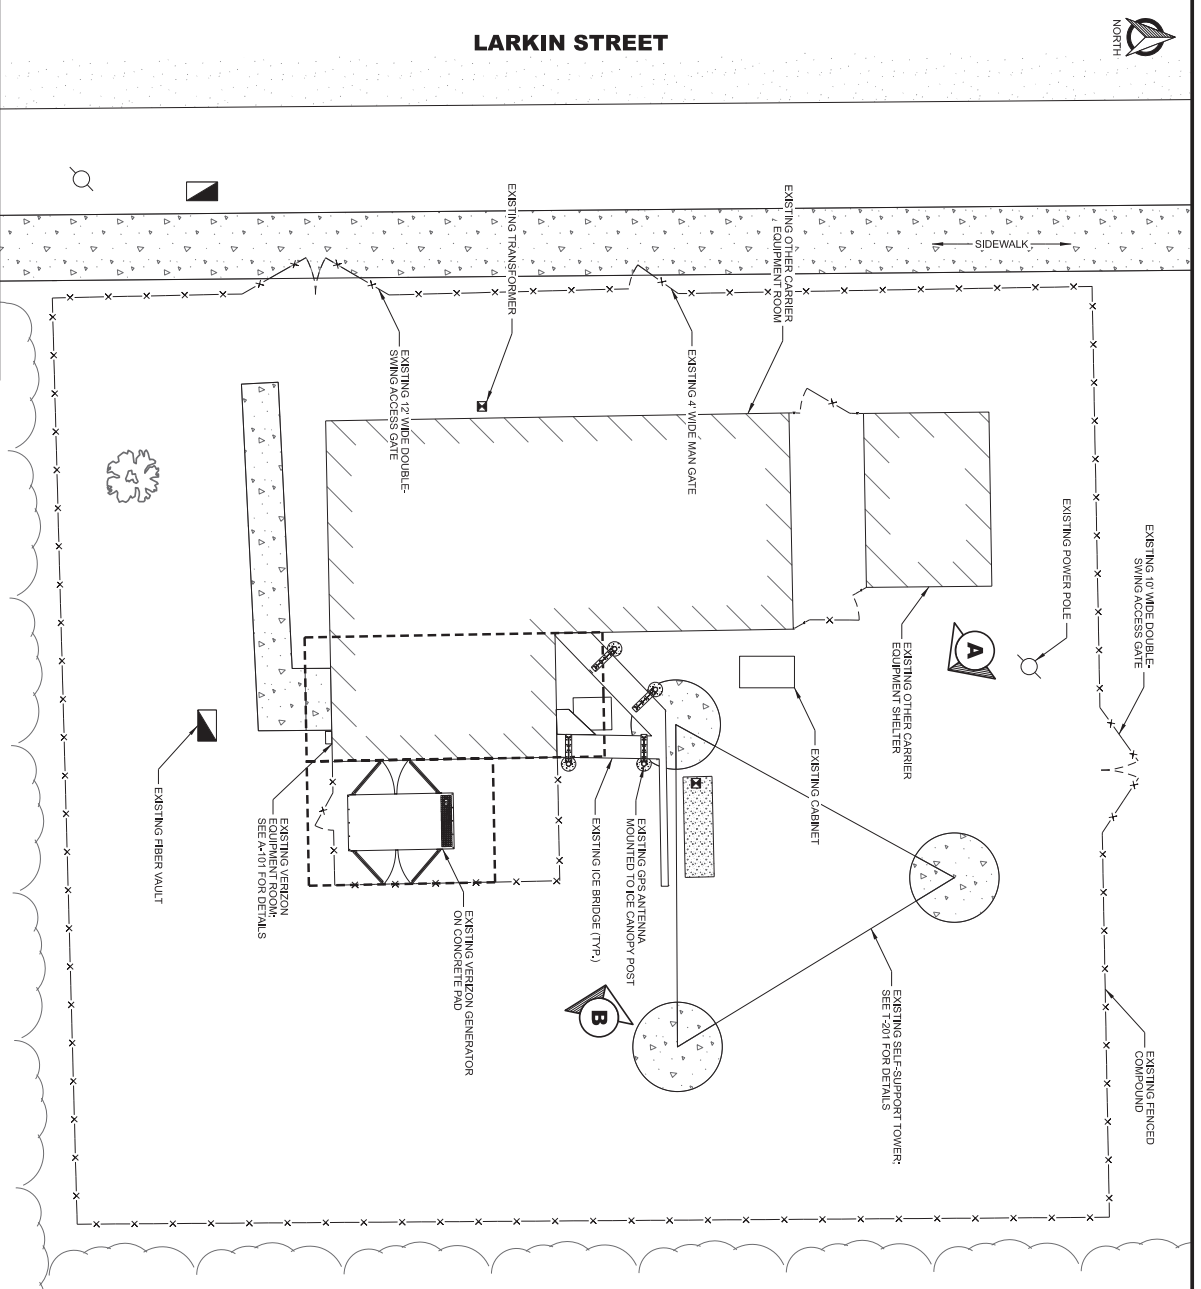

 - NOTES:
1. NORTH ARROW SHOWN AS APPROXIMATE.
  2. SITE PHOTOS PROVIDED BY EDGE CONSULTING ENGINEERS, INC.
  3. NO SURVEY AVAILABLE. SITE LAYOUT BASED ON FIELD MEASUREMENTS AND SITE PHOTOS.



**ENLARGED SITE PLAN**  
**LARKIN STREET (FUZE # 16825941)**  
**MADISON, WISCONSIN**

**Edge**  
Consulting Engineers, Inc.  
624 WATER STREET  
PO BOX 4448 CHICAGO  
CHICAGO, IL 60640  
www.edgeinc.com

**verizon**  
CHICAGO SATELLITE PARTNERSHIP  
1700 E. FIFTH AVE  
CHICAGO, IL 60610  
ROLLING MOUNTAIN, IL 60008

CLIENT:

SUBMITTAL:	
INT. DATE:	06/20/22
DATE:	06/20/22
DESCRIPTION:	REV. A
LTC:	06/20/22
REV.:	0
CHECKED BY:	DMB
DATE:	5/25/2022
PROJECT NUMBER:	33401
SET:	FINAL
SHEET NUMBER:	<b>C-102</b>