


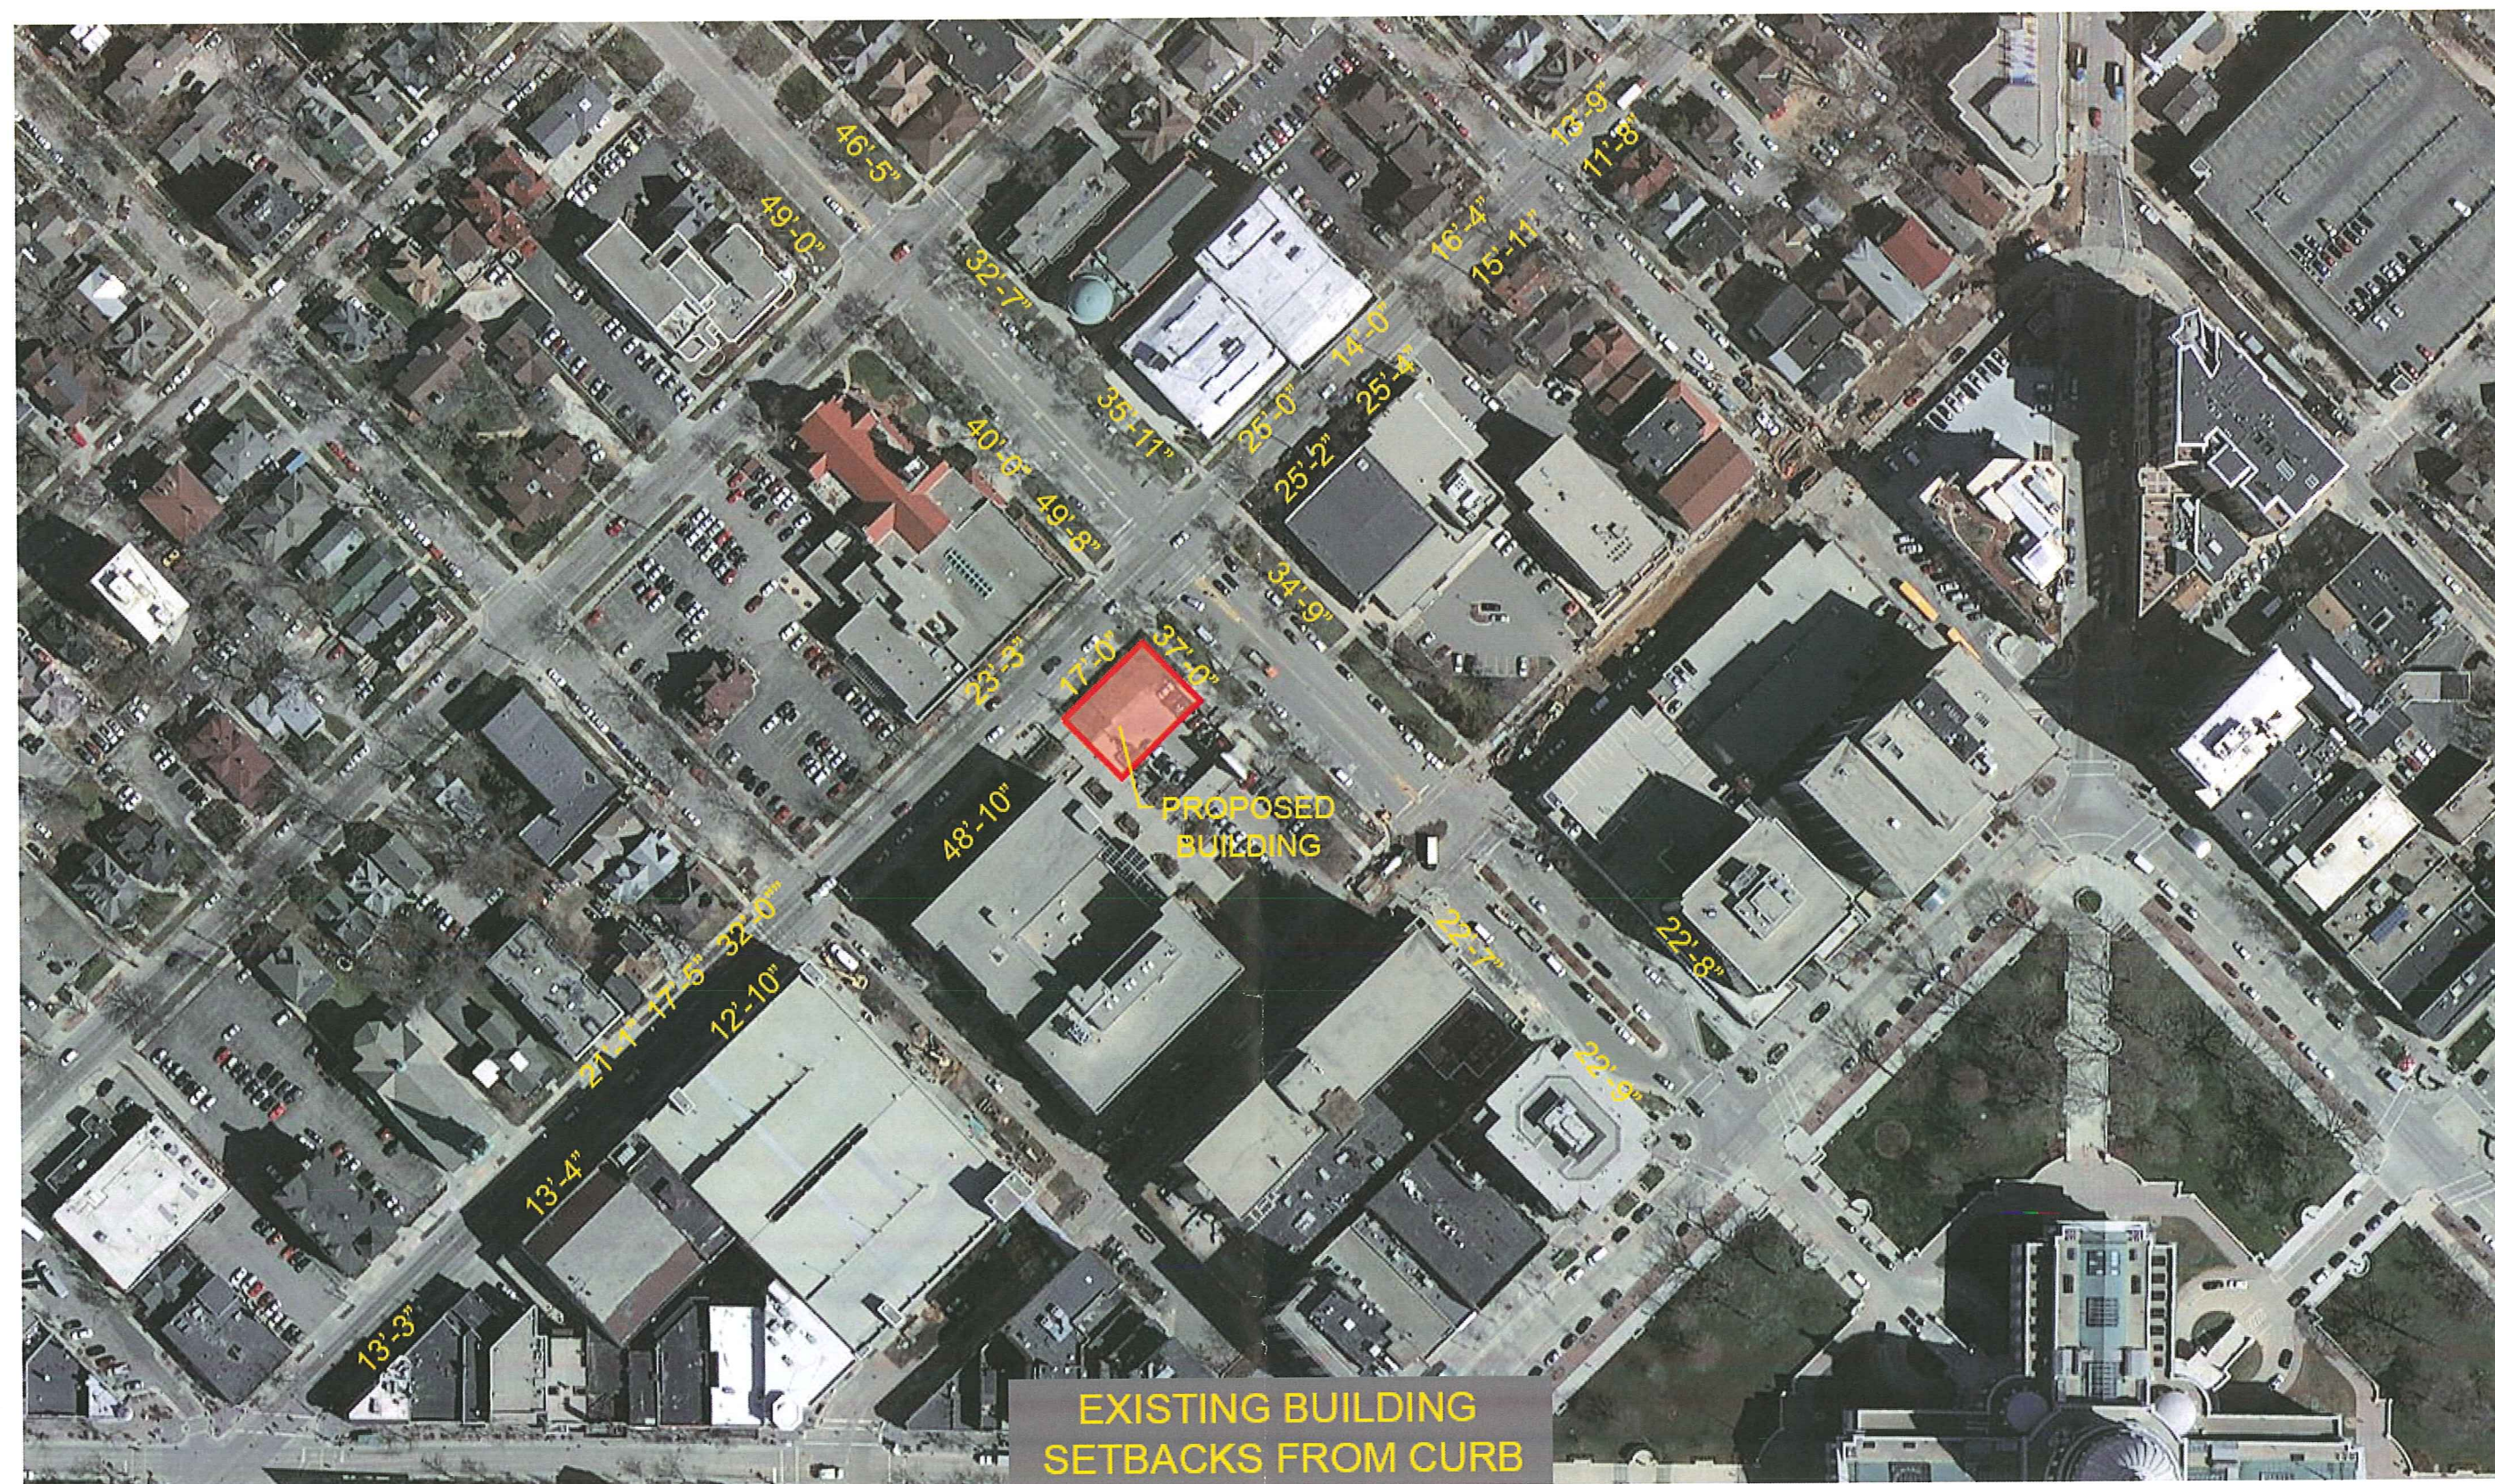


VGL 8-22-12 No. 2 Passport


LANDSCAPE POINT SCHEDULE

NUMBER OF TREES REQUIRED:		TABULATION OF POINTS PROVIDED:			
EXISTING SURFACE PARKING STALLS	20	CANOPY TREES	0pts	2	0
PROPOSED SURFACE PARKING STALLS	3	EXISTING CANOPY TREES	35pts	5	175
LOADING AREAS	1	ORNAMENTAL TREES	15pts	1	15
CANOPY TREES REQUIRED	2				
NUMBER OF LANDSCAPE POINTS REQUIRED:		TOTAL POINTS			
POINTS REQUIRED PER PARKING STALLS	112.4	190 pts			
POINTS REQUIRED PER LOADING AREA	75				
TOTAL POINTS REQUIRED	187				

Symbol	Botanical Name	Common Name	Size	Root	Quantity	Comments
SHADE TREES						
AF	Acer x freemanii 'Armstrong'	Armstrong Maple	3"	B&B	2	
AG	Amelanchier x grandiflora 'Robin Hill'	Robin Hill Serviceberry	2"	B&B	1	Multi-Stem
EVERGREEN SHRUBS						
Jc	Juniperus chinensis 'Aurea'	Gold Coast Juniper	5 Gal.	CG	3	
Jp	Juniperus procumbens 'Nana'	Dwarf Japanese Garden Juniper	3 Gal.	CG	6	
Tm	Taxus x media 'Runyan'	Runyan Yew	5 Gal.	CG	8	
DECIDUOUS SHRUBS						
Rn	Rosa x 'Noatraum'	Flower Carpet Pink Rose	3 Gal.	CG	4	
Vc	Viburnum carlesii 'JN Select A'	Spice Island Korean Spice Viburnum	5 Gal.	CG	9	
PERENNIALS, GRASSES, VINES						
ah	Amsonia hubrechtii x illustris	Hybrid Amsonia	1 Gal.	CG	15	
ca	Calamagrostis scutiflora 'Avalanche'	Ozark Bluestar	1 Gal.	CG	31	
cb	Calamagrostis brachytricha	Korean Feather Reed Grass	1 Gal.	CG	22	
cf	Calamagrostis scutiflora 'Karl Foerster'	Karl Foerster Feather Reed Grass	1 Gal.	CG	9	
cl	Chasmanthium latifolium	Northern Sea Oats	1 Gal.	CG	38	
gm	Geranium macrorrhizum 'Ingwersen's Variety'	Ingwersen's Variety Geranium	1 Gal.	CG	37	
ls	Liatris spicata 'Kobold'	Kobold Gayfeather	1 Gal.	CG	12	
sh	Sporobolus heterolepis 'Tara'	Tara Prairie Dropseed	1 Gal.	CG	60	

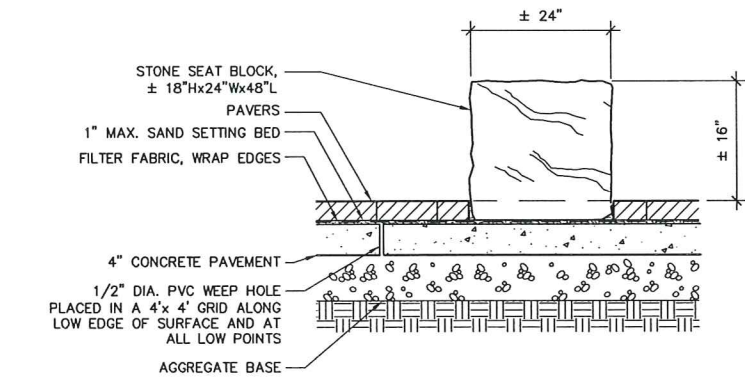

1 STONE SEAT BLOCK
L100
NTS

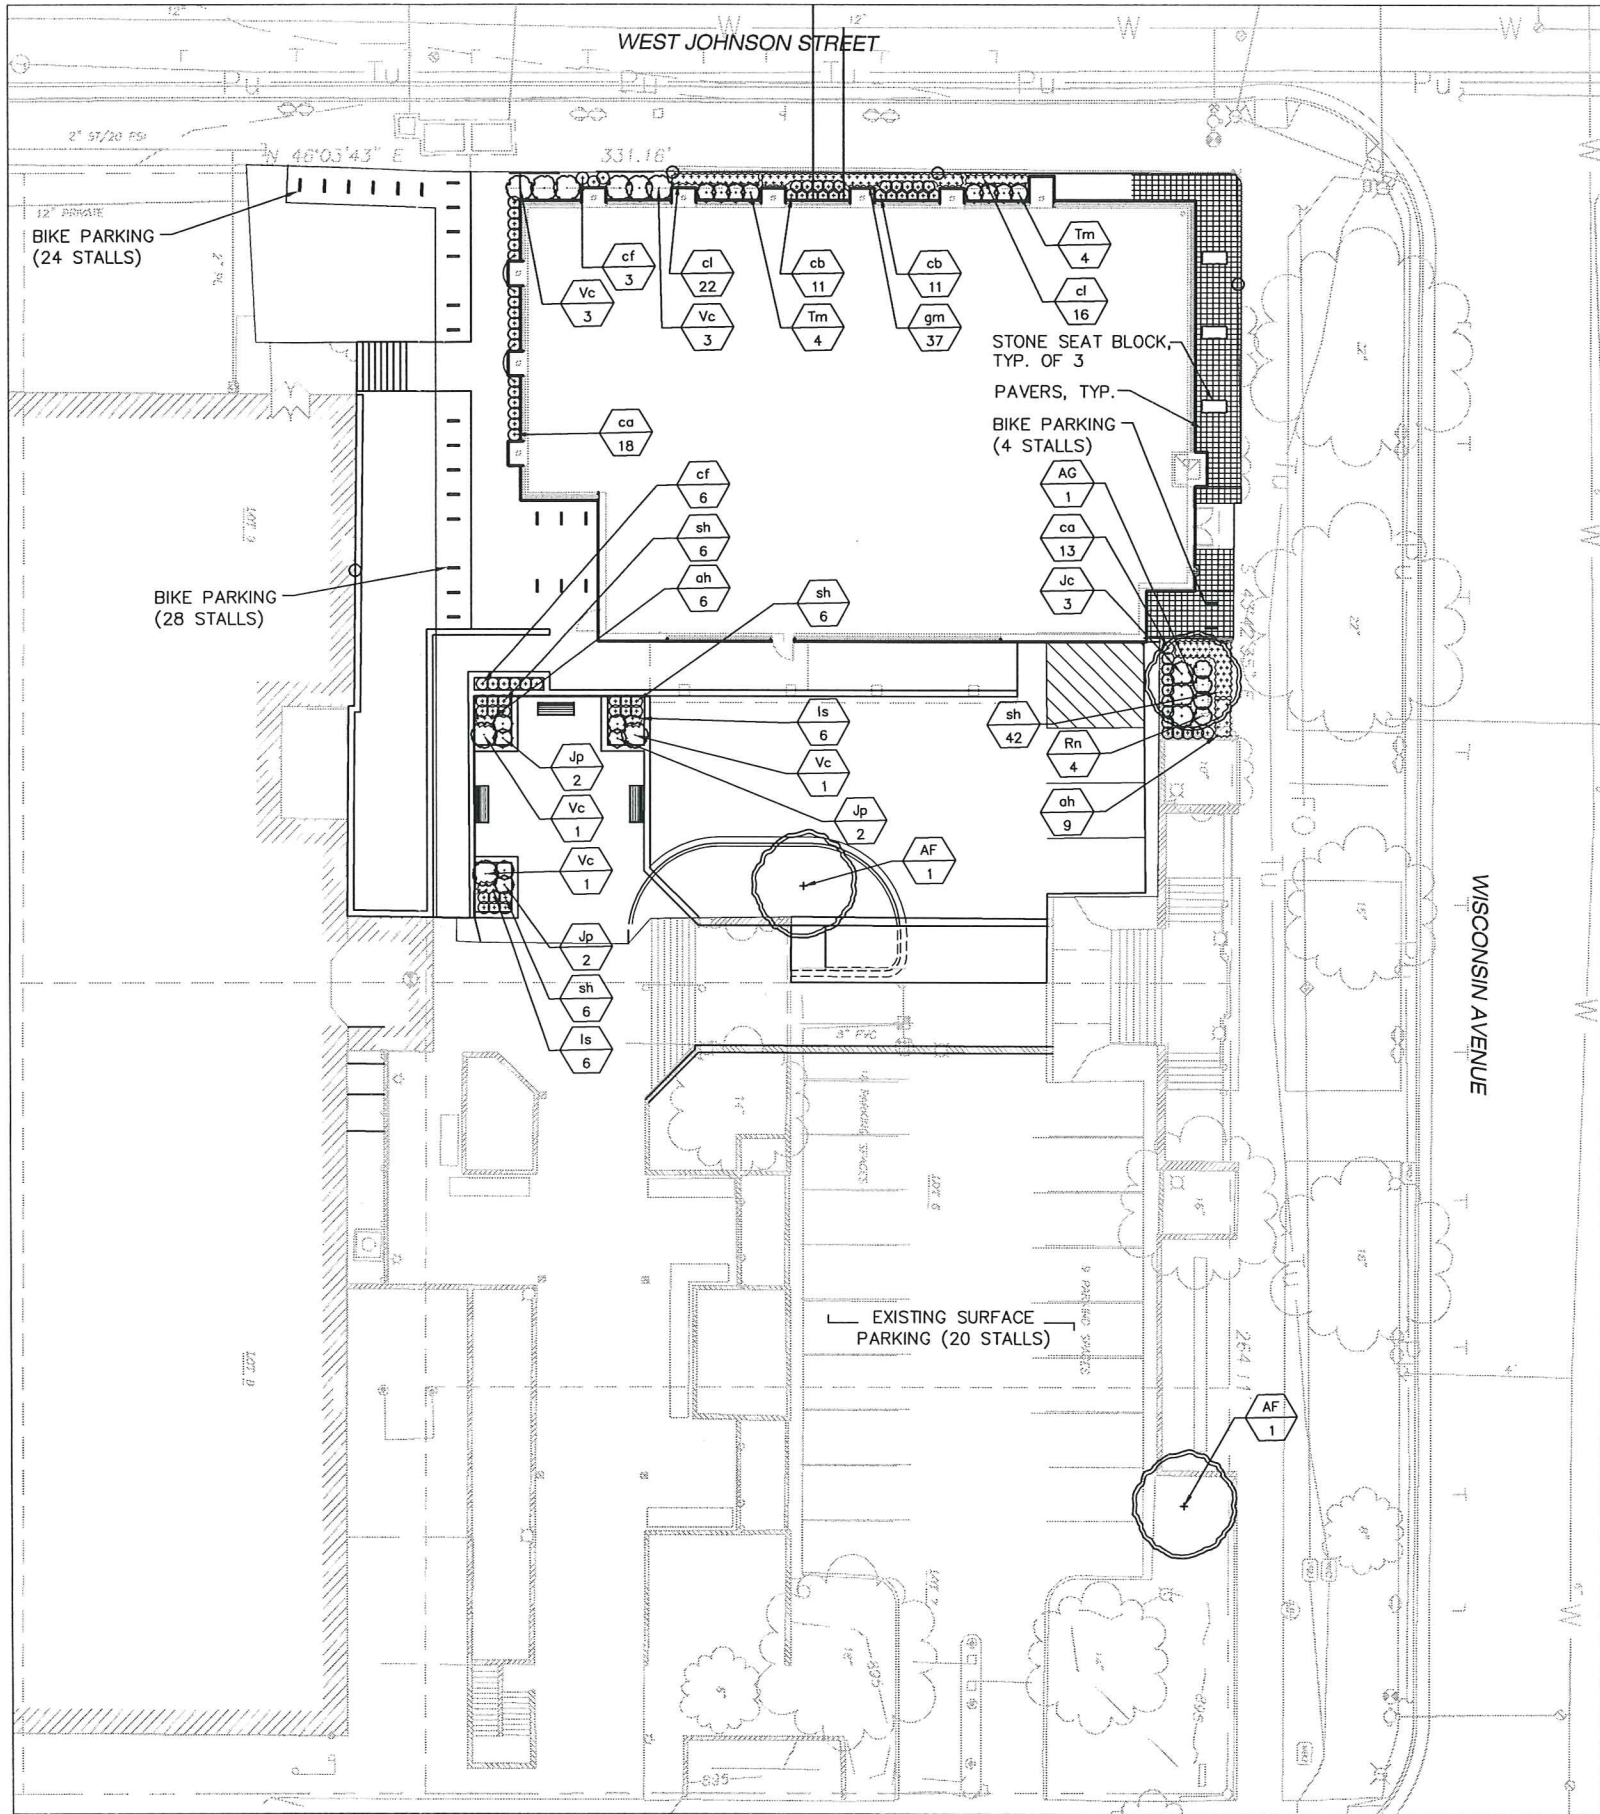

ARCHITECTURE
ENGINEERING
INTERIOR DESIGN

STRANG INC.
6411 MINERAL POINT ROAD
MADISON, WI 53705-4325
T/ 608 276 9200
F/ 608 276 9204

E.F.W.
E. F. WHITNEY, INC.
DESIGN CONSULTANTS OF
FOOD SERVICE FACILITIES

568 ANN STREET
BIRMINGHAM, AL 35203
248.644.0990 - VOICE
248.644.0177 - FAX
drawings@efwhitney.com
www.efwhitney.com

SAA DESIGN GROUP
SAA Design Group, Inc.
101 East Badger Road
Madison, WI 53713
Ph. 608.255.0800
Fx. 608.255.7730
www.saa-madison.com

DRAWING SET UDC
COPYRIGHT
FILE NAME
REVISIONS
DRAWN PH
CHECKED BY
DATE 08-15-12
PROJECT NO. 2012046
PROJECT TITLE

MADISON COLLEGE
CULINARY, BAKING &
HOSPITALITY
EDUCATION CENTER

MADISON, WISCONSIN
SHEET TITLE
LANDSCAPE PLAN

SHEET NO.
L100

upk 8-22-12 No. 2 Passport