 


CONSULTANTS

NO.	DATE	DESCRIPTION

REFER TO EQUIPMENT MANUFACTURER'S SHOP DRAWING



PLAN SHEET DESIGNATION

COVER	
G	GENERAL
H	HAZARDOUS MATERIALS
C	CIVIL
L	LANDSCAPE
S	STRUCTURAL
A	ARCHITECTURAL
I	INSTRUMENTATION
Q	EQUIPMENT
F	FIRE PROTECTION
P	PLUMBING
M	MECHANICAL
E	ELECTRICAL
T	TELECOMMUNICATIONS
R	RESOURCE


PROJECT NO:	120581.41
SCALE:	AS NOTED
DRAWING DATE:	
DESIGNED BY:	GDG
DRAWN BY:	TLB
CHECKED BY:	GDG

CLIENT
MADISON WATER UTILITY
MADISON, WISCONSIN

UNIT WELL 26
GENERATOR ADDITION

SHEET TITLE
EXISTING SITE PLAN

C-1
 2 OF

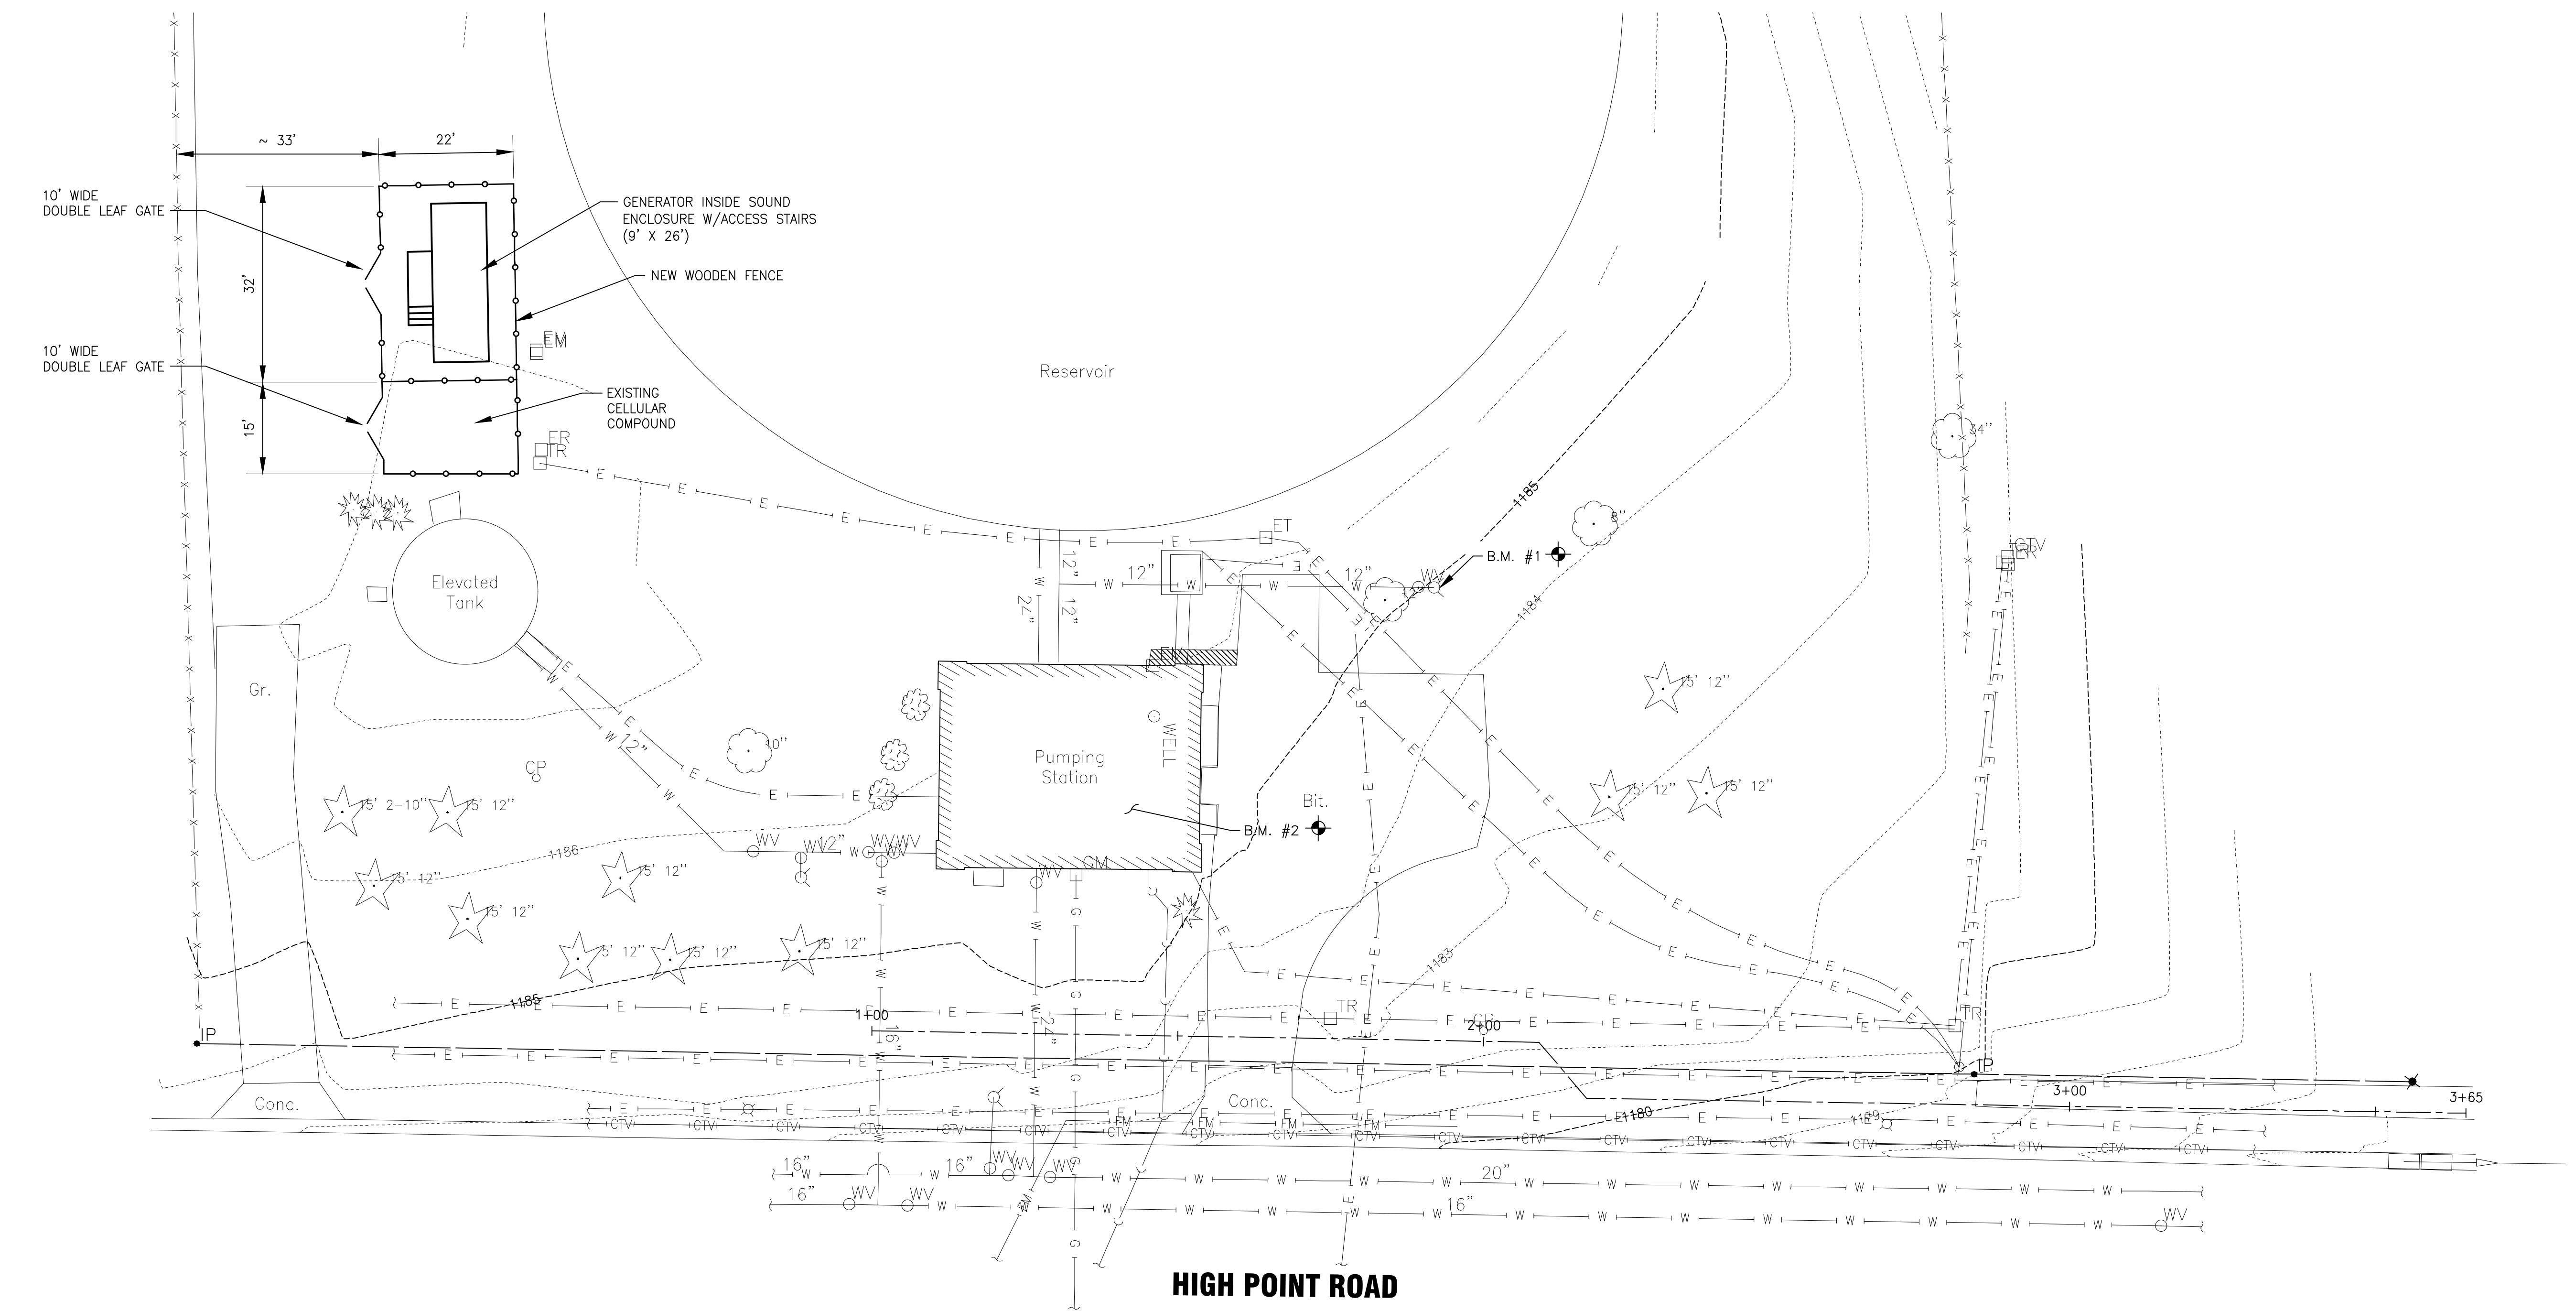

I:\BURLINGTON\MADUD\WELL 26\CADD\DRAWINGS\DWGS\120581_41-TOPO-C3D 2012.DWG Existing Site Plan
 Plotted: 8/8/2013 9:16 AM By: 0075LE
 Copyright © 2013, By Baxter & Woodman, Inc.
 State of Wisconsin - Professional Design Firm
 License No. - 484-0111 - Expires 11-31-14