

HOLY CROSS LUTHERAN
734 HOLY CROSS WAY
MADISON, WI

DEVELOPED BY:
HOLY CROSS LUTHERAN

GENERAL NOTES:

1. ALIGN SHEATHING WITH FOUNDATION WALL BELOW.
2. DIMENSIONS WITH "R" ARE SHOWN AS ROUGH OPENINGS FOR SPECIFIC PRODUCTS BASED ON CURRENT INFORMATION AVAILABLE. CONTRACTOR SHALL VERIFY AS APPROPRIATE.
3. ALL OTHER DIMENSIONS ARE TO FACE OF STUD. VERIFY ALL ROUGH & MASONRY OPENINGS w/APPROVED SHOP DRAWINGS.
4. CONTRACTOR TO INSTALL EQUIPMENT PER MANUFACTURER'S REQUIREMENTS.
5. PROVIDE GFI RECEPTACLES AS REQUIRED BY CODE.
6. ALL APPLIANCES SHALL BE OWNER PURCHASED, CONTRACTOR INSTALLED.
7. CONTRACTOR TO PROVIDE SOLID WOOD BLOCKING AS REQUIRED IN STUD WALLS WHICH ARE TO RECEIVE SURFACE MOUNTED EQUIPMENT, ACCESSORIES, CASEWORK, AND OWNER FURNISHED FURNITURE.
8. ALL PLUMBING FIXTURES SHALL BE ACCESSIBLE.
9. CONTRACTOR TO PROVIDE DESIGN-BUILD SERVICES FOR MECHANICAL, ELECTRICAL, PLUMBING, FIRE PROTECTION, FIRE ALARM AND LOW VOLTAGE. SUCH ITEMS SHALL BE INCLUDED IN BID.
10. EACH CONTRACTOR SHALL COORDINATE THEIR WORK WITH THE OWNER, THE OWNER'S OTHER CONTRACTORS, AND ALL OTHERS AT THE SITE.
11. MECHANICAL, PLUMBING, FIRE PROTECTION, AND ELECTRICAL WORK IS DESIGN BUILD. SUCH ITEMS ARE SHOWN FOR REFERENCE AND COORDINATION PURPOSES ONLY.


INFORMATION ON THIS DRAWING TAKES PRECEDENCE OVER THE SPECIFICATIONS MANUAL IF THE DOCUMENTS HAVE CONFLICTING INFORMATION.

NO.	DATE	BY	DESCRIPTION

OVERALL FIRST FLOOR PLAN

SCALE: As Indicated SHEET:
PROJECT #: 1203
DRAWN BY: BAB
CHKD BY: DCB
DATE: **A1.0**

2015-02-26 ADDENDUM 1

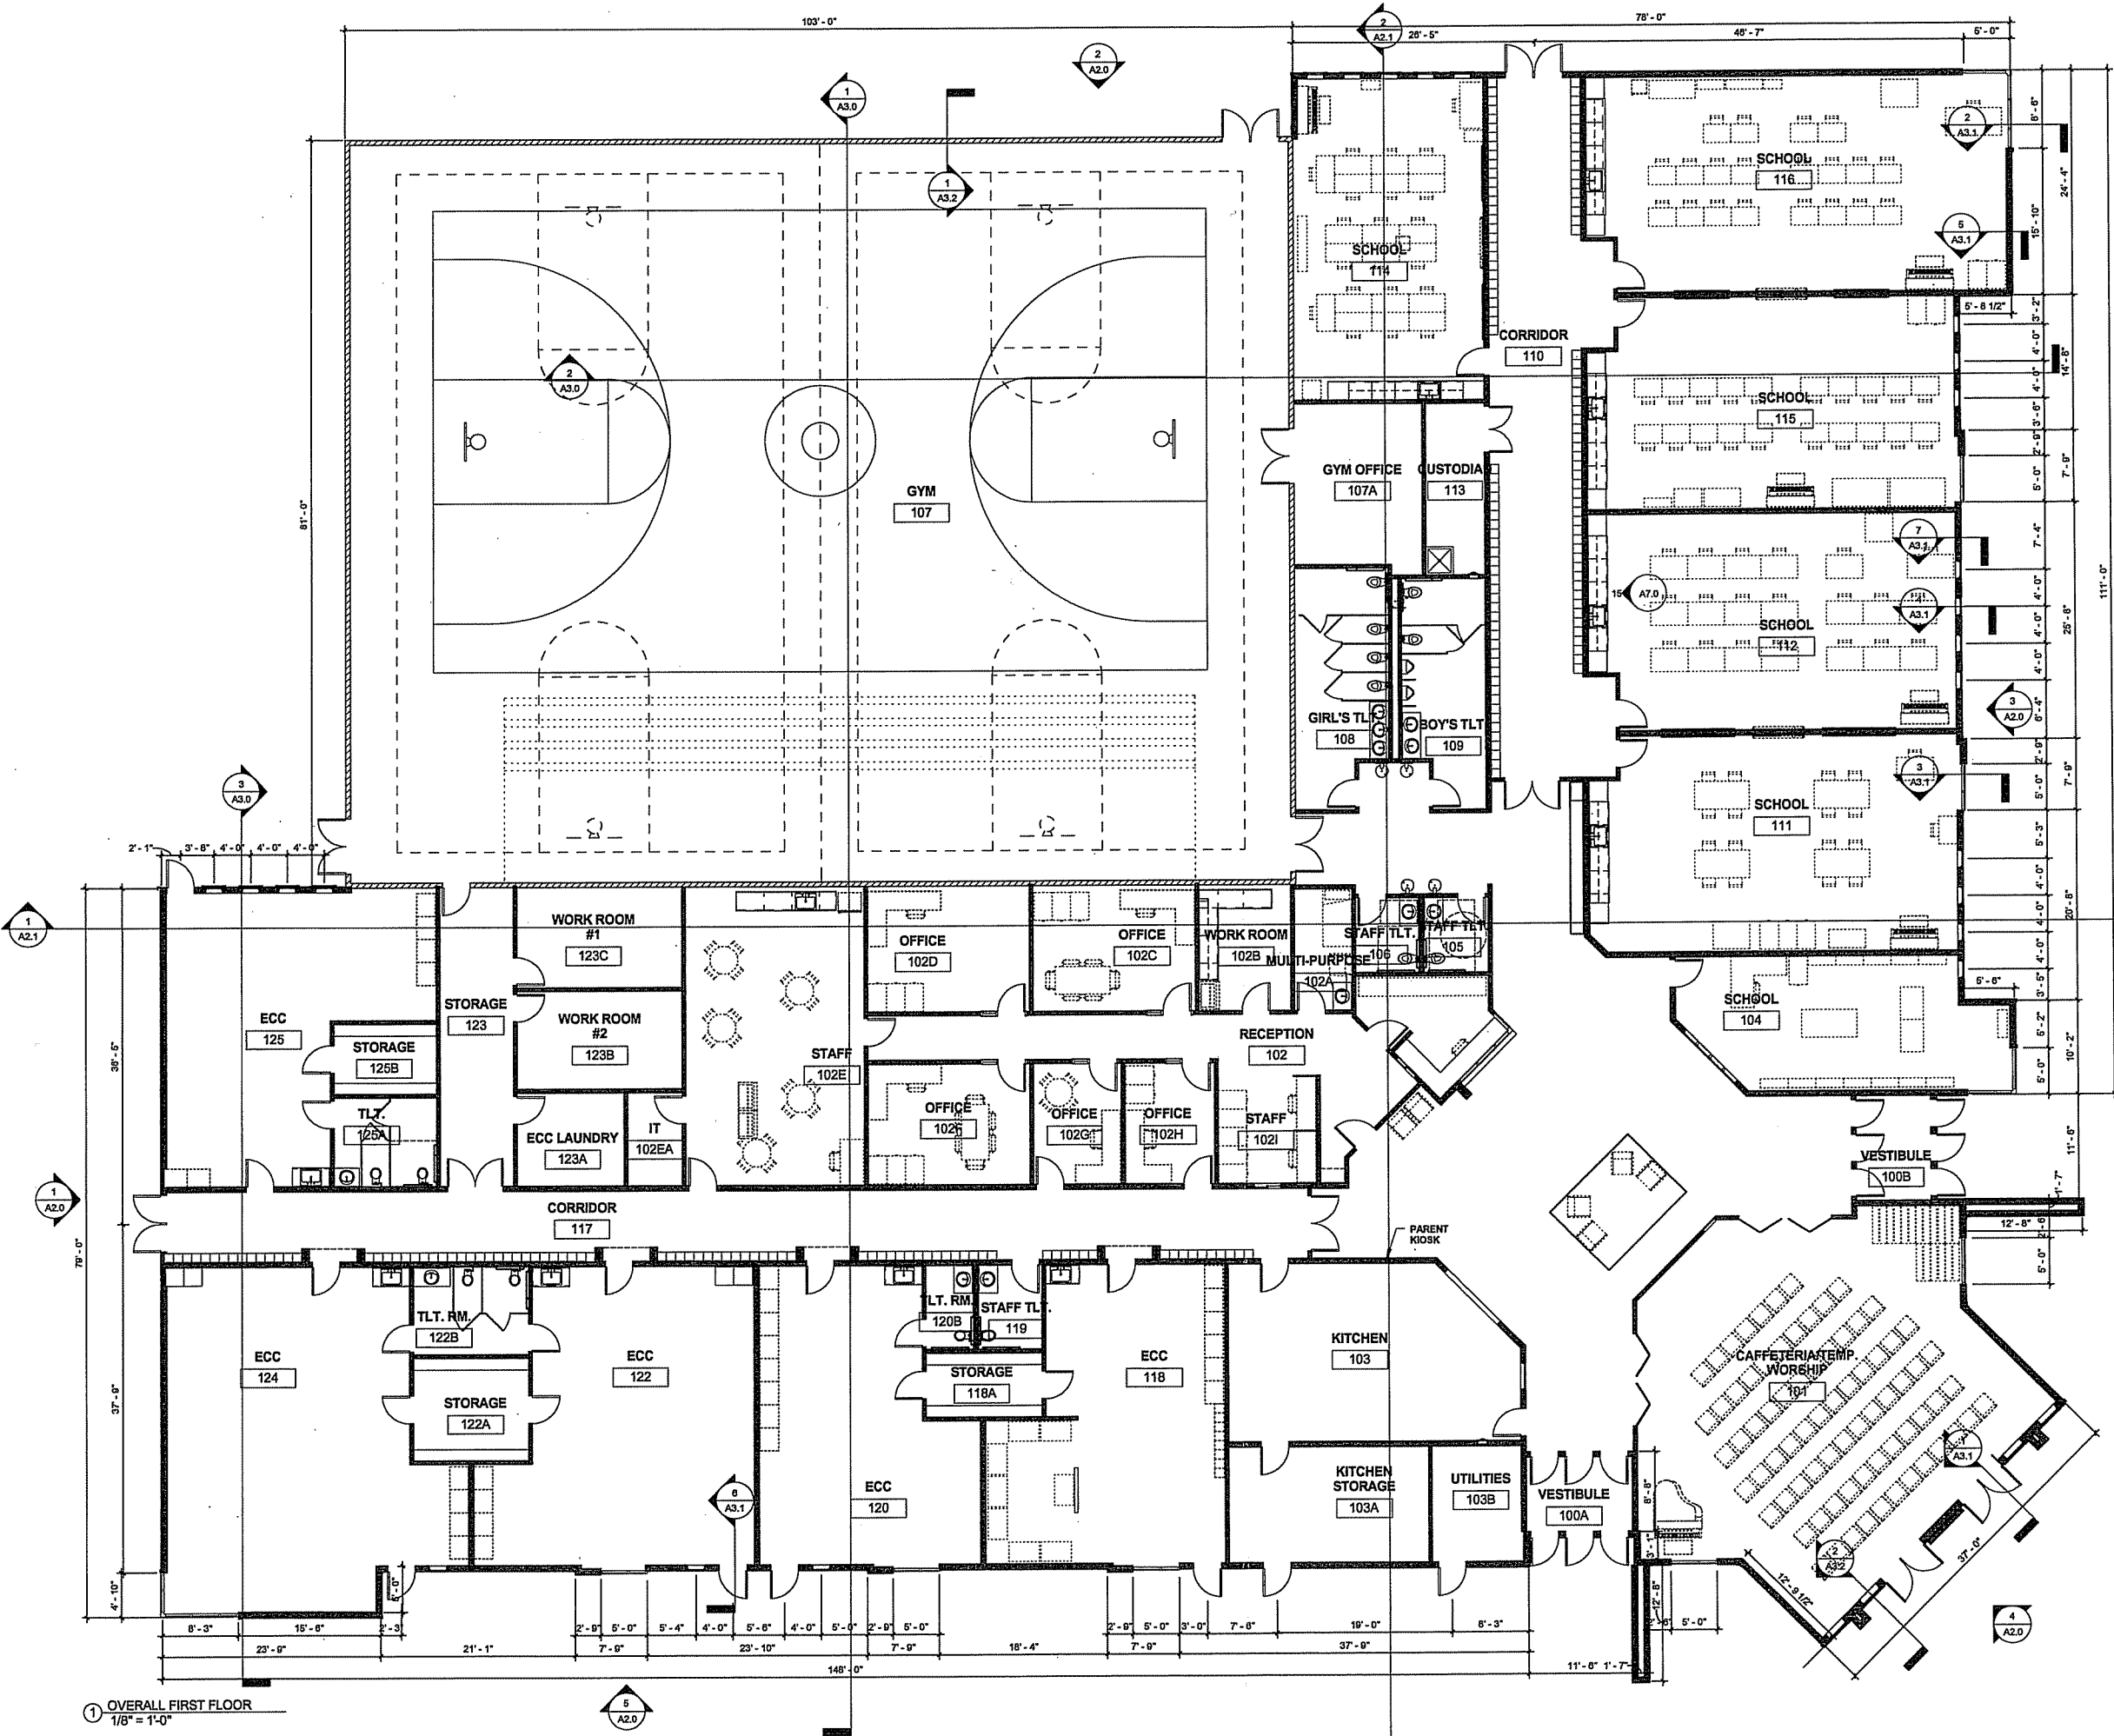

① OVERALL FIRST FLOOR
1/8" = 1'-0"

HOLY CROSS LUTHERAN
734 HOLY CROSS WAY
MADISON, WI

DEVELOPED BY:
HOLY CROSS LUTHERAN

EXTERIOR ELEVATION NOTES:

1. CONTRACTOR TO VERIFY ALL ROUGH OPENINGS.

ELEVATION KEYNOTES

- 1 VINYL SIDING: SAGE
- 2 VINYL SIDING: KHAKI
- 3 MANUFACTURED STONE
- 4 NOT USED
- 5 METAL BUILDING
- 6 ASPHALT SHINGLES
- 7 EPDM ROOF SYSTEM

6 SOUTH WEST ELEVATION
3/32" = 1'-0"

4 SOUTH ELEVATION
3/32" = 1'-0"

3 SOUTH EAST ELEVATION
3/32" = 1'-0"

2 NORTH EAST ELEVATION
1" = 10'-0"

1 NORTH WEST ELEVATION
1" = 10'-0"

GYM ROOF
127' - 6"

TRUSS BEARING
111' - 0"

FIRST FLOOR
100' - 0"

T.O. FOOTING
96' - 0"

GYM ROOF
127' - 6"

TRUSS BEARING
111' - 0"

FIRST FLOOR
100' - 0"

T.O. FOOTING
96' - 0"

GYM ROOF
127' - 6"

TRUSS BEARING
111' - 0"

FIRST FLOOR
100' - 0"

T.O. FOOTING
96' - 0"

GYM ROOF
127' - 6"

GYM WINDOW
HEAD HEIGHT
123' - 6"

TRUSS BEARING
111' - 0"

FIRST FLOOR
100' - 0"

T.O. FOOTING
96' - 0"

GYM ROOF
127' - 6"

GYM WINDOW
HEAD HEIGHT
123' - 6"

TRUSS BEARING
111' - 0"

FIRST FLOOR
100' - 0"

T.O. FOOTING
96' - 0"

INFORMATION ON THIS DRAWING TAKES
PRECEDENCE OVER THE SPECIFICATIONS MANUAL IF
THE DOCUMENTS HAVE CONFLICTING INFORMATION.

NO.	DATE	BY	DESCRIPTION

**EXTERIOR
ELEVATIONS**

SCALE: As Indicated SHEET:

PROJECT #: 1203

DRWN BY: BAB

CHKD BY: DCB

DATE:

A2.0

A2K
A Subsidiary of Schneider & Holt Architects

311 East Chicago Street
Suite 310
Milwaukee, WI 53202

p. 414-727-3321
f. 414-276-1764
www.sha-a2k.com

HOLY CROSS LUTHERAN
734 HOLY CROSS WAY
MADISON, WI



DEVELOPED BY:
HOLY CROSS LUTHERAN

EXTERIOR ELEVATION NOTES:

1. CONTRACTOR TO VERIFY ALL ROUGH OPENINGS.

ELEVATION KEYNOTES

- 1 VINYL SIDING: SAGE
- 2 VINYL SIDING: KHAKI
- 3 MANUFACTURED STONE
- 4 NOT USED
- 5 METAL BUILDING
- 6 ASPHALT SHINGLES
- 7 EPDM ROOF SYSTEM

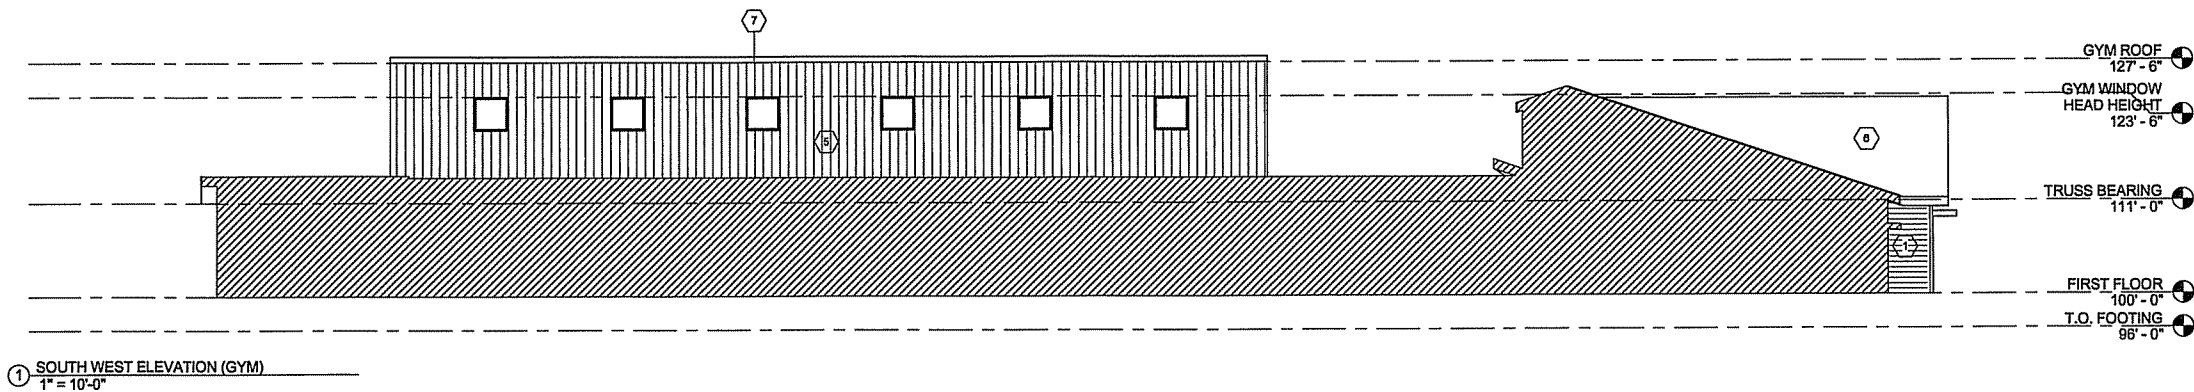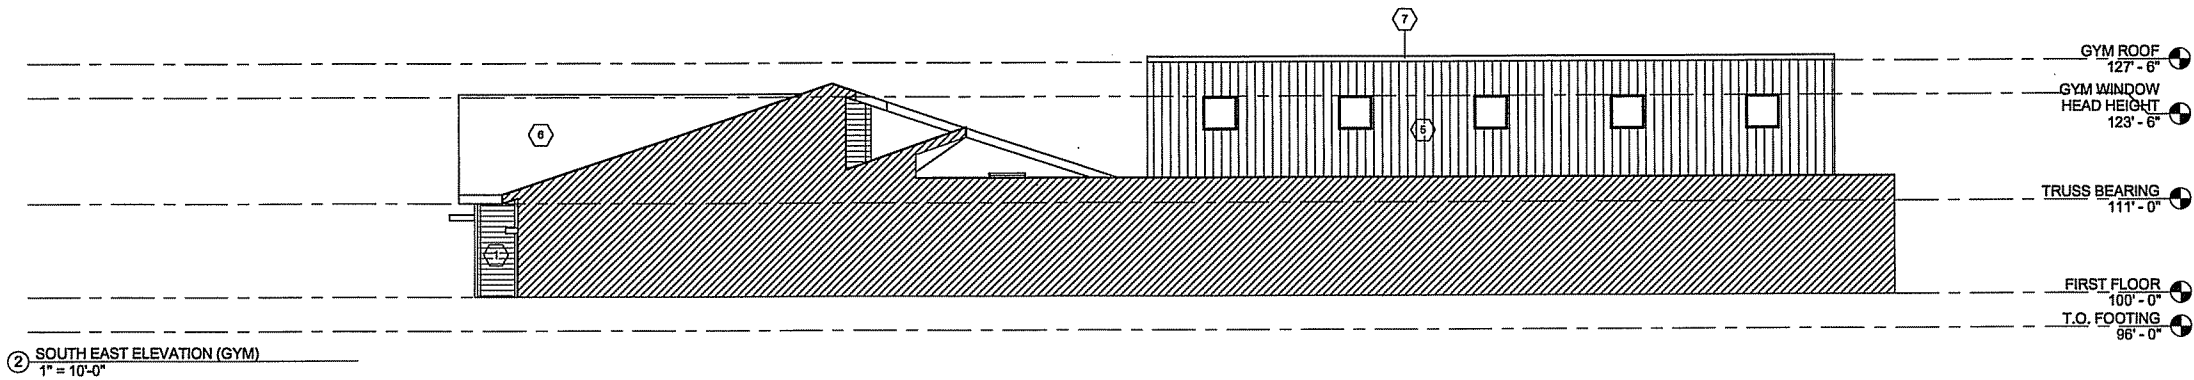


INFORMATION ON THIS DRAWING TAKES PRECEDENCE OVER THE SPECIFICATIONS MANUAL IF THE DOCUMENTS HAVE CONFLICTING INFORMATION.

NO.	DATE	BY	DESCRIPTION

EXTERIOR ELEVATIONS

SCALE: As Indicated SHEET: PROJECT #: 1203
DRWN BY: BAB
CHKD BY: DCB
DATE: A2.1

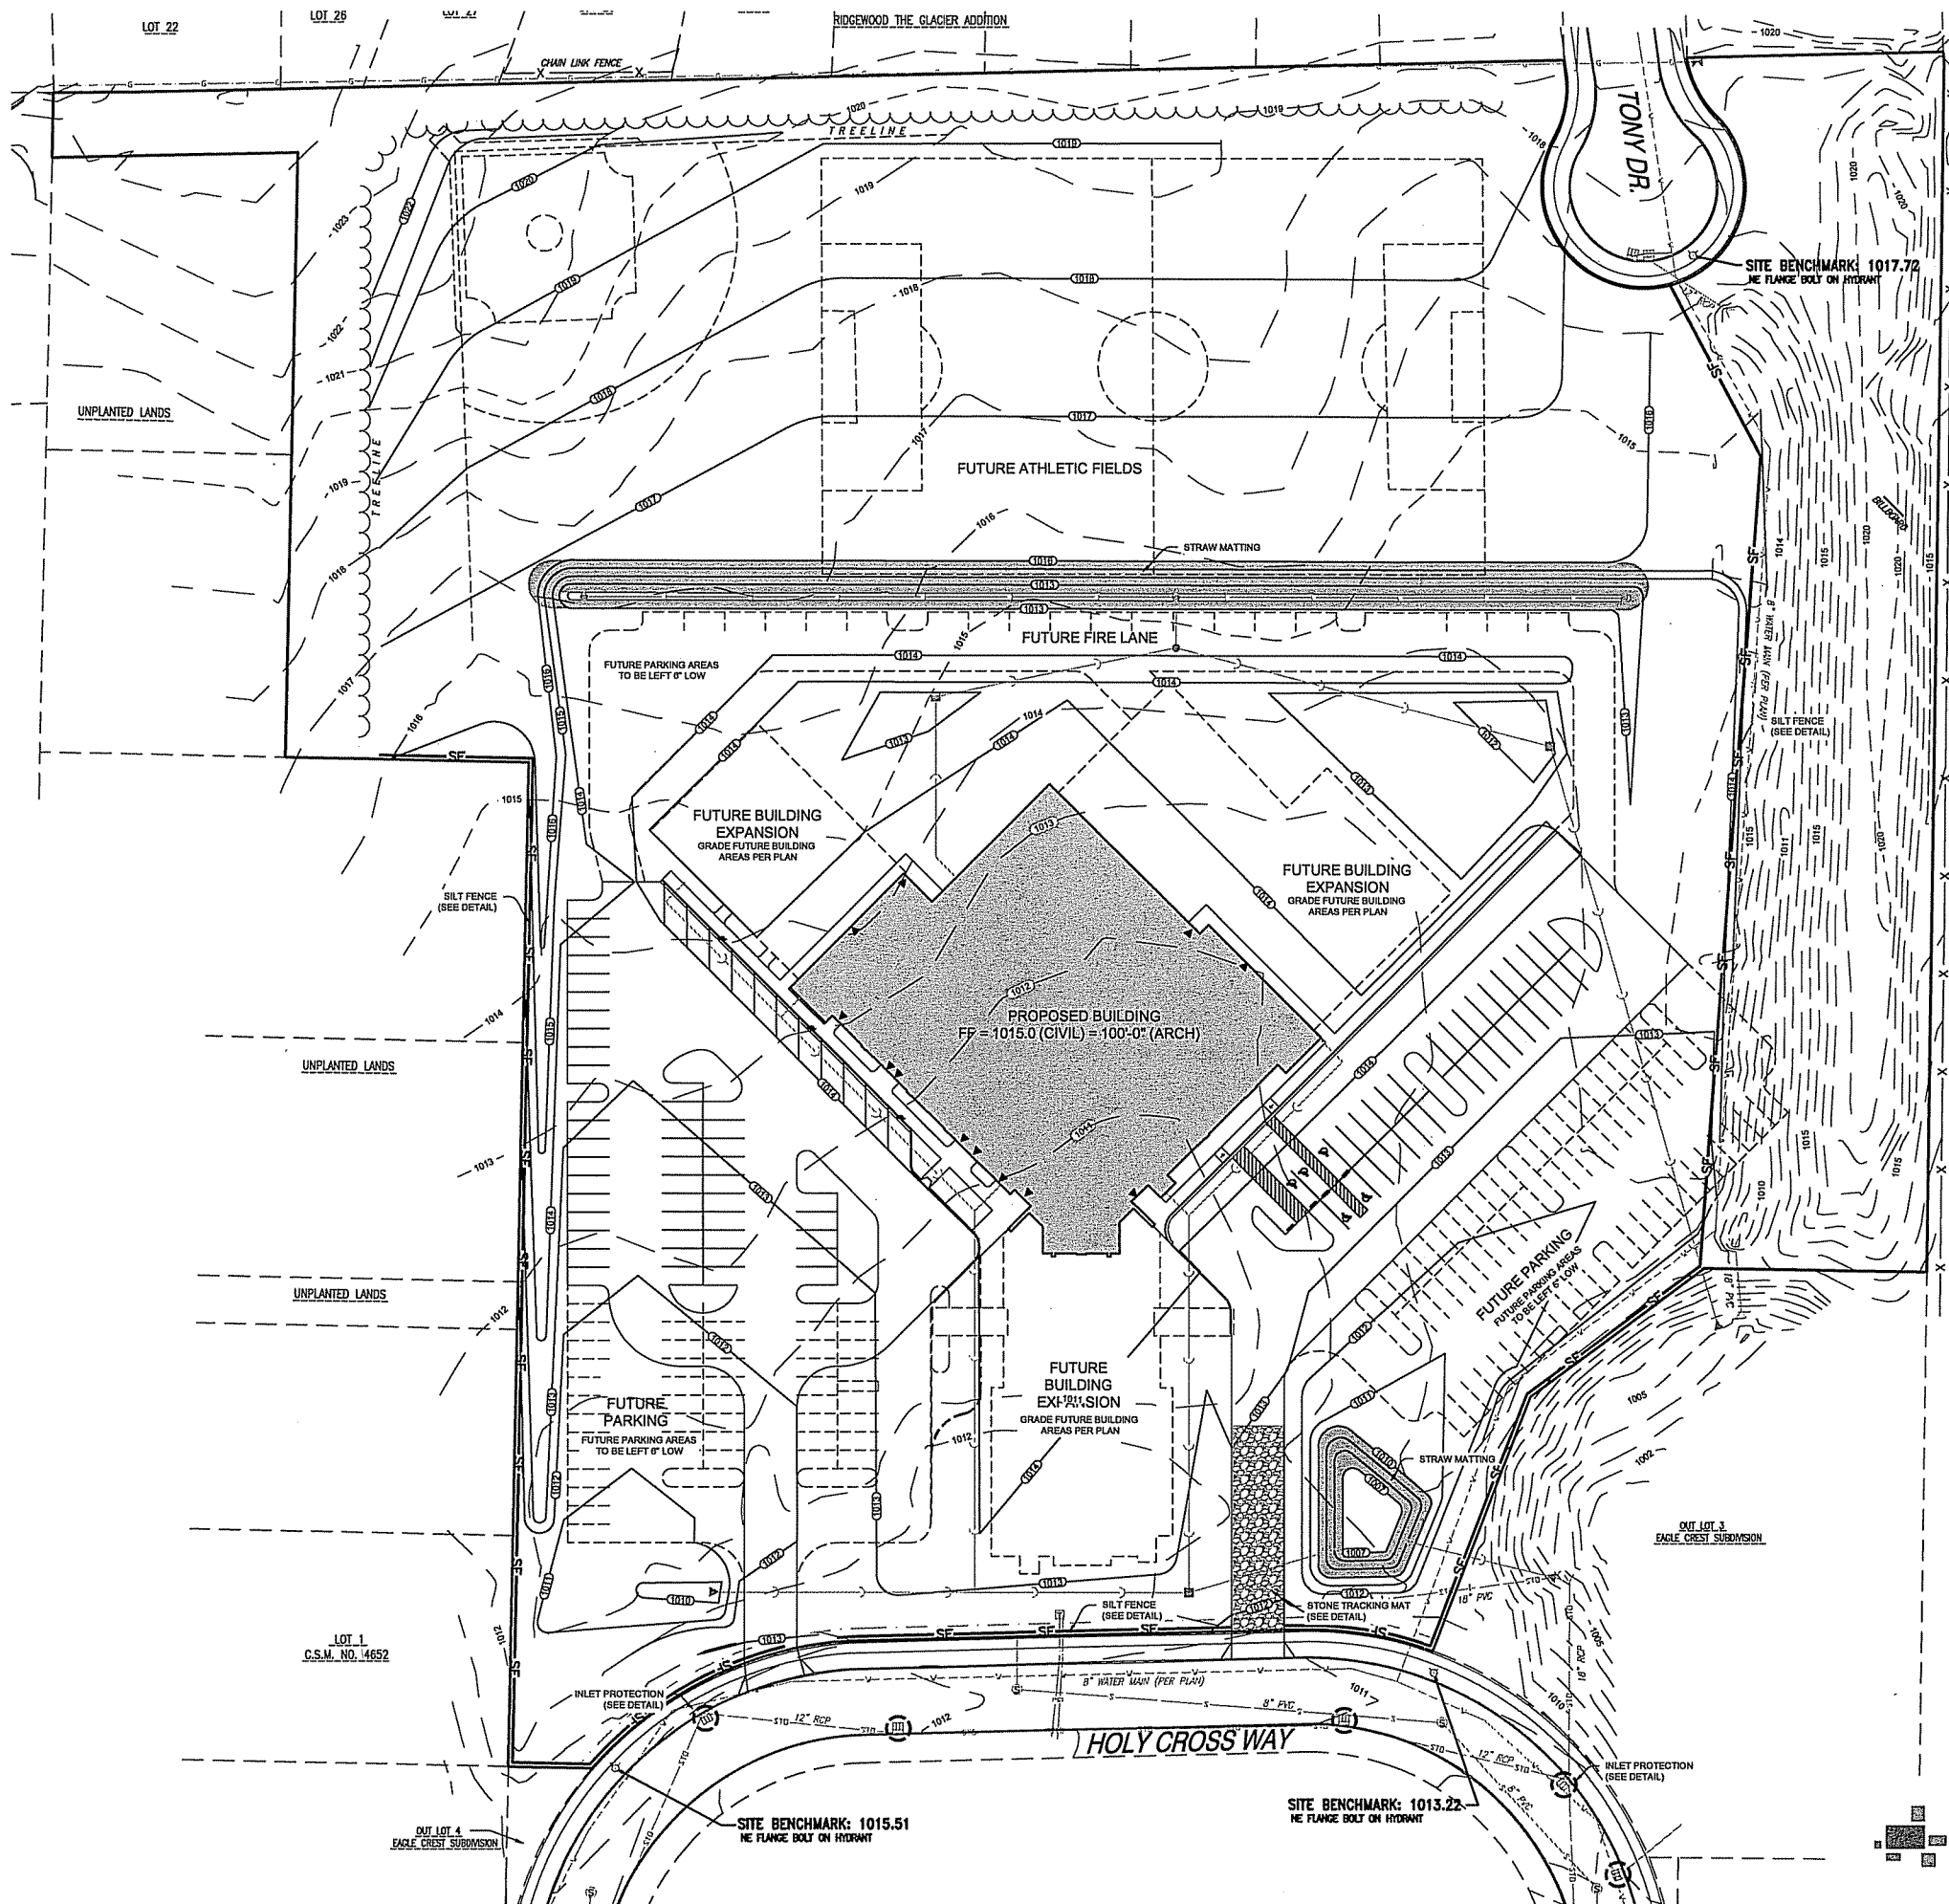

LEGEND

- STORM SEWER MANHOLE
- STORM SEWER CATCH BASIN
- CONTOUR
- 750.00 SPOT ELEVATION
- SILT FENCE
- INLET PROTECTION

A2K
A Subsidiary of Schneider & Heit Architects

311 East Chicago Street
Suite 310
Milwaukee, WI 53202

p. 414-727-2921
f. 414-276-1764
www.a2k.com

HOLY CROSS LUTHERAN
734 HOLY CROSS WAY
MADISON, WI 53704

DEVELOPED BY:

INTERSTATE HIGHWAYS 90, 94 & 39

NORTH

GRAPHICAL SCALE (FEET)

0 1" = 40' 80'

PLAN PREPARED BY:

PINNACLE ENGINEERING GROUP

ENGINEERING | NATURAL RESOURCES | SURVEYING

WISCONSIN OFFICE
15430 W. BUSHMAN ROAD
MADISON, WI 53704
(608) 734-4444

CHICAGO OFFICE
1100 N. LAKE STREET
CHICAGO, IL 60610
(312) 467-4444

INFORMATION ON THIS DRAWING TAKES PRECEDENCE OVER THE SPECIFICATIONS MANUAL IF THE DOCUMENTS HAVE CONFLICTING INFORMATION.

NO.	DATE	BY	DESCRIPTION
	01/30/15	PEG	PERMIT SET

GRADING & EROSION CONTROL PLAN

SCALE: 1"=40' SHEET:

PROJECT #: 1203

DRWN BY: BDP

CHKD BY: AEK

DATE: 01/01/15

C3.0

2015-01-30 Permit Set